



ROOF DRAINAGE PLAN
1:200

ROOF DRAIN
1 IS TO 4 SLOPE TYPICAL
STANDARD MANHOLE REFER TO DWG WT-S040 FOR DETAIL

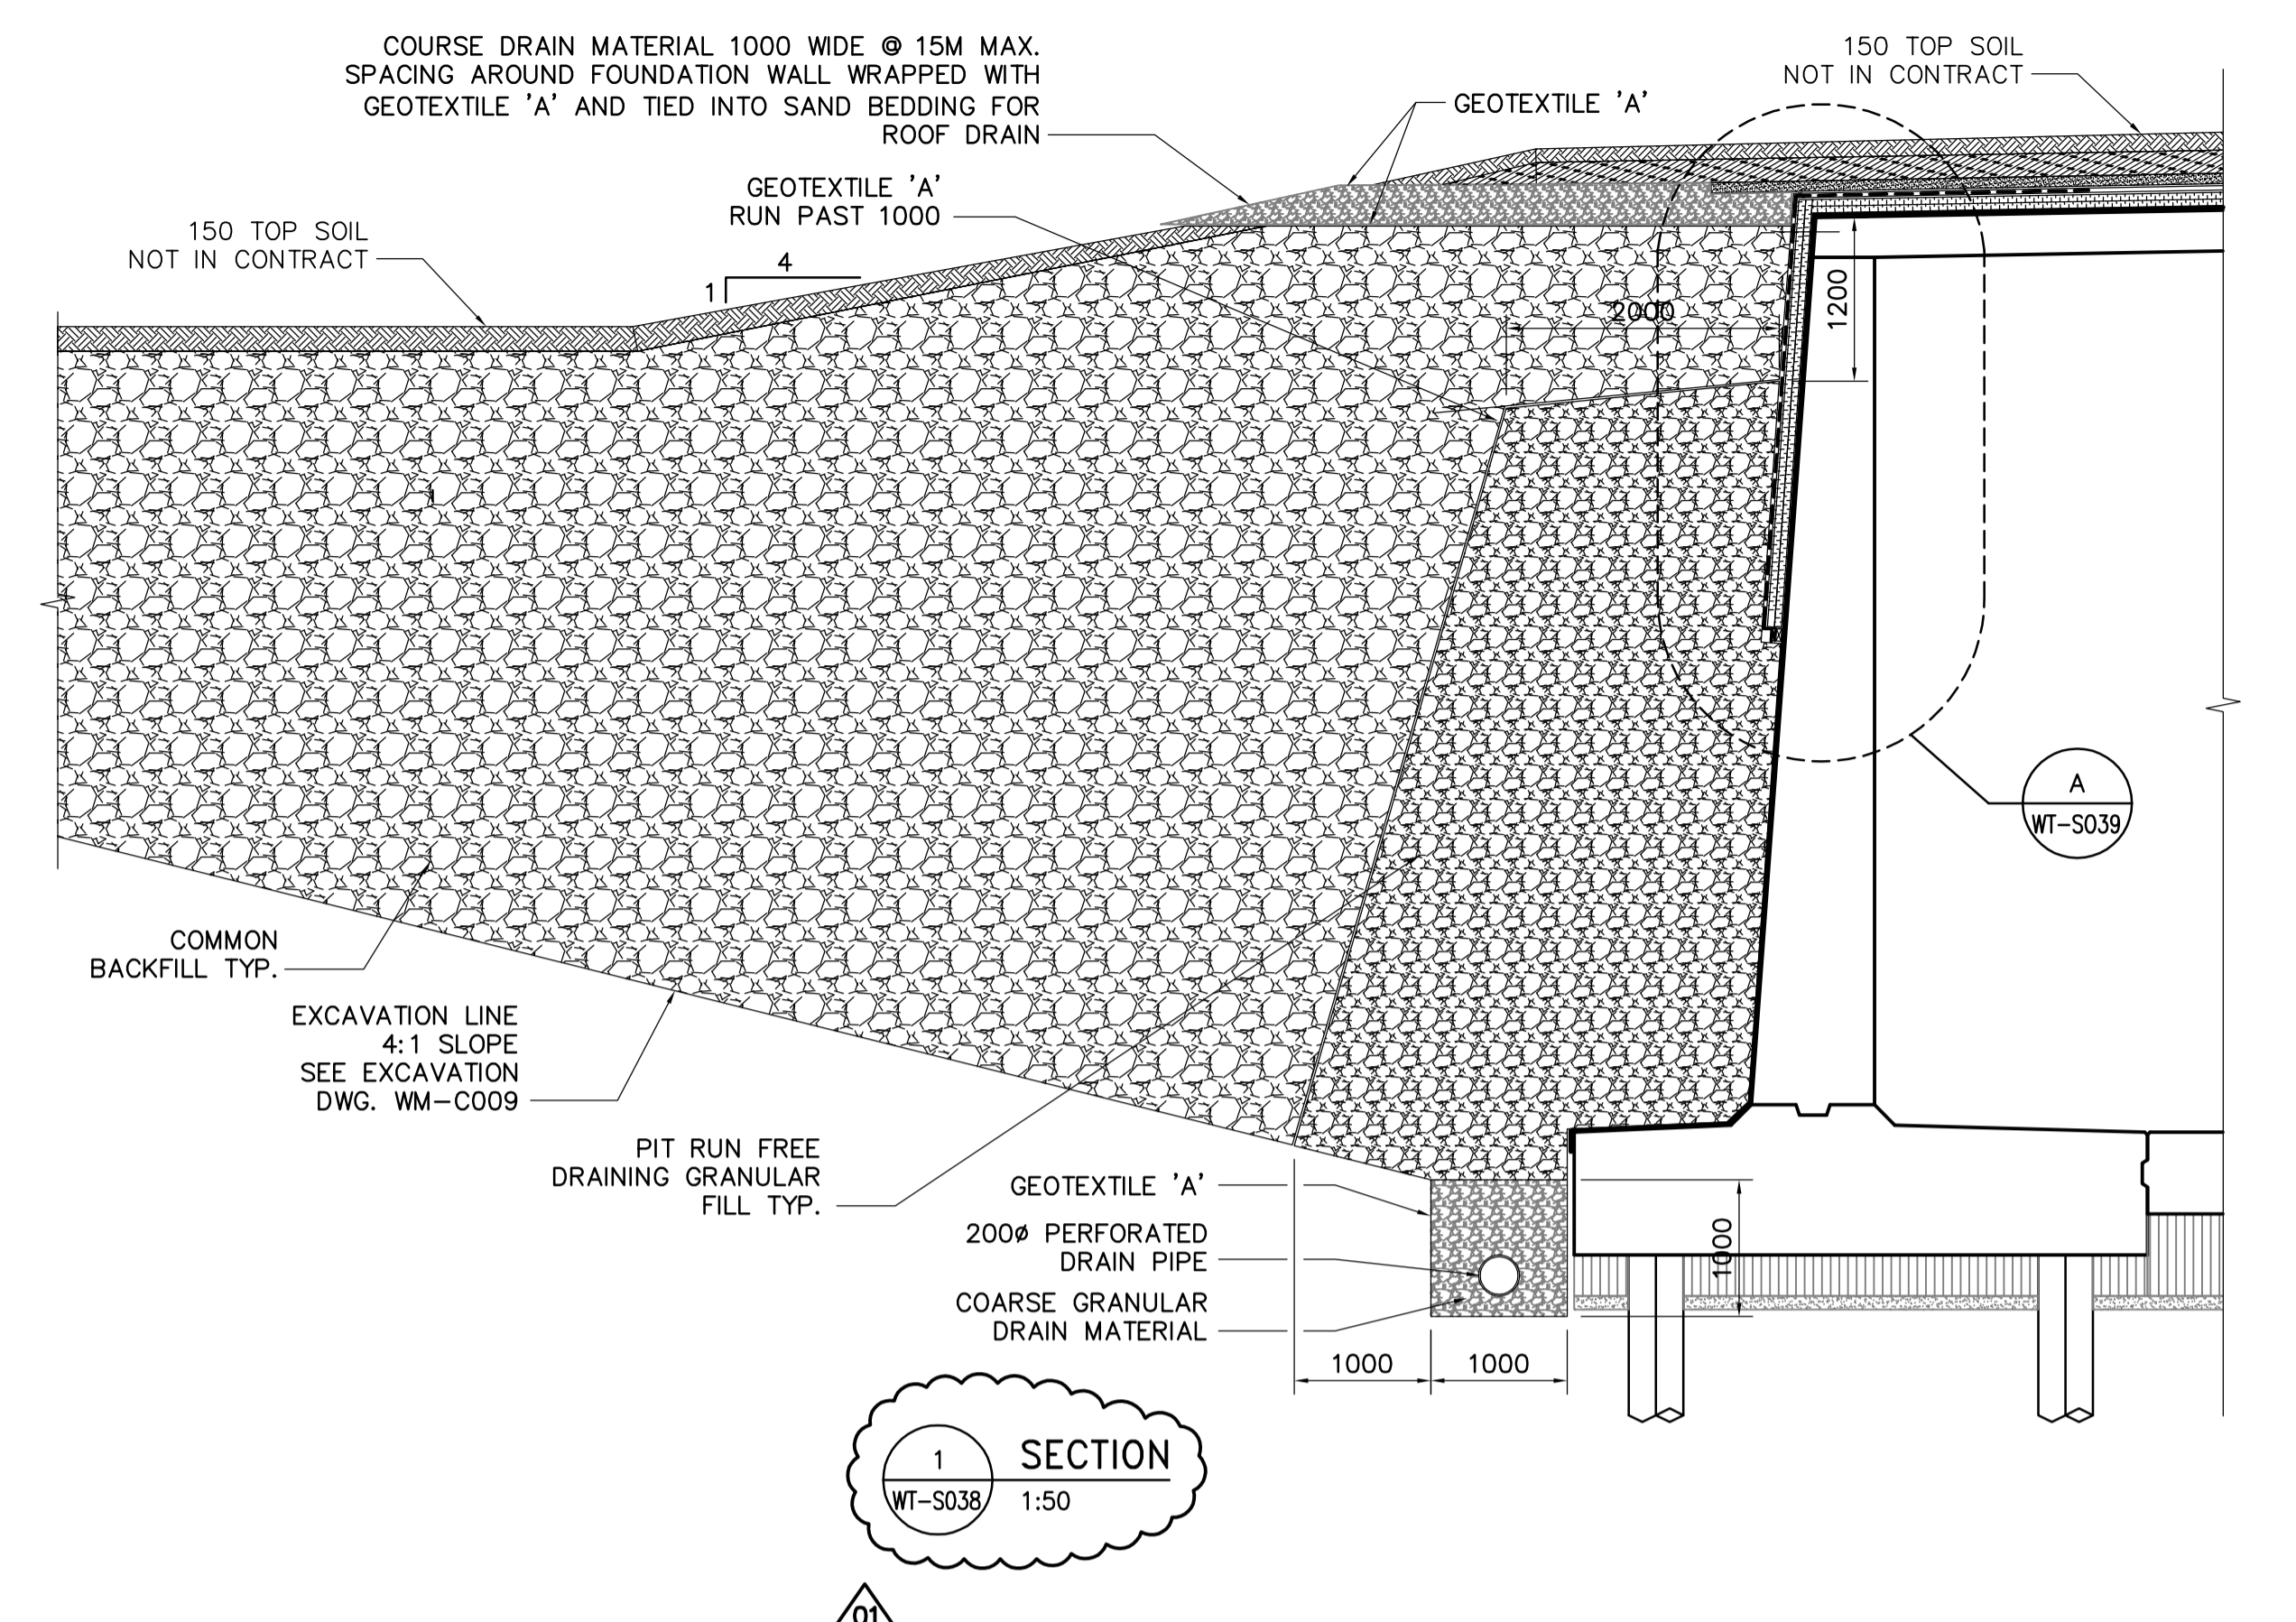

SECTION 1
WT-S038
1:50

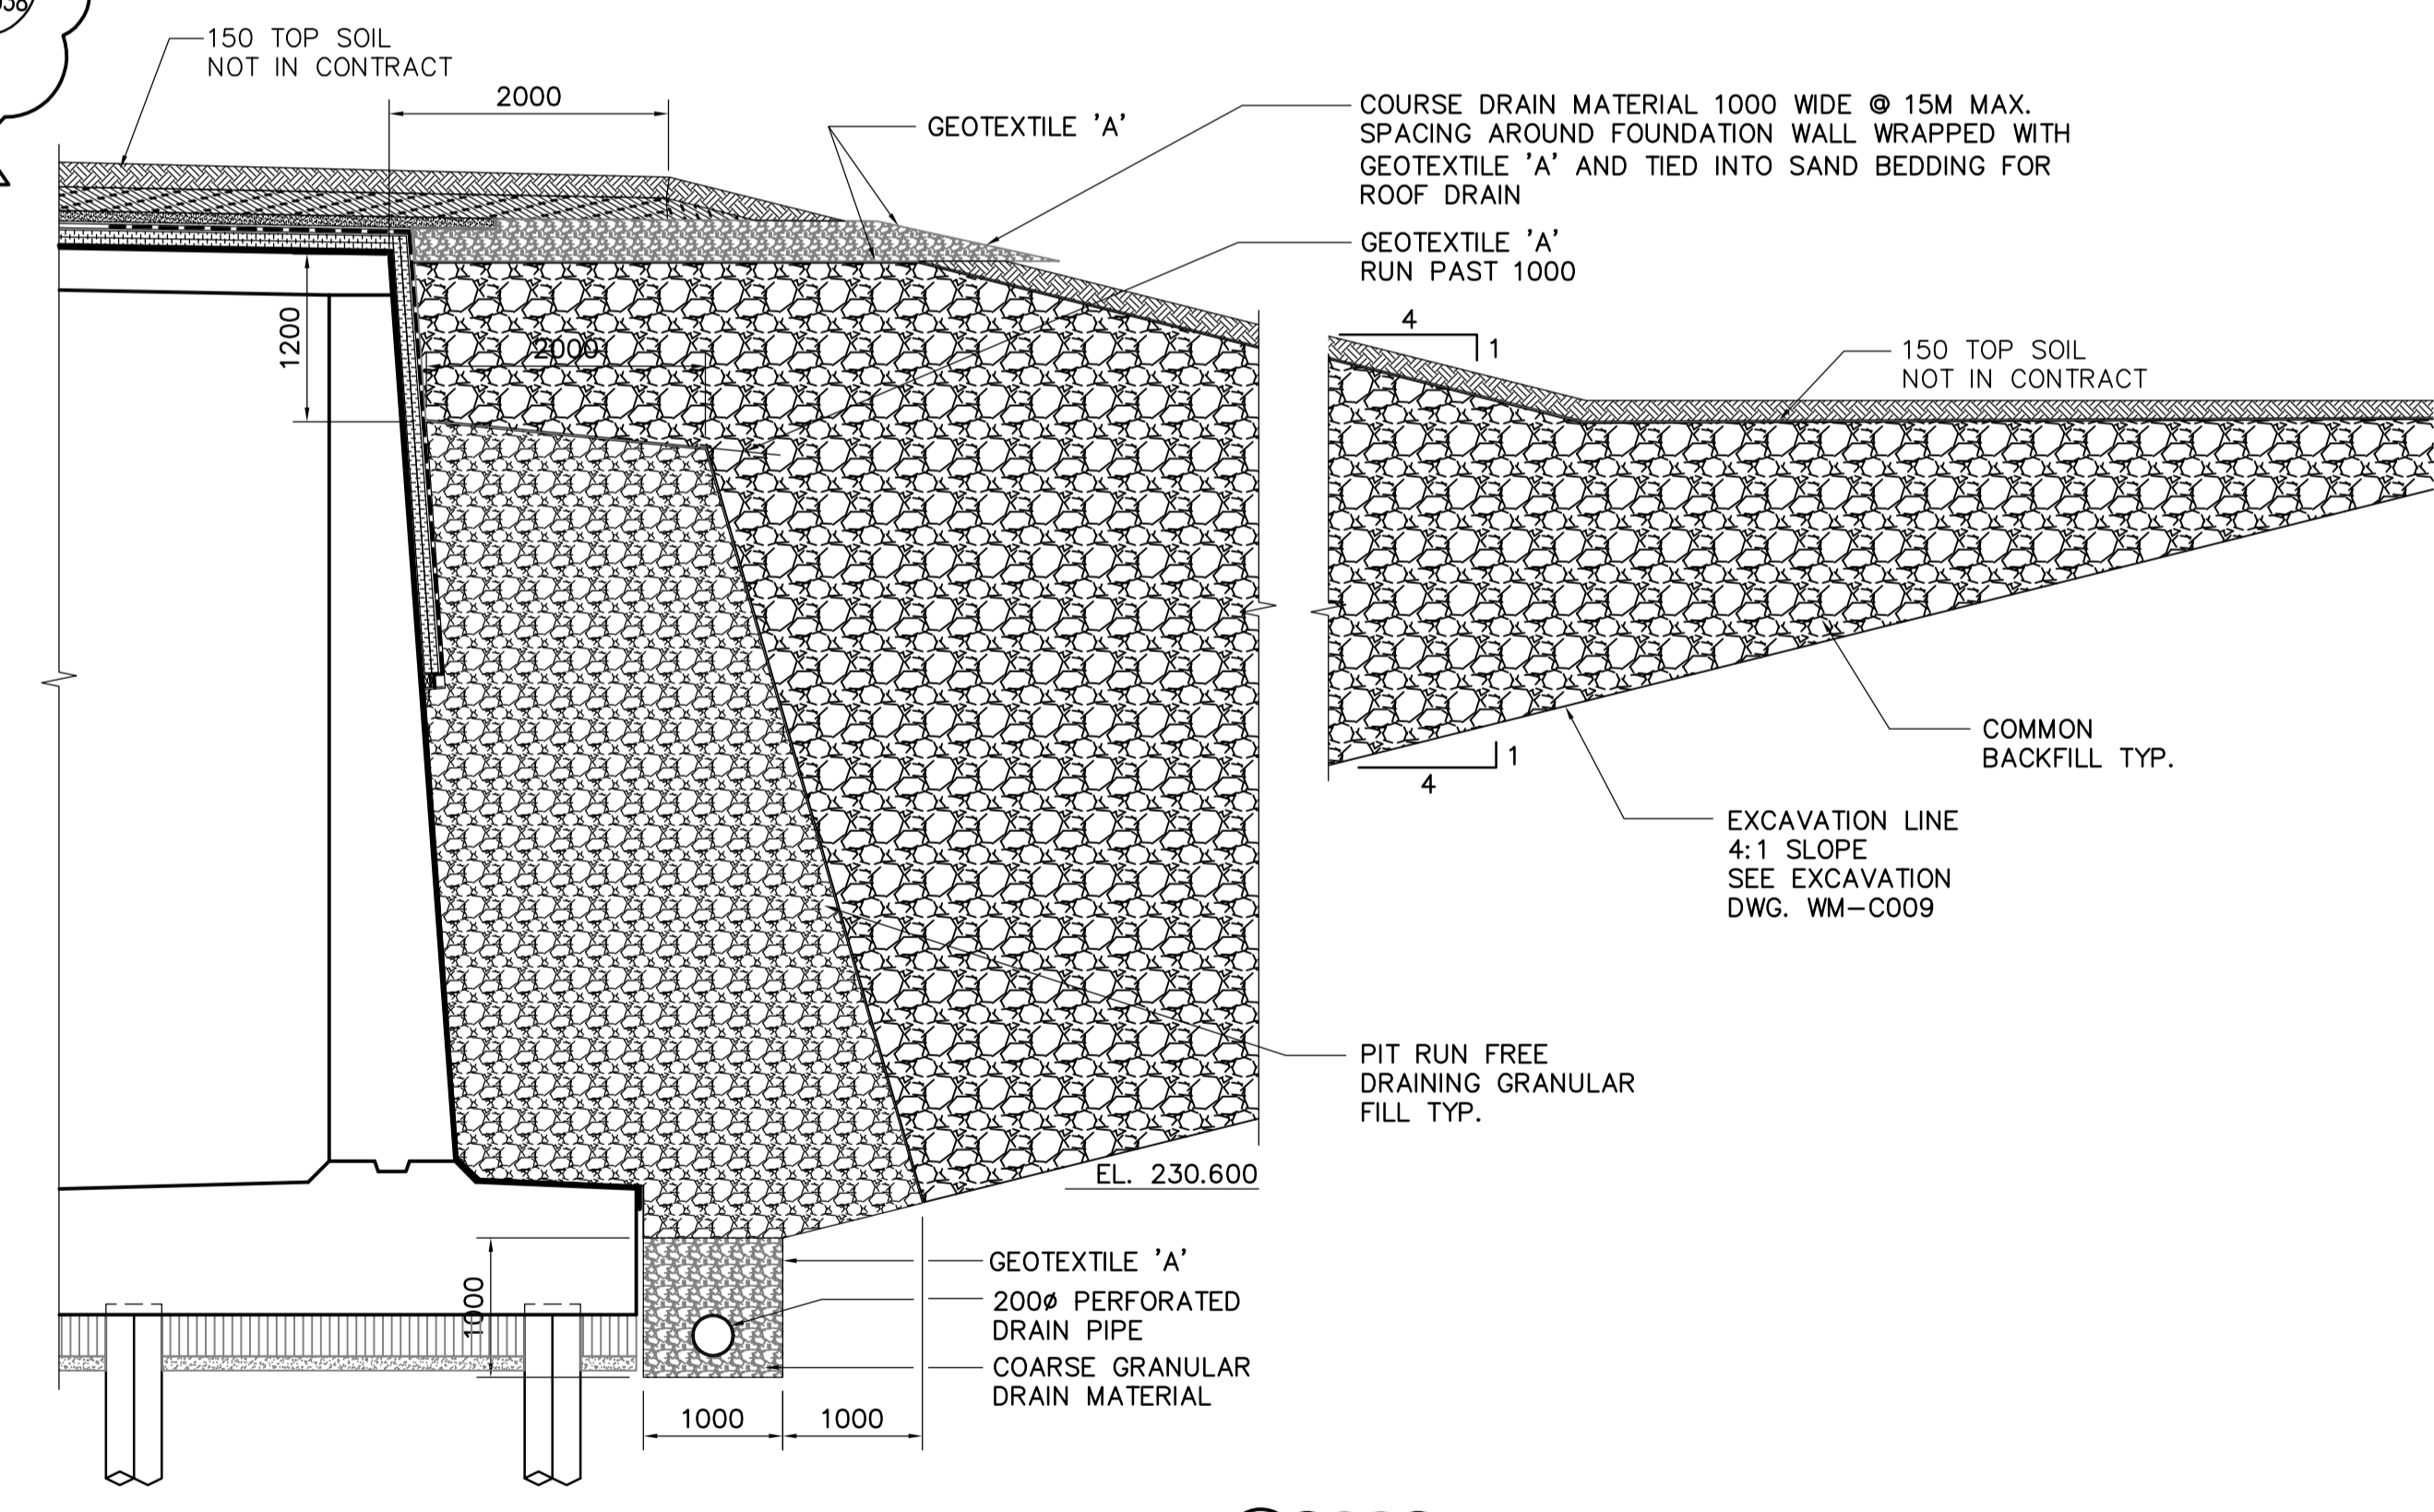

SECTION 2
WT-S038
1:50

APEGM
Certificate of Authorization
Earth Tech Canada Inc.
No. 730 Expiry: April 30, 2006

B.M.	ELEV.	NO.	REVISIONS	DATE	BY
01	166-2005 ADDENDUM 1	05/05/06	C.T.		
00	ISSUED FOR TENDER	05/04/17	C.T.		

DESIGNED BY	CHECKED BY	DRAWN BY	APPROVED BY	HOR. SCALE:	VERTICAL SCALE:	RELEASED FOR CONSTRUCTION BY:
FK	MK	C.T. / WDB	AHL	AS NOTED		R. SOROKOWSKI
				DATE	DATE	
				2005/03/09	2005-04-17	

ENGINEER'S SEAL
ORIGINAL SIGNED BY
F.A. KEMP
2005/04/17
CONSULTANT DRAWING NO.
WT-S038

THE CITY OF WINNIPEG
WATER AND WASTE DEPARTMENT
ENGINEERING DIVISION

WATER TREATMENT PLANT CLEARWELL CONSTRUCTION

STRUCTURAL ROOF DRAINAGE PLAN
DETAIL SECTION OF MANHOLE

CITY FILE NUMBER
SHEET OF
CITY DRAWING NUMBER
1-060T-A-S0038-001-01D