



NOTES:

- DESIGN LIVE LOAD IS 4.8 kPa EXCEPT ON LOW ROOF.
- FOR COLUMN AND BEAM SCHEDULE SEE DWG WA-S0515.
- PROVIDE CURBS FOR CMU WALLS INSTALLED IN SEPARATE CONTRACT. COORDINATE CURB WIDTH WITH CMU WALL WIDTH. FOR BIDDING PURPOSES ASSUME CURBS ARE 260mm WIDE.



REBAR LEGEND:

- TOP BARS
- BOTTOM BARS

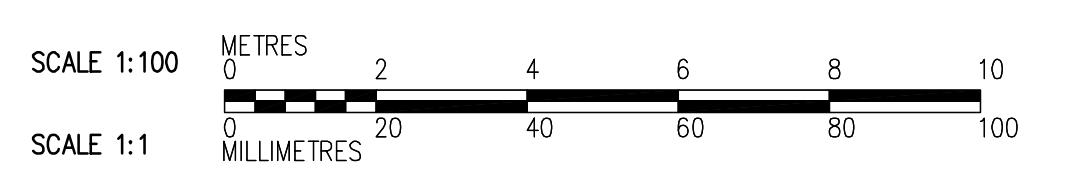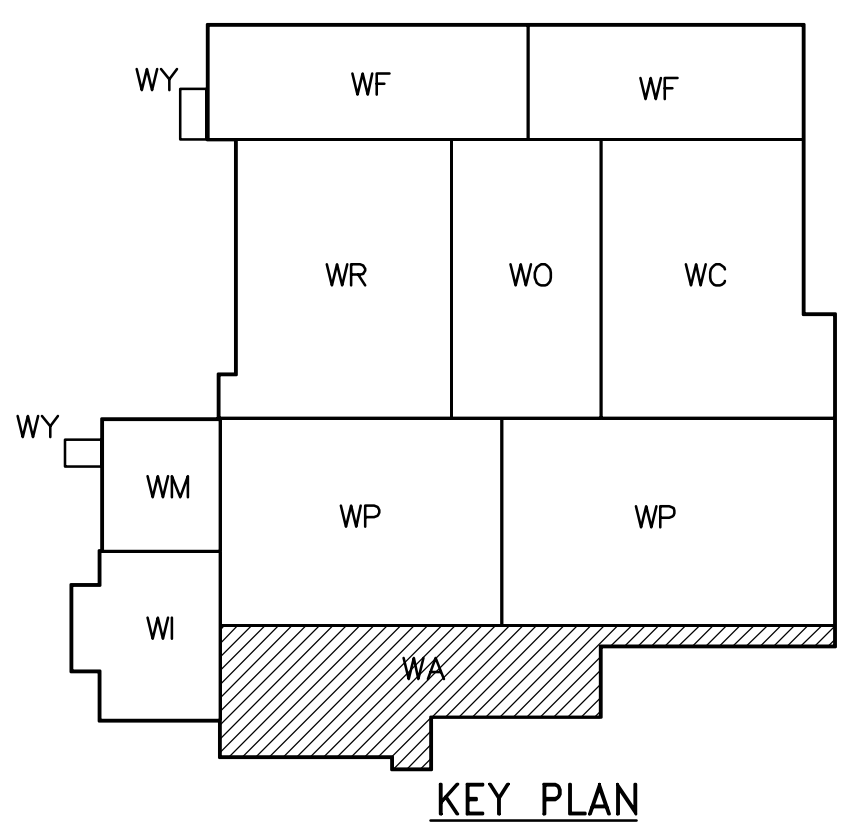

<p>APEGN Certificate of Authorization CH2M HILL Canada Ltd. No. 1441 Expiry: April 30, 2006</p>	<p>Frederickson Cooper ARCHITECTS</p>	<p>EarthTech A Tyco International Ltd. Company</p>	ENGINEER'S SEAL ORIGINAL SIGNED BY D. KRUGER 2006/02/06	<p>THE CITY OF WINNIPEG WATER AND WASTE DEPARTMENT ENGINEERING DIVISION</p>	CITY FILE NUMBER	
			DESIGNED BY MC CHECKED BY AP DRAWN BY RL APPROVED BY DJT SCALE: 1:100 RELEASED FOR CONSTRUCTION BY: R. SOROKOWSKI 2005/07/04 DATE		CONSULTANT DRAWING NO. WA-S0131	SHEET OF
WATER TREATMENT PLANT ADMINISTRATION FOUNDATIONS AND CONCRETE STRUCTURES				STRUCTURAL ADMINISTRATION AREA THIRD FLOOR PLAN		CITY DRAWING NUMBER 1-0601A-A-001-001-0D