


NOTES:
1. BACKGROUND HIDDEN LINES REVISED OR SHOWN FOR CLARITY.

PLAN AT ELEVATION 245.000
1:100

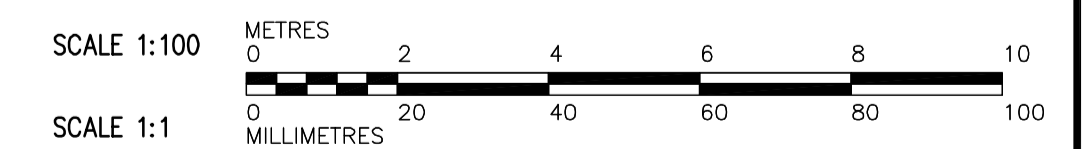

 APEGN Certificate of Authorization CH2M HILL Canada Ltd. No. 1441 Expiry: April 30, 2006	B.M. ELEV.		 Frederickson Cooper ARCHITECTS	 A Tyco International Ltd. Company	ENGINEER'S SEAL	 THE CITY OF WINNIPEG WATER AND WASTE DEPARTMENT ENGINEERING DIVISION	CITY FILE NUMBER
	DESIGNED BY: TB/PW	CHECKED BY: LS			ORIGINAL SIGNED BY: P. WOBMA		SHEET OF
	DRAWN BY: TAR/EK	APPROVED BY: DJT	2006/02/06	WATER TREATMENT PLANT FILTRATION FOUNDATION AND CONCRETE STRUCTURES			
	SCALE: 1:100	RELEASED FOR CONSTRUCTION BY: R. SOROKOWSKI	CONSULTANT DRAWING NO. WF-M9132	CITY DRAWING NUMBER 1-060F-A-M9132-001-01D			
01 583-2005 ADDENDUM 3 06/03/10 PW	00 ISSUED FOR TENDER 2006/02/03 PW	DATE 2005/07/08	DATE 2006/02/08	PROCESS MECHANICAL PIPE EMBEDS FILTRATION AREA 2 THIRD FLOOR PLAN			