
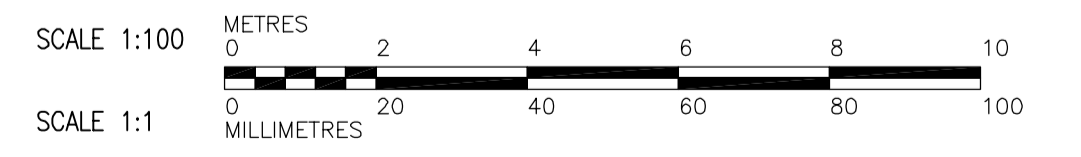


LIFTING EYE
 ⊕ TYPE "1" (900 kg)
 ⊗ TYPE "2" (1800 kg)

THIRD FLOOR PLAN AT EL. 245.000
 1:100

- NOTES:**
- FOR BEAM AND COLUMN SCHEDULE SEE DWG. WF-S0515
 - 5 PIECES ALUMINIUM GRATING (TYP.), HINGED TO THE CURB, TO NORTH SIDE IN EACH FILTER.
 - CMU WALL (NIC) TO BE PROVIDED AT ALL EXTERIOR LOCATION FROM EL.245.000 TO EL.248.300 FOR DOWELS SEE DETAIL.

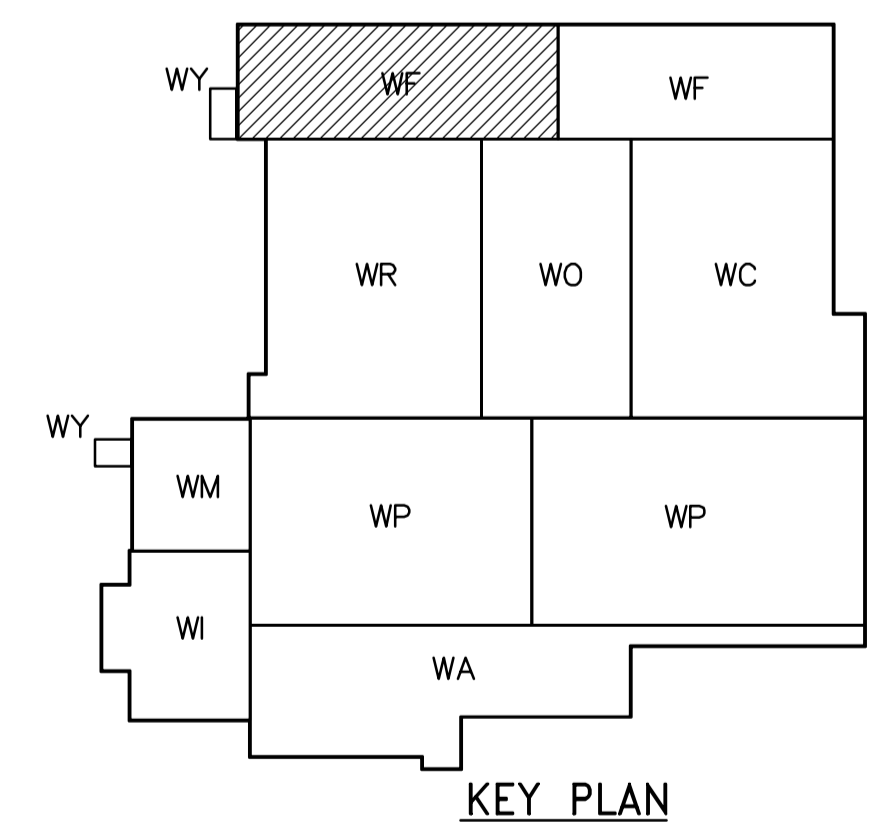

 APEGN Certificate of Authorization CH2M HILL Canada Ltd. No. 1441 Expiry: April 30, 2006	B.M. ELEV.	 Frederickson Cooper ARCHITECTS	 A Tetra International Ltd. Company	ENGINEER'S SEAL	 THE CITY OF WINNIPEG WATER AND WASTE DEPARTMENT ENGINEERING DIVISION
	DESIGNED BY: KA DRAWN BY: PM SCALE: 1:100			CHECKED BY: AP APPROVED BY: DJT RELEASED FOR CONSTRUCTION BY: R. SOROKOWSKI	
01 583-2005 ADDENDUM 3 06/03/10 KA 00 ISSUED FOR TENDER 2006/02/03 KA	DATE BY DATE DATE 2005/08/10 2006/02/08	CONSULTANT DRAWING NO. WF-S0131		WATER TREATMENT PLANT FILTRATION FOUNDATIONS AND CONCRETE STRUCTURES STRUCTURAL FILTRATION AREA 1 THIRD FLOOR PLAN	