


REBARS LEGEND:
 ——— TOP BARS
 - - - - - BOTTOM BARS
 - - - - - DRAIN PIPE CENTERLINE

- NOTES:**
- FOR CORNER REINF SEE (4) WB-S0442
 - CENTERLINE OF PIPE OPNG:
NORTHING: 5524036.069
EASTING: 647835.819
 - CENTERLINE OF PIPE OPNG:
NORTHING: 5524029.071
EASTING: 647831.455
 - REFER TO DRAWING WI-0515 FOR COLUMN SCHEDULE.

LOWER LEVEL PLAN
1:100

NOT IN CONTRACT

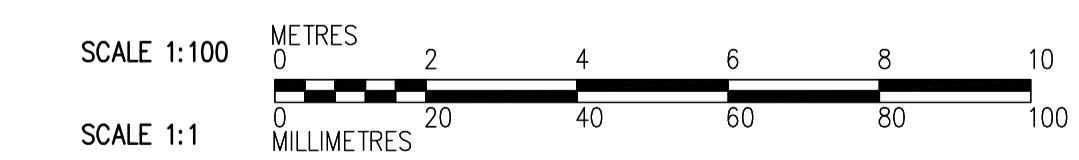

 Certificate of Authorization CH2M Hill Canada Limited (ON) No. 1441 Expiry: April 30, 2006	 Frederickson Cooper ARCHITECTS		 A Tyco International Ltd. Company		ENGINEER'S SEAL ORIGINAL SIGNED BY D. KRUGER 2005/10/28	 THE CITY OF WINNIPEG WATER AND WASTE DEPARTMENT ENGINEERING DIVISION FOUNDATIONS AND CONCRETE STRUCTURES 1 STRUCTURAL RAW WATER PUMP STATION AREA LOWER LEVEL PLAN	CITY FILE NUMBER
	DESIGNED BY: EL CHECKED BY: AP DRAWN BY: RL APPROVED BY: AHL SCALE: 1:100 RELEASED FOR CONSTRUCTION BY: R. SOROKOWSKI DATE: 2005/07/06 DATE: 2005/10/28	CONSULTANT DRAWING NO. WI-S0101	SHEET OF CITY DRAWING NUMBER 1-0601-A-8001-001-02D				