
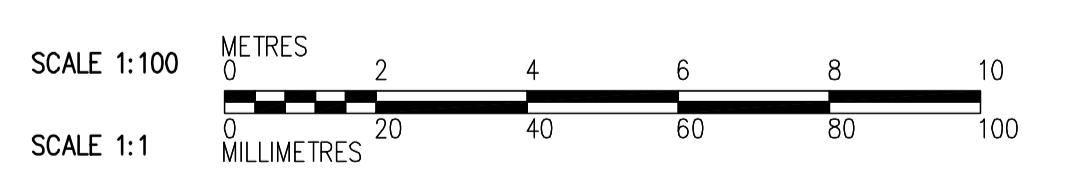


**NOTE:**  
1. FIELD VERIFY DIMENSIONS PRIOR TO FABRICATION.

ROOF PLAN  
1:100

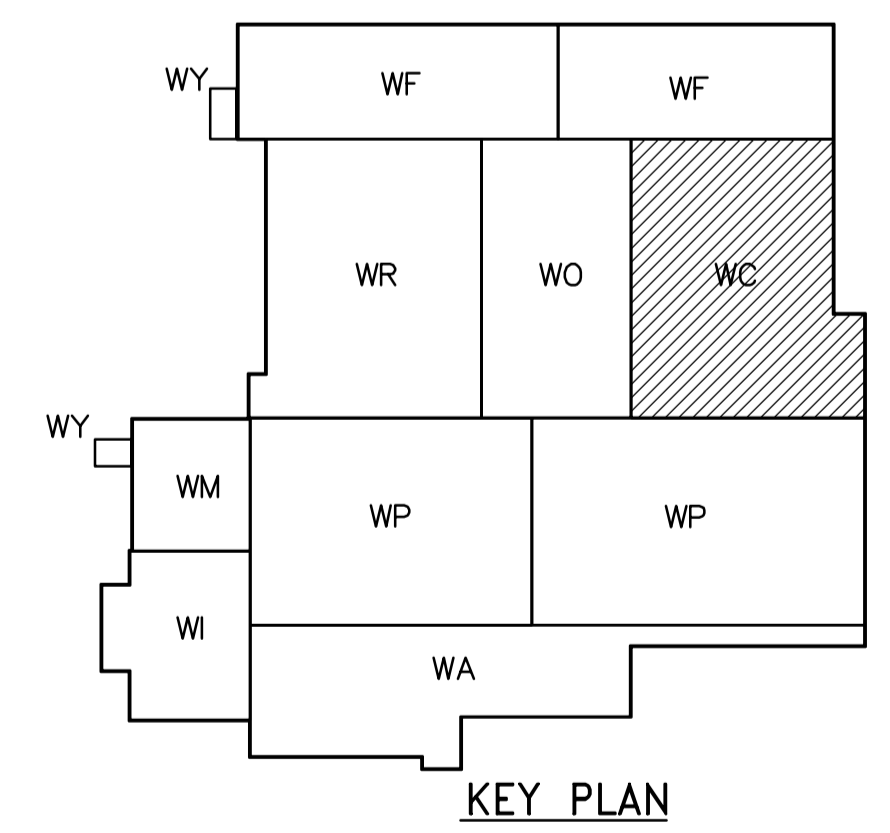

<p><b>APEGN</b> Certificate of Authorization CH2M HILL Canada Ltd. No. 1441 Expiry: April 30, 2006</p>	<p>Frederickson Cooper ARCHITECTS</p>		<p>A Geo International Ltd. Company</p>		ENGINEER'S SEAL  ORIGINAL SIGNED BY D. KRUGER 2006/04/21	<p><b>THE CITY OF WINNIPEG</b> WATER AND WASTE DEPARTMENT ENGINEERING DIVISION</p>	WATER TREATMENT PLANT CHEMICAL FEED SYSTEMS MECHANICAL AND ELECTRICAL	CITY FILE NUMBER SHEET OF
	DESIGNED BY EL CHECKED BY AP DRAWN BY CA APPROVED BY AHL SCALE: 1:100 RELEASED FOR CONSTRUCTION BY: R. SOROKOWSKI	CONSULTANT DRAWING NO. WC-S7146	STRUCTURAL CHEMICAL AREA ROOF PLAN	CITY DRAWING NUMBER 1-0601C-A-S7146-001-000				
B.M. ELEV.	NO. REVISIONS	DATE	BY	DATE	DATE	00 742-2005 ADDENDUM 1 06/04/21 EL 2006/04/11 2006/04/21		