
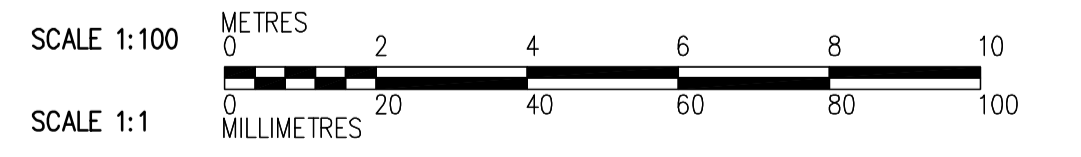


- NOTES:**
1. FIELD VERIFY DIMENSIONS PRIOR TO FABRICATION.
  2. SPLICE BRIDGE CRANE RUNWAY BEAM AT SUPPORT LOCATION ONLY, SEE DETAIL 3 WP-S7402

**ROOF PLAN**  
1:100

54785

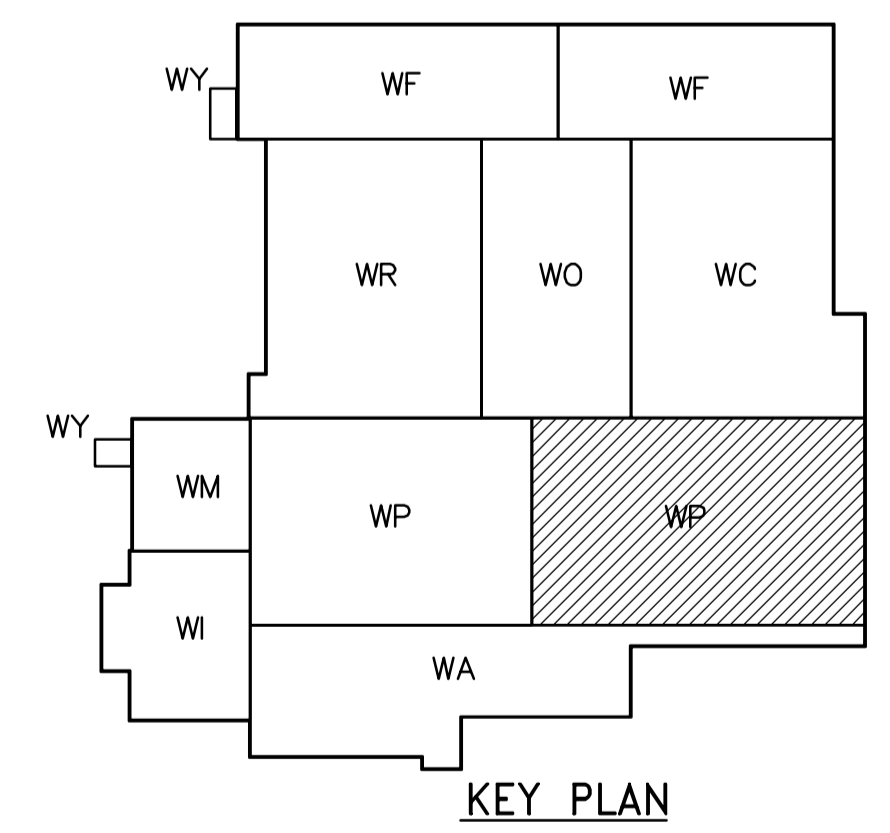

B.M. ELEV.	DESIGNED BY	CHECKED BY	ENGINEER'S SEAL
	EL	AP	ORIGINAL SIGNED BY <b>D. KRUGER</b> 2006/04/21 CONSULTANT DRAWING NO. WP-S7142
	CA	AHL	
	SCALE: 1:100	RELEASED FOR CONSTRUCTION BY: R. SOROKOWSKI	
	DATE: 2005/12/13	DATE: 2006/04/21	
NO. REVISIONS	DATE	BY	
00	742-2005 ADDENDUM 1	06/04/21	EL

WATER TREATMENT PLANT FLOCCULATION AND DAF MECHANICAL AND ELECTRICAL		CITY FILE NUMBER
STRUCTURAL FLOC/DAF AREA 2 ROOF PLAN		SHEET OF
		CITY DRAWING NUMBER 1-0601P-A-S7142-001-000