

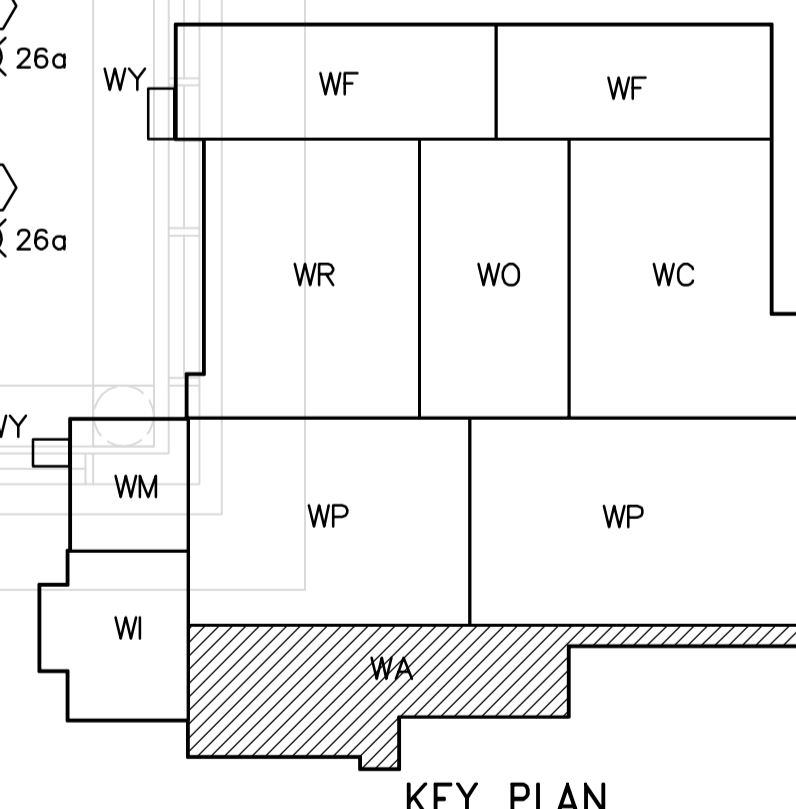


NOTES
1. ALL 120V AND 208V LOADS ARE FED FROM LP-A21

ADMINISTRATION AREA

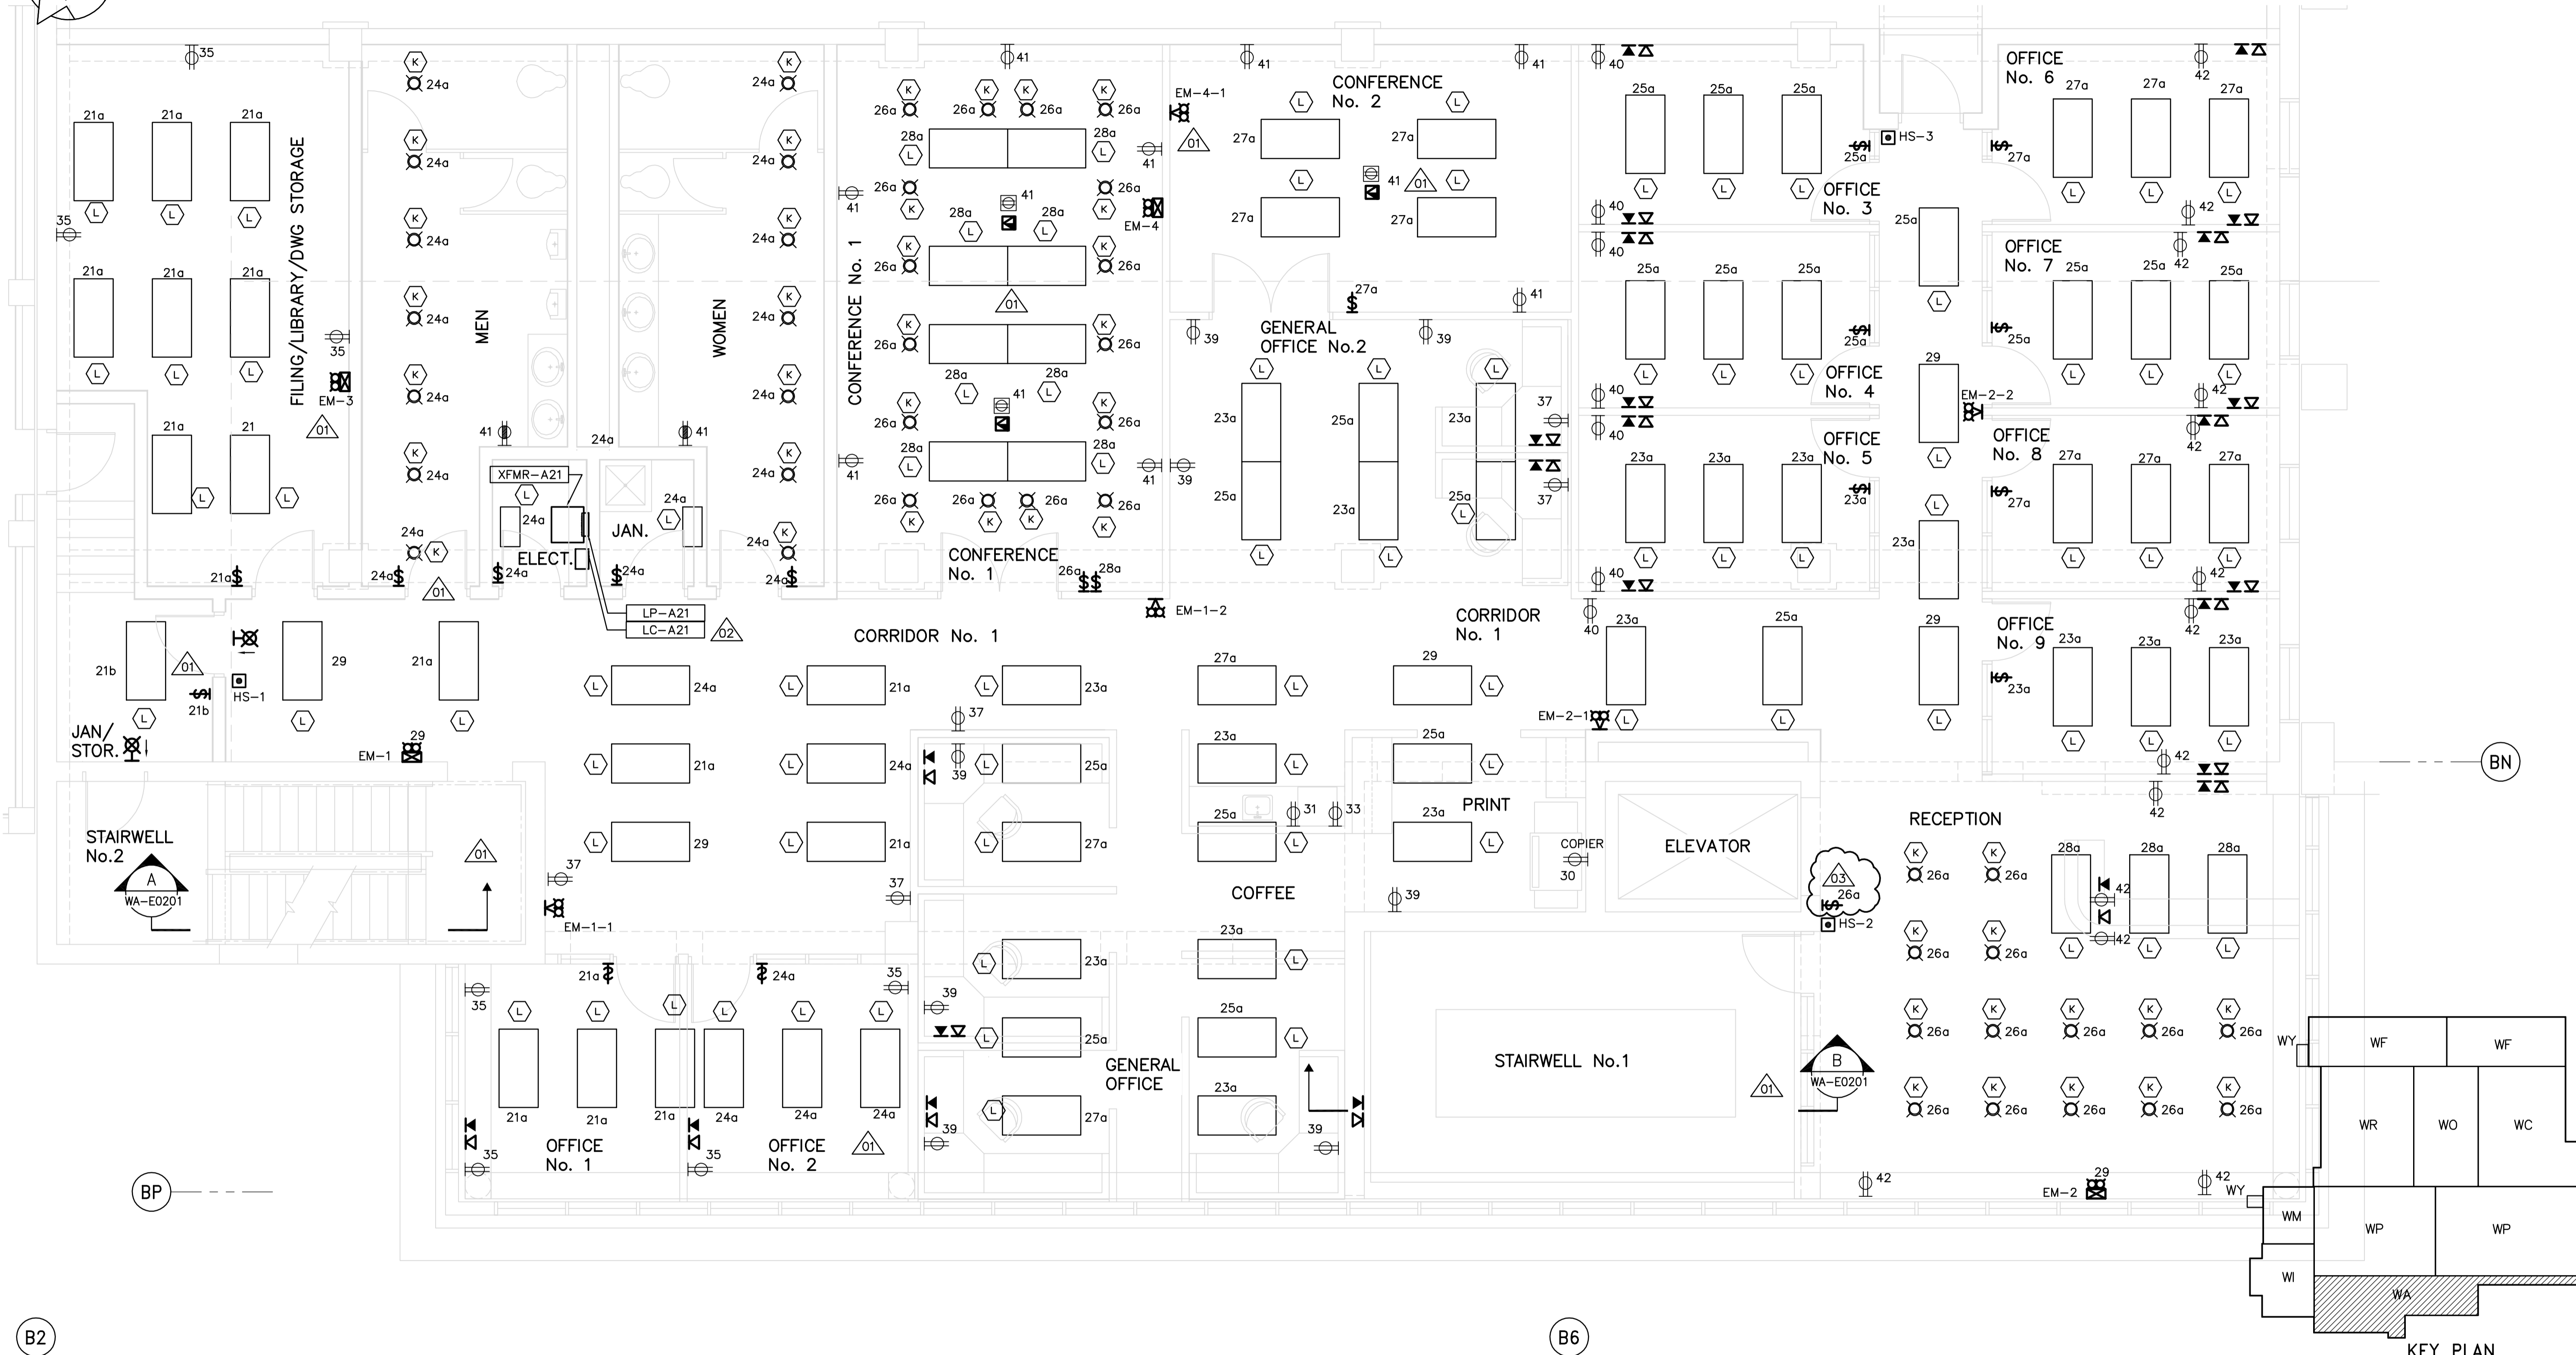

1 SECOND FLOOR POWER AND LIGHTING PLAN
WA-E0113 1:50

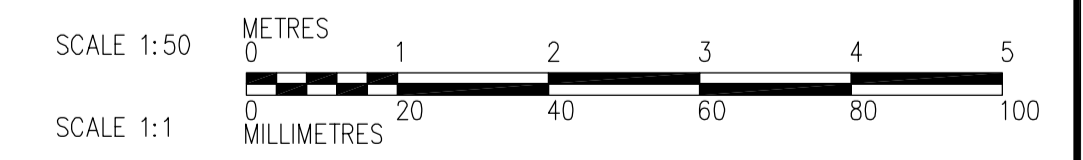

 APEGN Certificate of Authorization CH2M HILL Canada Ltd. No. 1441 Expiry: April 30, 2007	B.M. ELEV.	 Frederickson Cooper ARCHITECTS	 A Terra International Ltd. Company	ENGINEER'S SEAL ORIGINAL SIGNED BY L.D. LLEWELLYN 2006/03/29	 THE CITY OF WINNIPEG WATER AND WASTE DEPARTMENT ENGINEERING DIVISION WATER TREATMENT PLANT ADMINISTRATION AREA MECHANICAL AND ELECTRICAL ELECTRICAL ADMINISTRATION AREA SECOND FLOOR POWER AND LIGHTING PLAN	CITY FILE NUMBER																			
	<table border="1"> <tr> <th>NO.</th> <th>REVISIONS</th> <th>DATE</th> <th>BY</th> </tr> <tr> <td>03</td> <td>742-2005 ADDENDUM 12</td> <td>06/06/23</td> <td>PF</td> </tr> <tr> <td>02</td> <td>742-2005 ADDENDUM 4</td> <td>06/05/12</td> <td>LL</td> </tr> <tr> <td>01</td> <td>742-2005 ADDENDUM 3</td> <td>06/05/05</td> <td>LL</td> </tr> <tr> <td>00</td> <td>ISSUED FOR TENDER</td> <td>06/03/29</td> <td>LL</td> </tr> </table>	NO.	REVISIONS	DATE		BY	03	742-2005 ADDENDUM 12	06/06/23	PF	02	742-2005 ADDENDUM 4	06/05/12	LL	01	742-2005 ADDENDUM 3	06/05/05	LL	00	ISSUED FOR TENDER	06/03/29	LL	DESIGNED BY PF CHECKED BY ND DRAWN BY TL APPROVED BY AHL SCALE: 1:50 RELEASED FOR CONSTRUCTION BY: R. SOROKOWSKI DATE 2006/02/07 DATE 2006/03/29	CONSULTANT DRAWING NO. WA-E0401	SHEET OF
	NO.	REVISIONS	DATE	BY																					
	03	742-2005 ADDENDUM 12	06/06/23	PF																					
02	742-2005 ADDENDUM 4	06/05/12	LL																						
01	742-2005 ADDENDUM 3	06/05/05	LL																						
00	ISSUED FOR TENDER	06/03/29	LL																						
WA-E0113 1:50	WA-E0401	CITY DRAWING NUMBER 1-0601A-A-E0401-001-03D																							
Last Save: 2006-06-26 4:21 PM	C:\DOCUMENTS AND SETTINGS\SEVERITT\MY DOCUMENTS\NDMPROJ\321352 - WINNIPEG\WP\DN_WA-E0401_CH2M.DWG																								