



- NOTES:**
- SEE MCC 4A & 4B SINGLE LINE DIAGRAMS AND PANEL SCHEDULES DP-H31 AND DP-H32 FOR 600V POWER DISTRIBUTION.
 - SEE DRAWINGS WB-E0402 AND WB-E0403 FOR FLOCCULATION TANK EQUIPMENT WIRING DETAILS.
 - SEE CABLE CLOCK DIAGRAMS CBD-P-31 THROUGH CBD-P-39 FOR DAF EQUIPMENT AND INSTRUMENT INTERCONNECTION WIRING REQUIREMENTS.

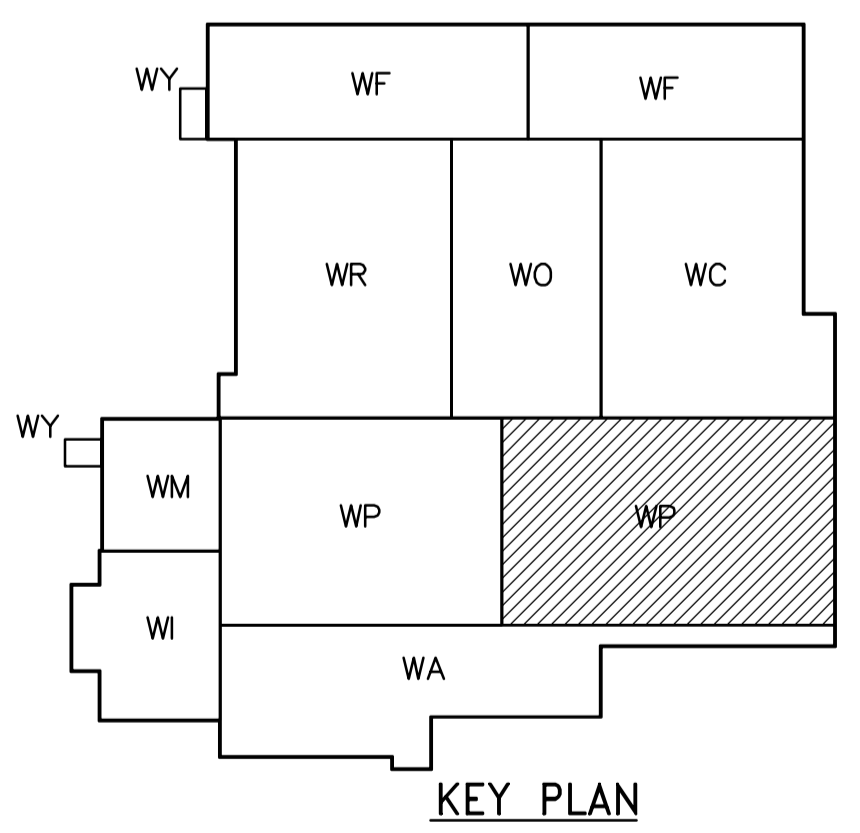

THIRD FLOOR PROCESS PLAN (AREA 2)
1:100

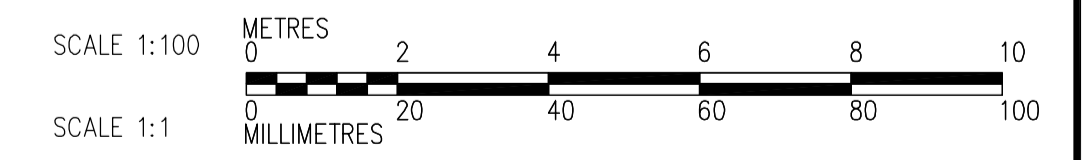

<p>APEGN Certificate of Authorization CH2M HILL Canada Ltd. No. 1441 Expiry: April 30, 2007</p>	<p>Frederickson Cooper ARCHITECTS</p>		<p>EarthTech A Tyco International Ltd. Company</p>		ENGINEER'S SEAL ORIGINAL SIGNED BY L.D. LLEWELLYN 2006/03/29	<p>THE CITY OF WINNIPEG WATER AND WASTE DEPARTMENT ENGINEERING DIVISION</p>
	DESIGNED BY: LL CHECKED BY: ND		APPROVED BY: AHL		CONSULTANT DRAWING NO. WP-E0134	
	DRAWN BY: TL SCALE: 1:100		RELEASED FOR CONSTRUCTION BY: R. SOROKOWSKI			
	NO. REVISIONS: 03 DATE: 06/06/23 BY: PF		DATE: 2005/07/12		WATER TREATMENT PLANT FLOCCULATION AND DAF MECHANICAL AND ELECTRICAL	
NO. REVISIONS: 02 DATE: 06/05/12 BY: LL		NO. REVISIONS: 01 DATE: 06/05/05 BY: LL		ELECTRICAL FLOC/DAF AREA 2 THIRD FLOOR PROCESS PLAN	CITY DRAWING NUMBER 1-0601P-A-E0134-001-03D	
NO. REVISIONS: 00 DATE: 06/03/29 BY: LL		DATE: 2005/07/12		CITY DRAWING NUMBER 1-0601P-A-E0134-001-03D		