
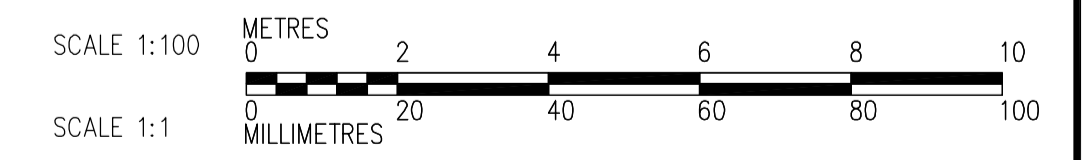


NOTES:
1. SEE PANEL SCHEDULES DP-R21 & DP-R22 FOR 600V POWER DISTRIBUTION

SECOND FLOOR PROCESS PLAN
1:100

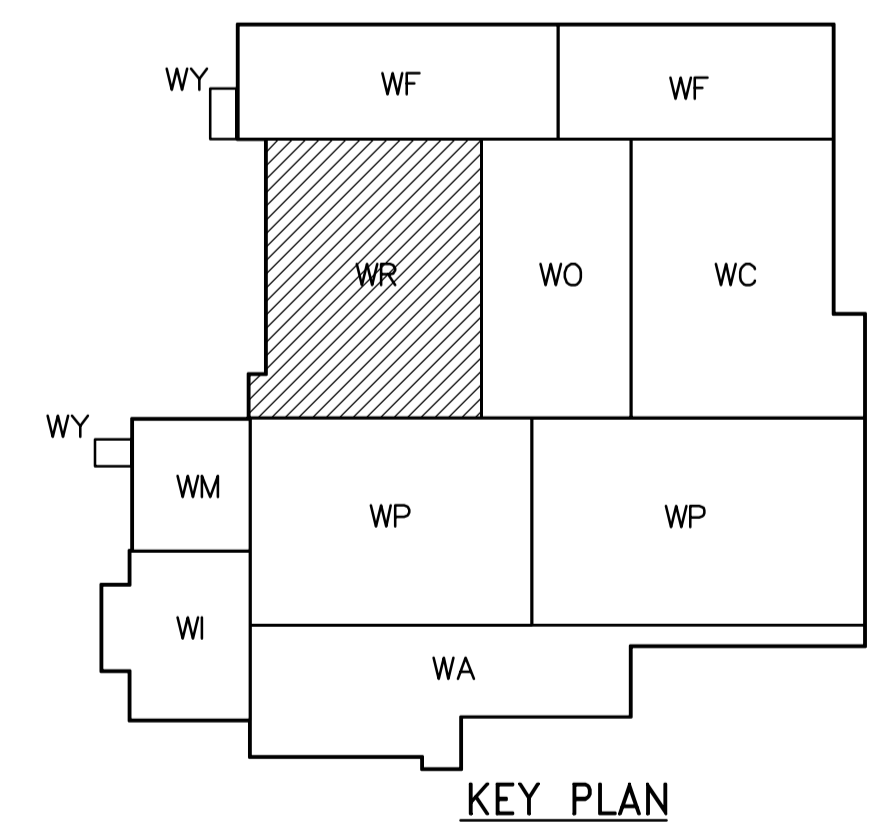

<p>APEGN Certificate of Authorization CH2M HILL Canada Ltd. No. 1441 Expiry: April 30, 2007</p>	<p>B.M. ELEV.</p> <table border="1"> <tr><td> </td><td> </td><td> </td><td> </td></tr> <tr><td> </td><td> </td><td> </td><td> </td></tr> <tr><td> </td><td> </td><td> </td><td> </td></tr> <tr><td> </td><td> </td><td> </td><td> </td></tr> </table>																	<p>Frederickson Cooper ARCHITECTS</p>	<p>EarthTech A Tyco International Ltd. Company</p>	<p>ENGINEER'S SEAL</p> <p>ORIGINAL SIGNED BY L.D. LLEWELLYN 2006/03/29</p> <p>CONSULTANT DRAWING NO. WR-E0122</p>	<p>THE CITY OF WINNIPEG WATER AND WASTE DEPARTMENT ENGINEERING DIVISION</p> <p>WATER TREATMENT PLANT RESIDUALS HANDLING MECHANICAL AND ELECTRICAL</p> <p>ELECTRICAL RESIDUALS HANDLING AREA SECOND FLOOR PROCESS PLAN</p>	<p>CITY FILE NUMBER</p> <p>SHEET OF</p> <p>CITY DRAWING NUMBER 1-0601R-A-E0122-001-03D</p>																	
<table border="1"> <thead> <tr> <th>NO.</th> <th>REVISIONS</th> <th>DATE</th> <th>BY</th> </tr> </thead> <tbody> <tr> <td>03</td> <td>742-2005 ADDENDUM 12</td> <td>06/06/23</td> <td>PF</td> </tr> <tr> <td>02</td> <td>742-2005 ADDENDUM 5</td> <td>06/05/19</td> <td>LL</td> </tr> <tr> <td>01</td> <td>742-2005 ADDENDUM 3</td> <td>06/05/05</td> <td>LL</td> </tr> <tr> <td>00</td> <td>ISSUED FOR TENDER</td> <td>06/03/29</td> <td>LL</td> </tr> </tbody> </table>	NO.	REVISIONS	DATE	BY	03	742-2005 ADDENDUM 12	06/06/23	PF	02	742-2005 ADDENDUM 5	06/05/19	LL	01	742-2005 ADDENDUM 3	06/05/05	LL	00	ISSUED FOR TENDER	06/03/29	LL	<table border="1"> <thead> <tr> <th>DESIGNED BY</th> <th>CHECKED BY</th> </tr> </thead> <tbody> <tr> <td>LL</td> <td>ND</td> </tr> </tbody> </table> <table border="1"> <thead> <tr> <th>DRAWN BY</th> <th>APPROVED BY</th> </tr> </thead> <tbody> <tr> <td>TL</td> <td>AHL</td> </tr> </tbody> </table> <p>SCALE: 1:100</p> <table border="1"> <thead> <tr> <th>RELEASED FOR CONSTRUCTION BY:</th> <th>DATE</th> </tr> </thead> <tbody> <tr> <td>R. SOROKOWSKI</td> <td>2006/03/29</td> </tr> </tbody> </table>	DESIGNED BY	CHECKED BY	LL	ND	DRAWN BY	APPROVED BY	TL	AHL	RELEASED FOR CONSTRUCTION BY:	DATE	R. SOROKOWSKI	2006/03/29	<table border="1"> <thead> <tr> <th>DATE</th> <th>BY</th> </tr> </thead> <tbody> <tr> <td>2006/01/21</td> <td>LL</td> </tr> </tbody> </table>	DATE	BY	2006/01/21	LL	<p>DATE 2006/01/21</p> <p>DATE 2006/03/29</p>
NO.	REVISIONS	DATE	BY																																				
03	742-2005 ADDENDUM 12	06/06/23	PF																																				
02	742-2005 ADDENDUM 5	06/05/19	LL																																				
01	742-2005 ADDENDUM 3	06/05/05	LL																																				
00	ISSUED FOR TENDER	06/03/29	LL																																				
DESIGNED BY	CHECKED BY																																						
LL	ND																																						
DRAWN BY	APPROVED BY																																						
TL	AHL																																						
RELEASED FOR CONSTRUCTION BY:	DATE																																						
R. SOROKOWSKI	2006/03/29																																						
DATE	BY																																						
2006/01/21	LL																																						