
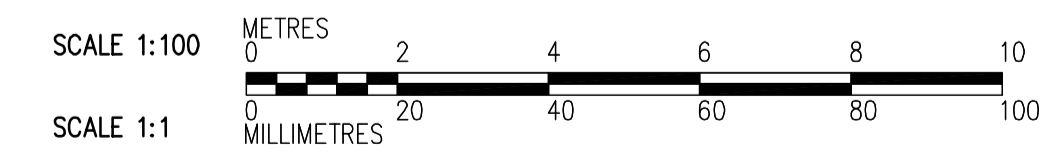


- NOTES:**
1. SEE MCC #1A, #1B SINGLE LINE DIAGRAM AND DP-A11 & DP-A12 POWER DISTRIBUTION FOR 600V POWER REQUIREMENT.
 2. ALL 120V AND 208V LOADS ARE FED FROM LP-A11
 3. PROVIDE STAIRWELL SMOKE DETECTORS AS SHOWN ON FIRE PROTECTION DRAWINGS.

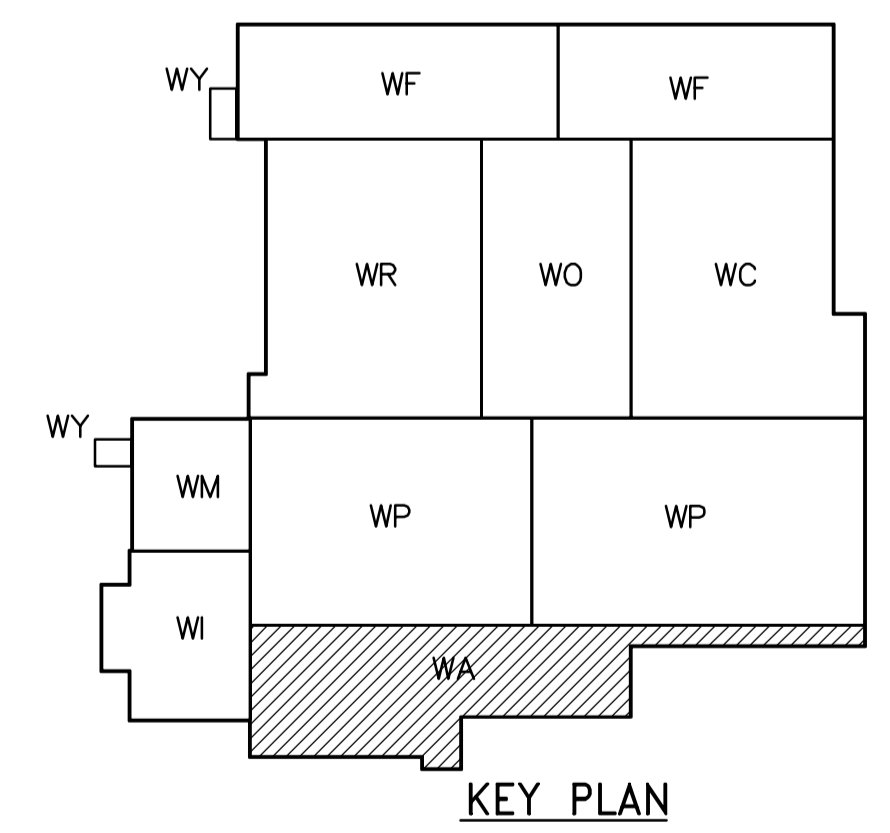

FIRST FLOOR FACILITY PLAN
1:100

CABLE TRAY TAGGING
SEE DETAIL
3
WB-E0455

<p>APEGN Certificate of Authorization CH2M HILL Canada Ltd. No. 1441 Expiry: April 30, 2007</p>	B.M. ELEV.	<p>Frederickson Cooper ARCHITECTS</p>	<p>EarthTech A Tyco International Ltd. Company</p>	ENGINEER'S SEAL	<p>THE CITY OF WINNIPEG WATER AND WASTE DEPARTMENT ENGINEERING DIVISION</p>		
				DESIGNED BY JT		CHECKED BY ND	ORIGINAL SIGNED BY L.D. LLEWELLYN
				DRAWN BY KJ		APPROVED BY AHL	2006/03/29
				SCALE: 1:100		RELEASED FOR CONSTRUCTION BY: R. SOROKOWSKI	CONSULTANT DRAWING NO. WA-E0111
	01 742-2005 ADDENDUM 3 06/05/05 LL				CITY FILE NUMBER		
	00 ISSUED FOR TENDER 06/03/29 LL				SHEET OF		
	NO. REVISIONS	DATE BY	DATE 2005/08/18	DATE 2006/03/29	CITY DRAWING NUMBER		
					1-0601A-A-E0111-001-01D		

WATER TREATMENT PLANT
ADMINISTRATION
MECHANICAL AND ELECTRICAL

ELECTRICAL
ADMINISTRATION AREA
FIRST FLOOR FACILITY PLAN