


- NOTES:**
1. ALL 120V AND 208V LOADS ARE FED FROM LP-A31.
  2. MOUNT TYPE A LUMINAIRES AT 2.4m ABOVE FINISHED FLOOR.

**MECHANICAL ROOM #4**  
**POWER AND LIGHTING PLAN**  
 1:100

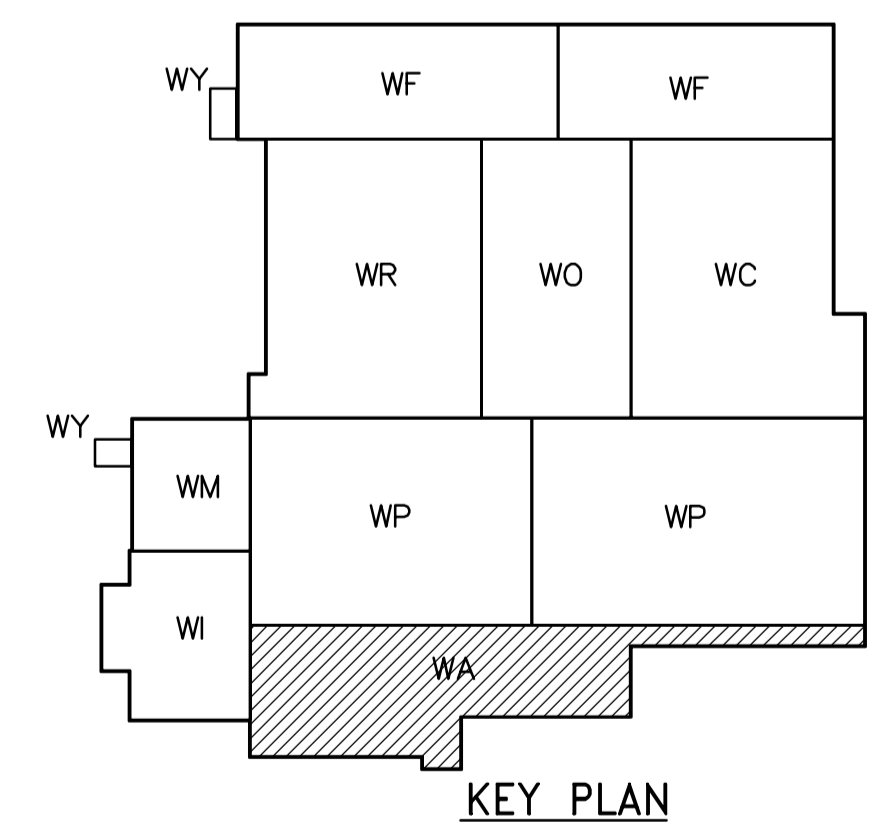

 Certificate of Authorization CH2M HILL Canada Ltd. No. 1441 Expiry: April 30, 2007	B.M. ELEV. <table border="1"> <tr><td> </td><td> </td><td> </td></tr> <tr><td> </td><td> </td><td> </td></tr> <tr><td> </td><td> </td><td> </td></tr> <tr><td> </td><td> </td><td> </td></tr> <tr><td> </td><td> </td><td> </td></tr> <tr><td> </td><td> </td><td> </td></tr> <tr><td> </td><td> </td><td> </td></tr> <tr><td> </td><td> </td><td> </td></tr> <tr><td> </td><td> </td><td> </td></tr> <tr><td> </td><td> </td><td> </td></tr> </table>																															 Frederickson Cooper ARCHITECTS	 A Terra International Ltd. Company	ENGINEER'S SEAL	 <b>THE CITY OF WINNIPEG</b> WATER AND WASTE DEPARTMENT ENGINEERING DIVISION
DESIGNED BY: LL CHECKED BY: ND DRAWN BY: TL APPROVED BY: AHL SCALE: 1:100 RELEASED FOR CONSTRUCTION BY: R. SOROKOWSKI CONSULTANT DRAWING NO. WA-E0147	ORIGINAL SIGNED BY: L.D. LLEWELLYN 2006/03/29	WATER TREATMENT PLANT ADMINISTRATION AREA MECHANICAL AND ELECTRICAL	CITY FILE NUMBER SHEET OF																																
NO. REVISIONS      DATE      BY      DATE      2005/08/18      DATE      2006/03/29				ELECTRICAL ADMINISTRATION AREA ROOF POWER AND LIGHTING PLAN	CITY DRAWING NUMBER 1-0601A-A-E0147-001-01D																														