

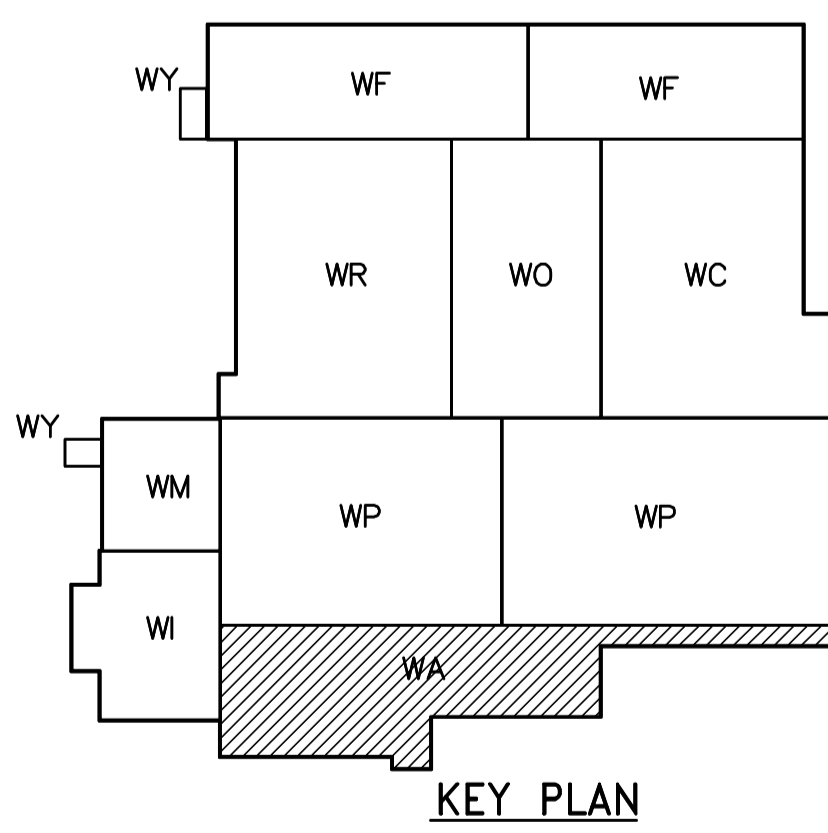


NOTES:
 1. ALL 120V AND 208V LOADS ARE FED FROM LP-A31.
 2. EMERGENCY LIGHTING EM-X-1 ARE FED FROM BATTERY PACK EM-X.

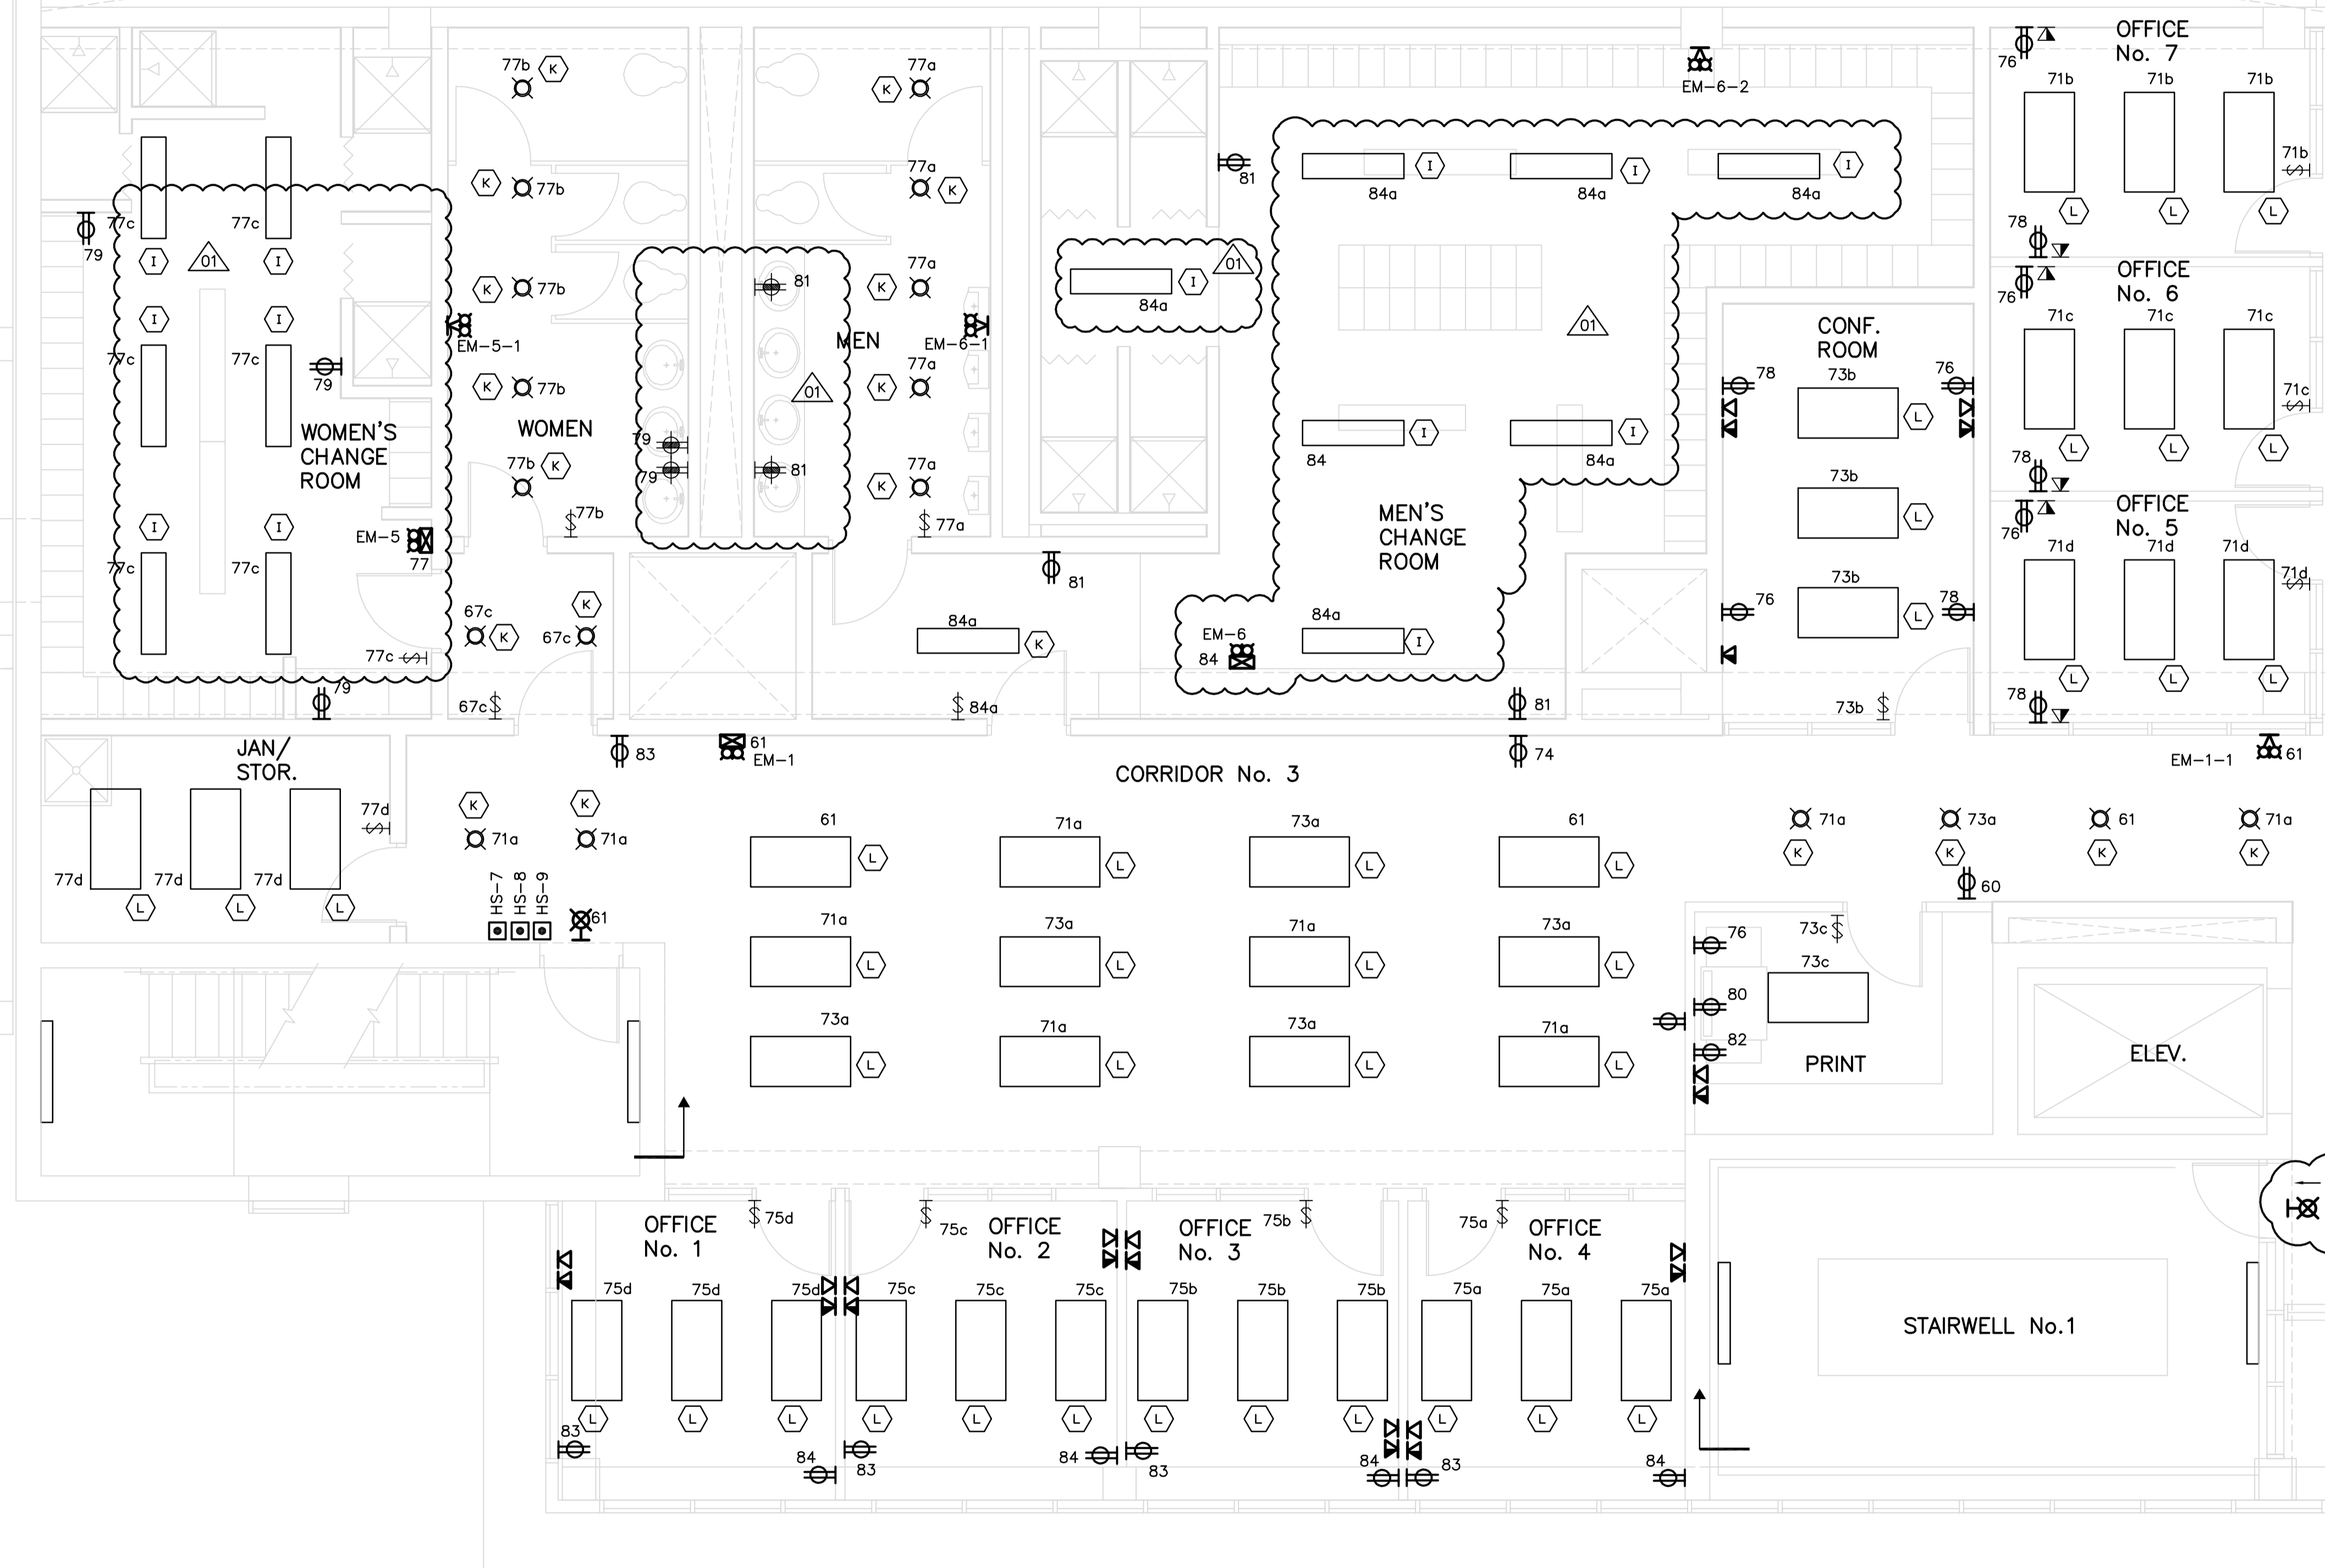

1 THIRD FLOOR POWER AND LIGHTING PLAN
 WA-E0133 N.T.S.

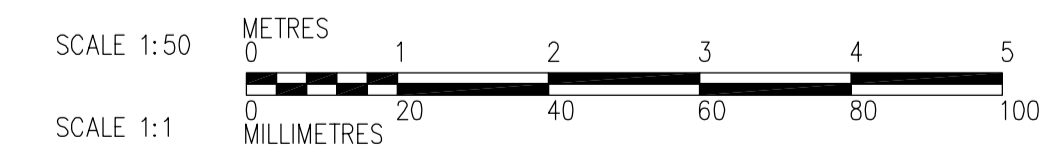

 Certificate of Authorization CH2M HILL Canada Ltd. No. 1441 Expiry: April 30, 2007	B.M. ELEV.	 Frederickson Cooper ARCHITECTS	 A Tyco International Ltd. Company	ENGINEER'S SEAL ORIGINAL SIGNED BY L.D. LLEWELLYN 2006/03/29	 THE CITY OF WINNIPEG WATER AND WASTE DEPARTMENT ENGINEERING DIVISION
	DESIGNED BY LL CHECKED BY ND DRAWN BY TL APPROVED BY AHL			CONSULTANT DRAWING NO. WA-E0402	
NO. REVISIONS 01 742-2005 ADDENDUM 3 06/05/05 LL 00 ISSUED FOR TENDER 06/03/29 LL	DATE BY 2006/03/10	RELEASED FOR CONSTRUCTION BY: R. SOROKOWSKI 2006/03/29	WATER TREATMENT PLANT ADMINISTRATION MECHANICAL AND ELECTRICAL	CITY FILE NUMBER SHEET OF	CITY DRAWING NUMBER 1-0601A-A-E0402-001-01D