
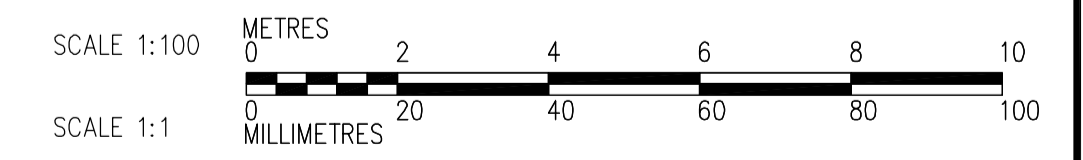


NOTES:
 1. SEE MCC #2A & #2B SINGLE LINE DIAGRAM AND DP-C11 & DP-C12 POWER DISTRIBUTION FOR 600V POWER DISTRIBUTION.
 2. ALL 120 AND 208V LOADS ARE FED FROM LP-C11

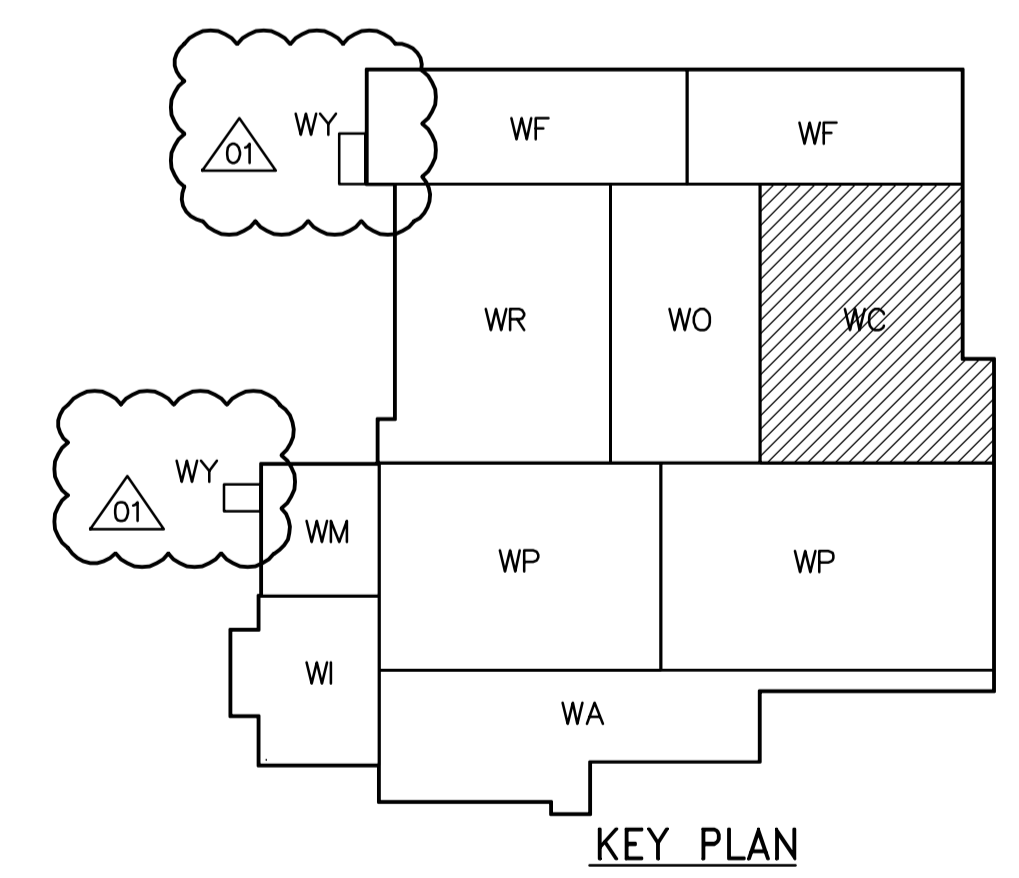

SECOND FLOOR PROCESS PLAN
1:100

 APEGN Certificate of Authorization CH2M HILL Canada Ltd. No. 1441 Expiry: April 30, 2007	B.M. ELEV.	 Frederickson Cooper ARCHITECTS	 A Terra International Ltd. Company	ENGINEER'S SEAL	 THE CITY OF WINNIPEG WATER AND WASTE DEPARTMENT ENGINEERING DIVISION	
	DESIGNED BY JT			CHECKED BY ND		ORIGINAL SIGNED BY L.D. LLEWELLYN
	DRAWN BY TL			APPROVED BY AHL		2006/03/29
	SCALE: 1:100			RELEASED FOR CONSTRUCTION BY: R. SOROKOWSKI		CONSULTANT DRAWING NO. WC-E0122
01 742-2005 ADDENDUM 3 06/05/05 LL 00 ISSUED FOR TENDER 06/03/29 LL NO. REVISIONS DATE BY DATE 2005/07/08 DATE 2006/03/29					WATER TREATMENT PLANT CHEMICAL FEED SYSTEMS MECHANICAL AND ELECTRICAL CITY FILE NUMBER SHEET OF ELECTRICAL CHEMICAL AREA SECOND FLOOR PROCESS PLAN CITY DRAWING NUMBER 1-0601C-A-E0122-001-01D	