


- NOTES:**
- SEE MCC #1A & #1B SINGLE LINE DIAGRAM AND DP-F01, DP-F02, DP-F03 AND DP-F04 POWER DISTRIBUTION FOR 600V POWER DISTRIBUTION.
 - ALL 120V AND 208V LOADS ARE FED FROM LP-F01
 - SEE DWG WB-E0404 FOR POWER FEEDS TO VALVES 01
 - SEE DWG WB-E0404 AND WB-E0405 FOR POWER WIRING TO BACKWASH PUMPS
 - SEE SWGR 1A & 1B SINGLE LINE DIAGRAM FOR 600V POWER DISTRIBUTION TO BACKWASH PUMPS

LOWER LEVEL PROCESS PLAN (AREA 1)
1:100

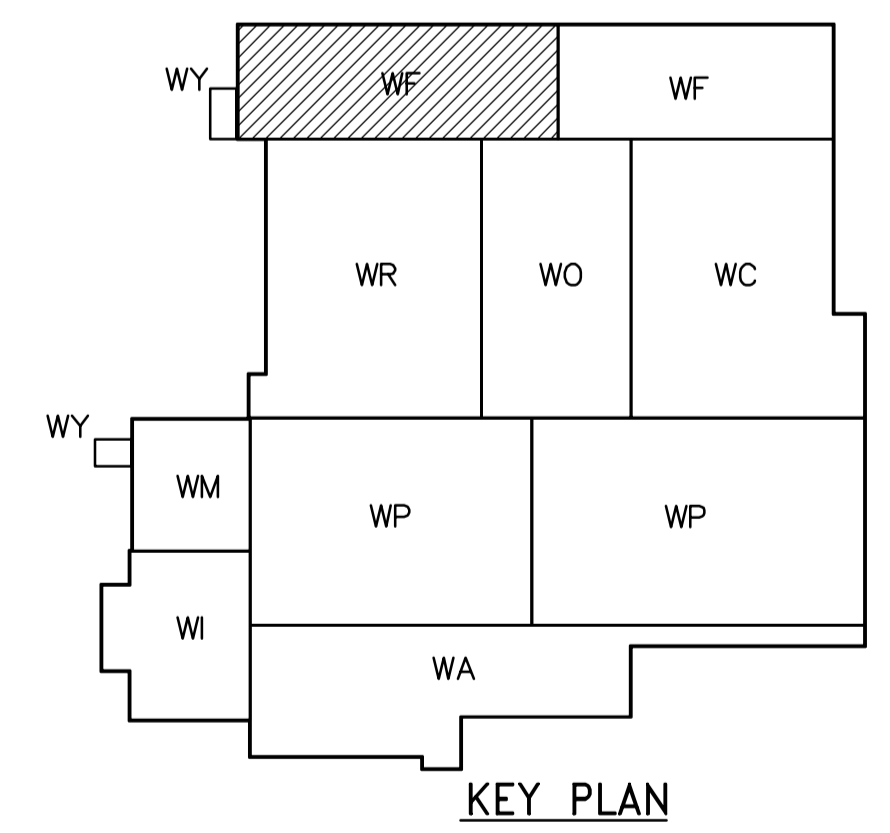

 APEGN Certificate of Authorization CH2M HILL Canada Ltd. No. 1441 Expiry: April 30, 2007	 Frederickson Cooper ARCHITECTS	 A You International Ltd. Company	ENGINEER'S SEAL ORIGINAL SIGNED BY L.D. LLEWELLYN 2006/03/29	 THE CITY OF WINNIPEG WATER AND WASTE DEPARTMENT ENGINEERING DIVISION	
	DESIGNED BY: JT CHECKED BY: ND DRAWN BY: KJ APPROVED BY: AHL	SCALE: 1:100 RELEASED FOR CONSTRUCTION BY: R. SOROKOWSKI	CONSULTANT DRAWING NO. WF-E0103	WATER TREATMENT PLANT FILTRATION MECHANICAL AND ELECTRICAL	CITY FILE NUMBER SHEET OF
	ELECTRICIAN FILTRATION AREA 1 LOWER LEVEL PROCESS PLAN			CITY DRAWING NUMBER 1-0601F-A-E0103-001-01D	
	NO. REVISIONS DATE BY DATE 2005/07/13 DATE 2006/03/29				