

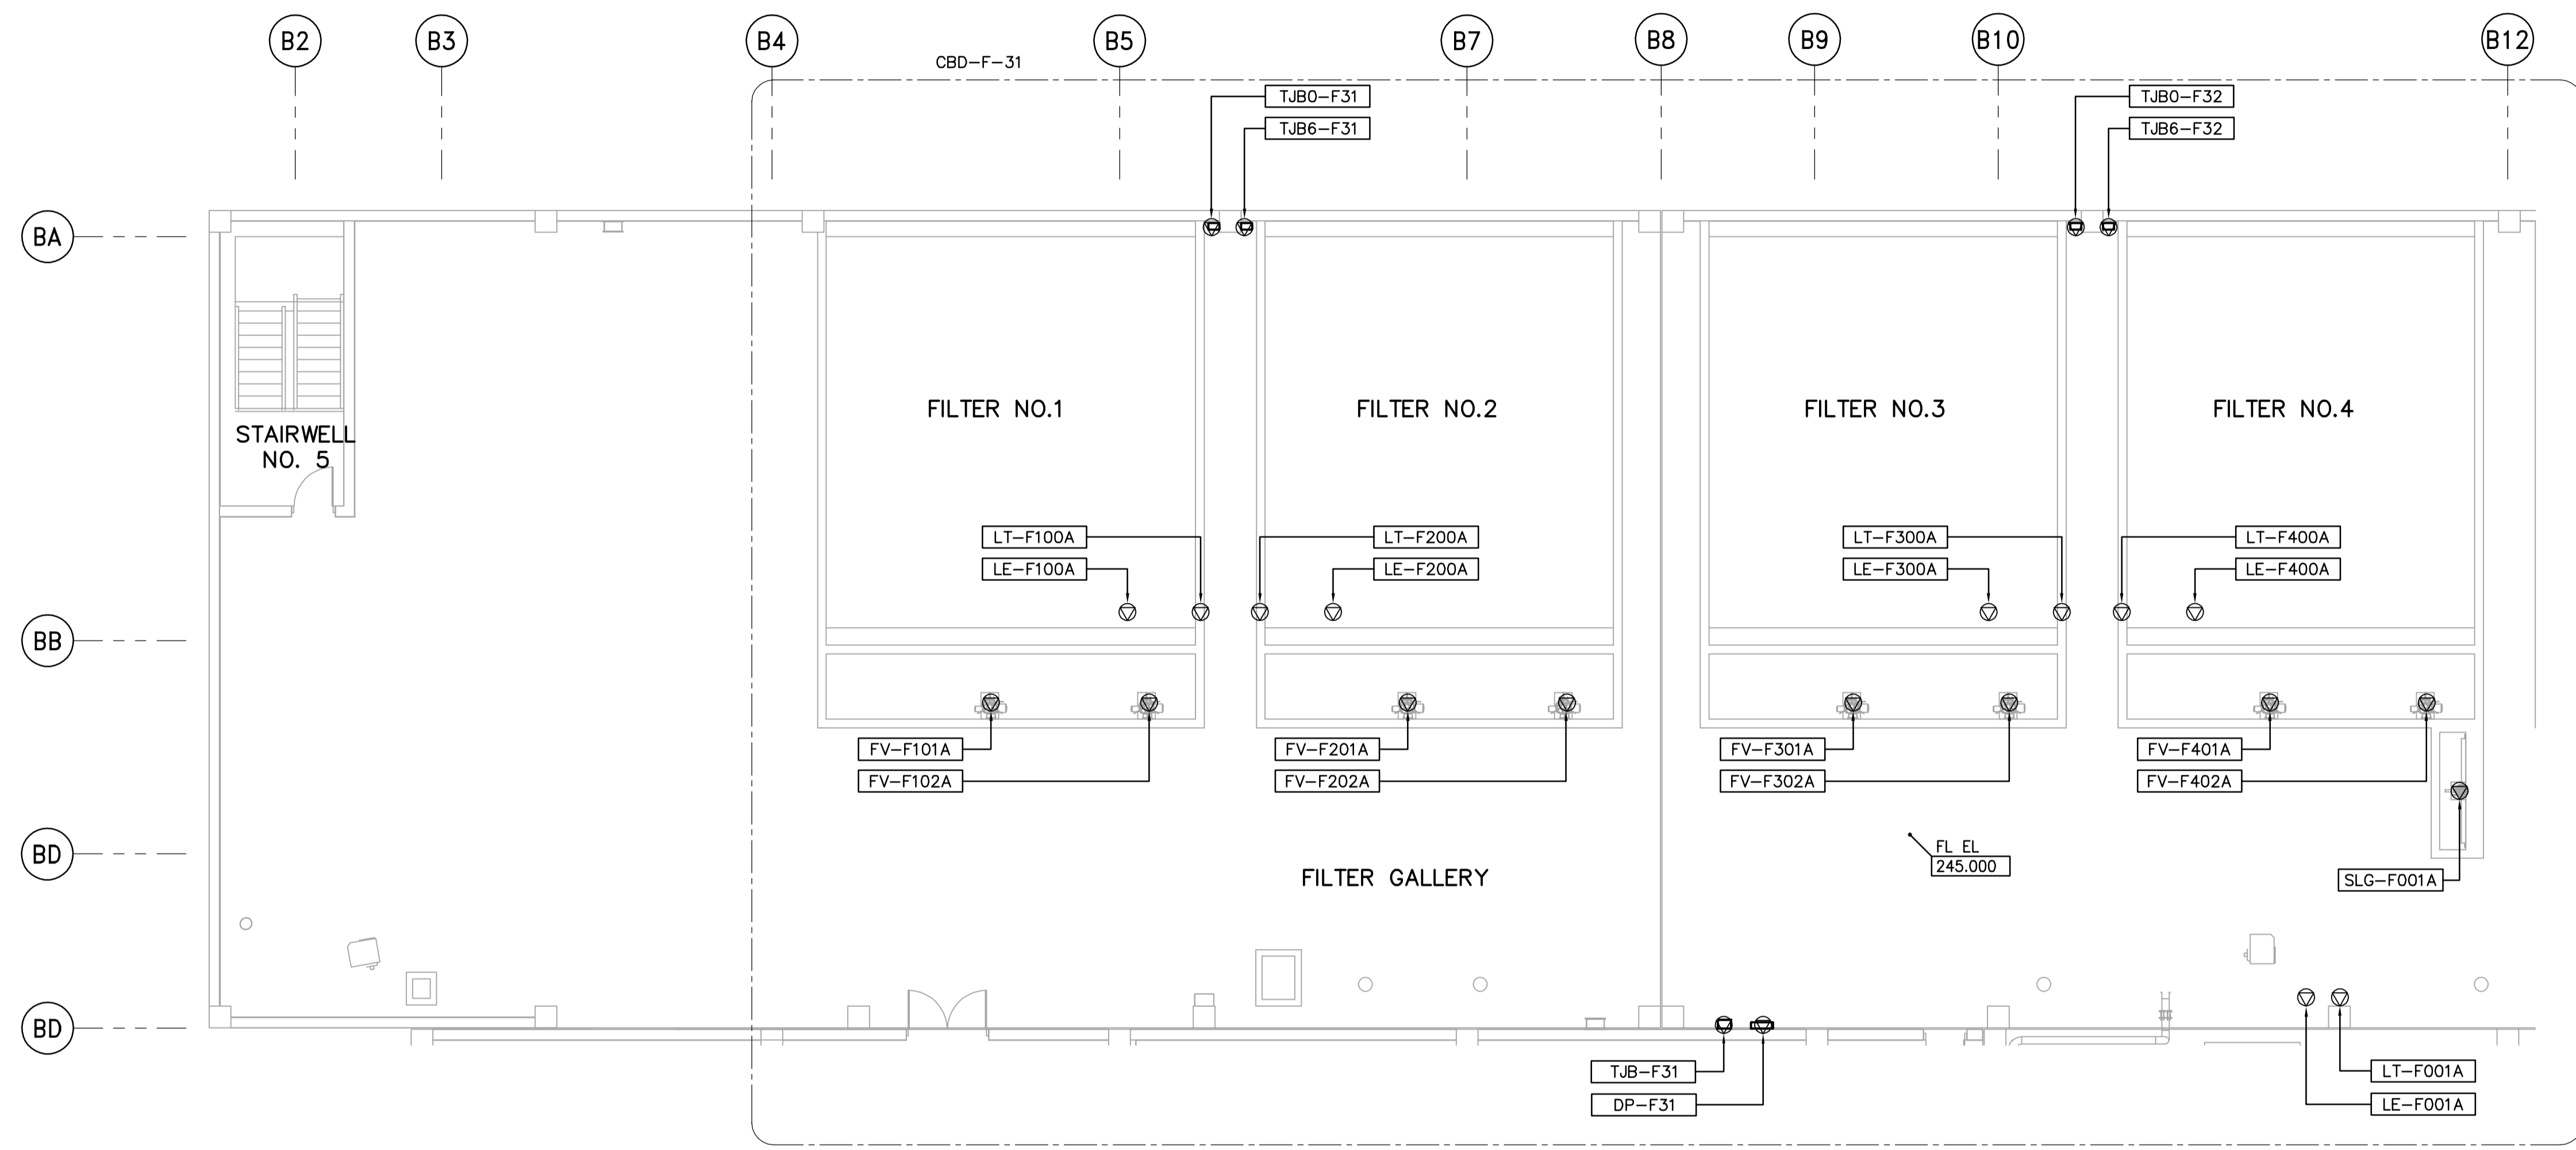


NOTES:

- SEE DISTRIBUTION PANEL SCHEDULE DP-F31 FOR 600V POWER DISTRIBUTION
- SEE DWG WB-E0403 FOR FILTER WIRING DETAILS

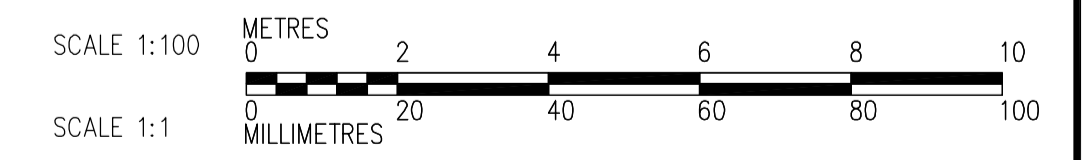

THIRD FLOOR PROCESS PLAN (AREA 1)
1:100

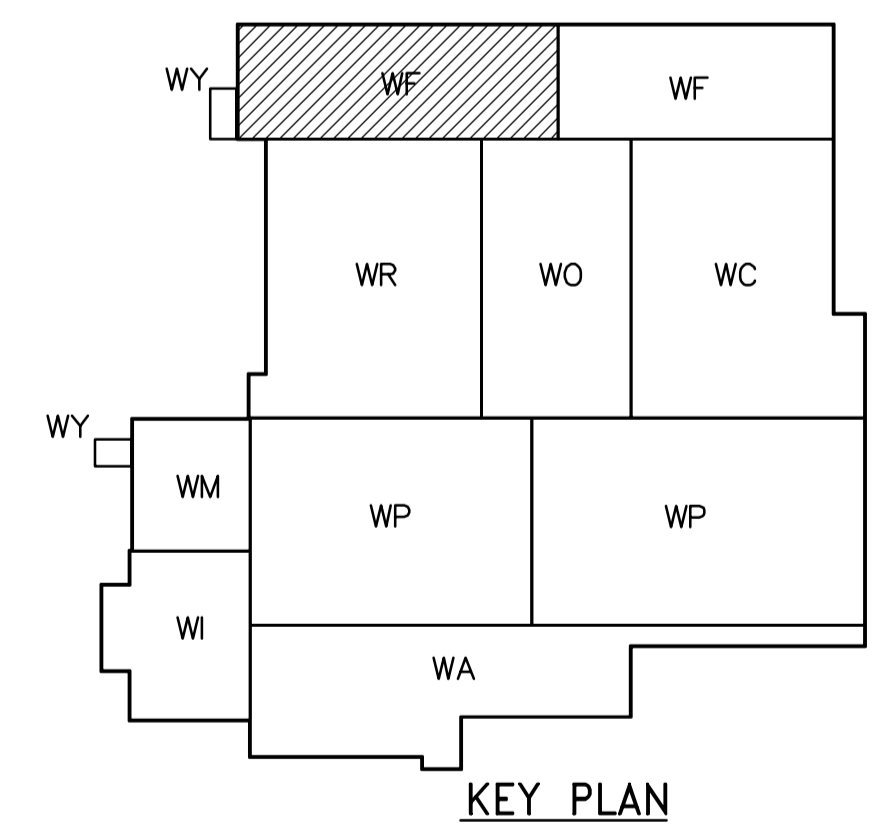

<p>APEGN Certificate of Authorization CH2M HILL Canada Ltd. No. 1441 Expiry: April 30, 2007</p>	<p>Frederickson Cooper ARCHITECTS</p>	<p>EarthTech A Tyco International Ltd. Company</p>	ENGINEER'S SEAL	<p>THE CITY OF WINNIPEG WATER AND WASTE DEPARTMENT ENGINEERING DIVISION</p>																														
			DESIGNED BY: LL		CHECKED BY: ND	ORIGINAL SIGNED BY: L.D. LLEWELLYN																												
			DRAWN BY: PS		APPROVED BY: AHL	2006/03/29																												
			SCALE: 1:100		RELEASED FOR CONSTRUCTION BY: R. SOROKOWSKI	CONSULTANT DRAWING NO. WF-E0133																												
<table border="1"> <thead> <tr> <th>NO.</th> <th>REVISIONS</th> <th>DATE</th> <th>BY</th> <th>DATE</th> <th>BY</th> </tr> </thead> <tbody> <tr> <td>01</td> <td>742-2005 ADDENDUM 3</td> <td>06/06/05</td> <td>LL</td> <td></td> <td></td> </tr> <tr> <td>00</td> <td>ISSUED FOR TENDER</td> <td>06/03/29</td> <td>LL</td> <td></td> <td></td> </tr> </tbody> </table>			NO.	REVISIONS	DATE	BY	DATE	BY	01	742-2005 ADDENDUM 3	06/06/05	LL			00	ISSUED FOR TENDER	06/03/29	LL			<table border="1"> <thead> <tr> <th>B.M.</th> <th>ELEV.</th> </tr> </thead> <tbody> <tr><td> </td><td> </td></tr> <tr><td> </td><td> </td></tr> <tr><td> </td><td> </td></tr> <tr><td> </td><td> </td></tr> <tr><td> </td><td> </td></tr> </tbody> </table>		B.M.	ELEV.										
NO.	REVISIONS	DATE	BY	DATE	BY																													
01	742-2005 ADDENDUM 3	06/06/05	LL																															
00	ISSUED FOR TENDER	06/03/29	LL																															
B.M.	ELEV.																																	
<p>WATER TREATMENT PLANT FILTRATION MECHANICAL AND ELECTRICAL</p>			<p>ELECTRICAL FILTRATION AREA 1 THIRD FLOOR PROCESS PLAN</p>																															
<p>CITY FILE NUMBER</p>			<p>SHEET OF</p>																															
<p>CITY DRAWING NUMBER</p>			<p>1-0601F-A-E0133-001-01D</p>																															