


THIRD FLOOR POWER AND LIGHTING PLAN (AREA 2)  
1:100

- NOTES:
1. ALL 120V AND 208V LOADS ARE FED FROM LP-H31
  2. EMERGENCY LIGHTING EM-X-1 ARE FED FROM BATTERY PACK EM-X.
  3. MOUNT TYPE A LUMINAIRE AT 3.0m ABOVE THE FLOOR
  4. SEE DWG WB-E0401 FOR TYPE A FIXTURE MOUNTING DETAILS
  5. SEE DWG WB-E402 DET 2 FOR TYPE J FIXTURE MOUNTING DETAILS

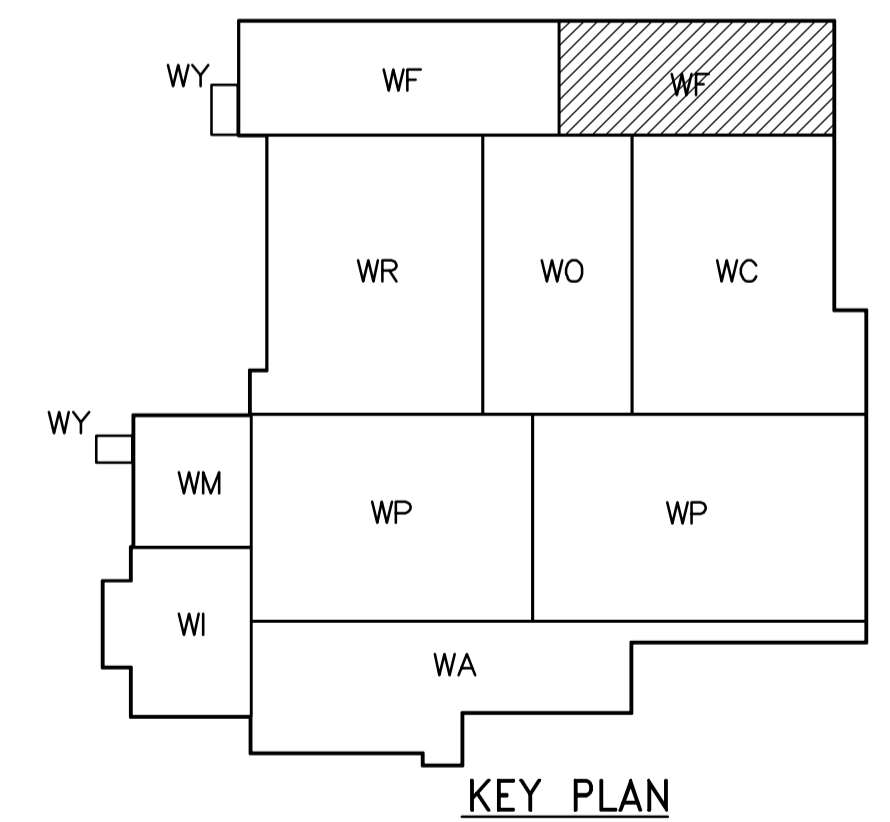

<p><b>APEGN</b> Certificate of Authorization CH2M HILL Canada Ltd. No. 1441 Expiry: April 30, 2007</p>	<p>Frederickson Cooper ARCHITECTS</p>	<p>EarthTech A Tetra International Ltd. Company</p>	ENGINEER'S SEAL	<p><b>THE CITY OF WINNIPEG</b> WATER AND WASTE DEPARTMENT ENGINEERING DIVISION</p>																														
			DESIGNED BY LL		CHECKED BY ND	ORIGINAL SIGNED BY L.D. LLEWELLYN																												
			DRAWN BY TL		APPROVED BY AHL	2006/03/29																												
			SCALE: 1:100		RELEASED FOR CONSTRUCTION BY: R. SOROKOWSKI	CONSULTANT DRAWING NO. WF-E0136																												
<table border="1"> <thead> <tr> <th>NO.</th> <th>REVISIONS</th> <th>DATE</th> <th>BY</th> <th>DATE</th> <th>DATE</th> </tr> </thead> <tbody> <tr> <td>01</td> <td>742-2005 ADDENDUM 3</td> <td>06/05/05</td> <td>LL</td> <td></td> <td></td> </tr> <tr> <td>00</td> <td>ISSUED FOR TENDER</td> <td>06/03/29</td> <td>LL</td> <td></td> <td></td> </tr> </tbody> </table>			NO.	REVISIONS	DATE	BY	DATE	DATE	01	742-2005 ADDENDUM 3	06/05/05	LL			00	ISSUED FOR TENDER	06/03/29	LL			<table border="1"> <tr> <td colspan="2">WATER TREATMENT PLANT FILTRATION MECHANICAL AND ELECTRICAL</td> <td>CITY FILE NUMBER</td> </tr> <tr> <td colspan="2">ELECTRICAL FILTRATION AREA 2 THIRD FLOOR POWER AND LIGHTING PLAN</td> <td>SHEET OF</td> </tr> <tr> <td colspan="2"></td> <td>CITY DRAWING NUMBER</td> </tr> <tr> <td colspan="2"></td> <td>1-0601F-A-E0136-001-01D</td> </tr> </table>		WATER TREATMENT PLANT FILTRATION MECHANICAL AND ELECTRICAL		CITY FILE NUMBER	ELECTRICAL FILTRATION AREA 2 THIRD FLOOR POWER AND LIGHTING PLAN		SHEET OF			CITY DRAWING NUMBER			1-0601F-A-E0136-001-01D
NO.	REVISIONS	DATE	BY	DATE	DATE																													
01	742-2005 ADDENDUM 3	06/05/05	LL																															
00	ISSUED FOR TENDER	06/03/29	LL																															
WATER TREATMENT PLANT FILTRATION MECHANICAL AND ELECTRICAL		CITY FILE NUMBER																																
ELECTRICAL FILTRATION AREA 2 THIRD FLOOR POWER AND LIGHTING PLAN		SHEET OF																																
		CITY DRAWING NUMBER																																
		1-0601F-A-E0136-001-01D																																