
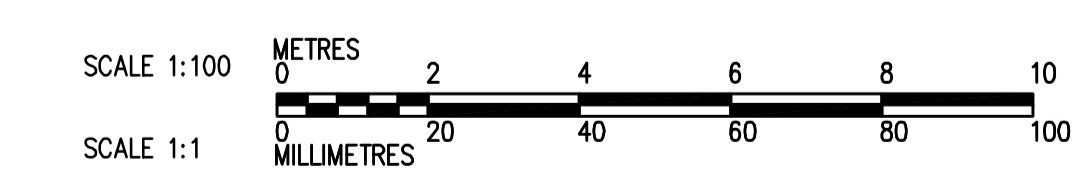


THIRD FLOOR PLAN
1:100

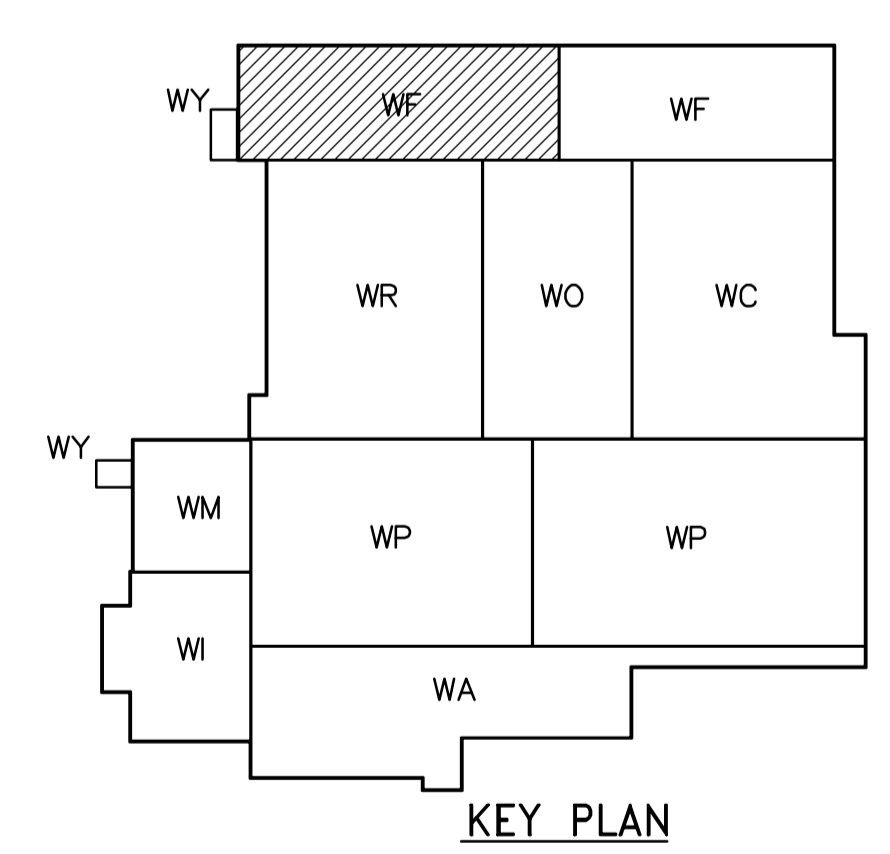

 APEGN Certificate of Authorization CH2M HILL Canada Ltd. No. 1441 Expiry: April 30, 2007	B.M. ELEV. <table border="1"> <tr><td> </td><td> </td><td> </td><td> </td></tr> <tr><td> </td><td> </td><td> </td><td> </td></tr> <tr><td> </td><td> </td><td> </td><td> </td></tr> <tr><td> </td><td> </td><td> </td><td> </td></tr> </table>																	 Frederickson Cooper ARCHITECTS	 A Terra International Ltd. Company	ENGINEER'S SEAL	 THE CITY OF WINNIPEG WATER AND WASTE DEPARTMENT ENGINEERING DIVISION
DESIGNED BY JZ/SW	CHECKED BY DL	ORIGINAL SIGNED BY D.K. CUDDINGTON																			
DRAWN BY JMcP	APPROVED BY DJT	2006/02/06																			
SCALE: 1:100	RELEASED FOR CONSTRUCTION BY: R. SOROKOWSKI	CONSULTANT DRAWING NO. WF-H9133																			
NO. REVISIONS <table border="1"> <tr><td>01</td><td>742-2005 ADDENDUM 3</td><td>06/05/05</td><td>SW</td></tr> <tr><td>00</td><td>ISSUED FOR TENDER</td><td>2006/02/03</td><td>SW</td></tr> </table>	01	742-2005 ADDENDUM 3	06/05/05	SW	00	ISSUED FOR TENDER	2006/02/03	SW	DATE 2005/08/02	DATE 2006/02/08	WATER TREATMENT PLANT FILTRATION MECHANICAL AND ELECTRICAL PLUMBING PIPE EMBEDS FILTRATION AREA 1 THIRD FLOOR PLAN	CITY FILE NUMBER SHEET OF CITY DRAWING NUMBER 1-0601F-A-H9133-001-01D									
01	742-2005 ADDENDUM 3	06/05/05	SW																		
00	ISSUED FOR TENDER	2006/02/03	SW																		