



- NOTES:**
1. ALL 120V AND 208V LOADS ARE FED FROM LP-P11.
  2. EMERGENCY LIGHTING EM-X-1, -2 ETC ARE FED FROM BATTERY PACK EM-X.

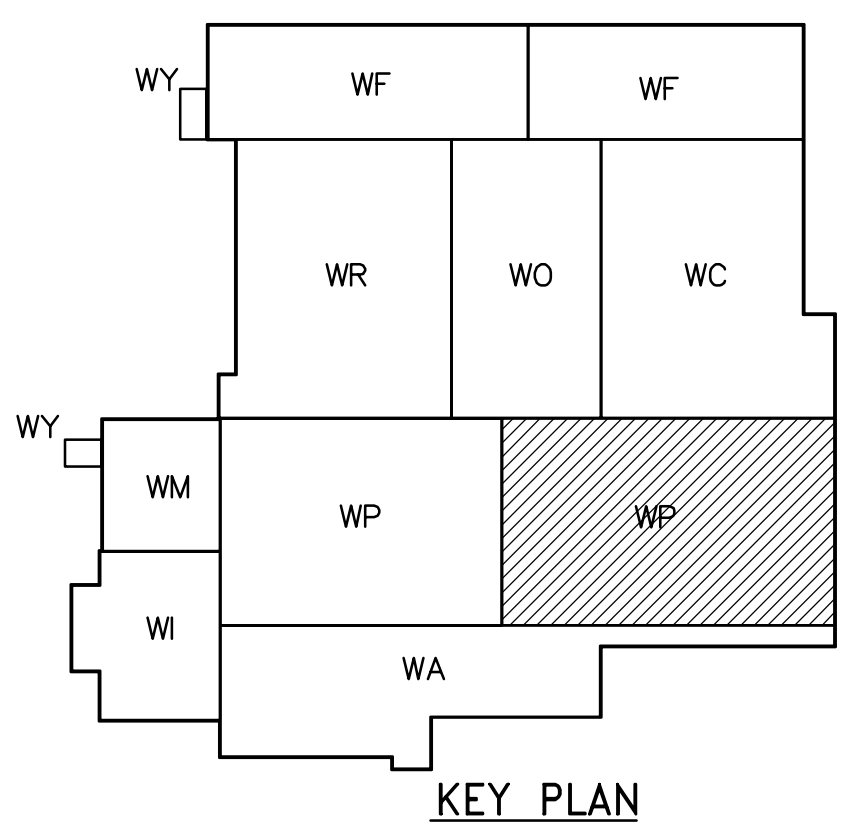

FIRST FLOOR POWER AND LIGHTING PLAN (AREA 2)  
1:100

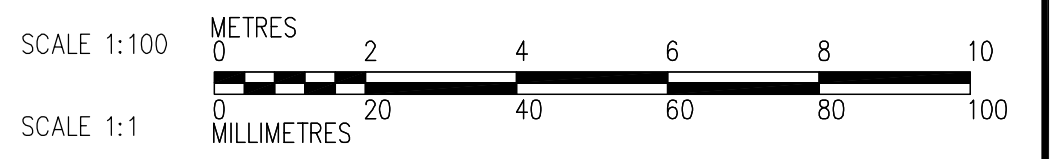

<p><b>APEGN</b> Certificate of Authorization CH2M HILL Canada Ltd. No. 1441 Expiry: April 30, 2007</p>	<p>Frederickson Cooper ARCHITECTS</p>		<p>EarthTech A Tyco International Ltd. Company</p>		ENGINEER'S SEAL  ORIGINAL SIGNED BY L.D. LLEWELLYN 2006/03/29	<p><b>THE CITY OF WINNIPEG</b> WATER AND WASTE DEPARTMENT ENGINEERING DIVISION</p>
	DESIGNED BY JT      CHECKED BY ND		APPROVED BY AHL		CONSULTANT DRAWING NO. WP-E0116	
	DRAWN BY KJ		RELEASED FOR CONSTRUCTION BY: R. SOROKOWSKI			
	SCALE: 1:100		DATE 2005/07/12      DATE 2006/03/29		WATER TREATMENT PLANT FLOCCULATION AND DAF MECHANICAL AND ELECTRICAL	
NO. REVISIONS      DATE BY		DATE 2005/07/12      DATE 2006/03/29		ELECTRICAL FLOC/DAF AREA 2 FIRST FLOOR POWER AND LIGHTING PLAN		CITY DRAWING NUMBER 1-0601P-A-E0116-001-01D