

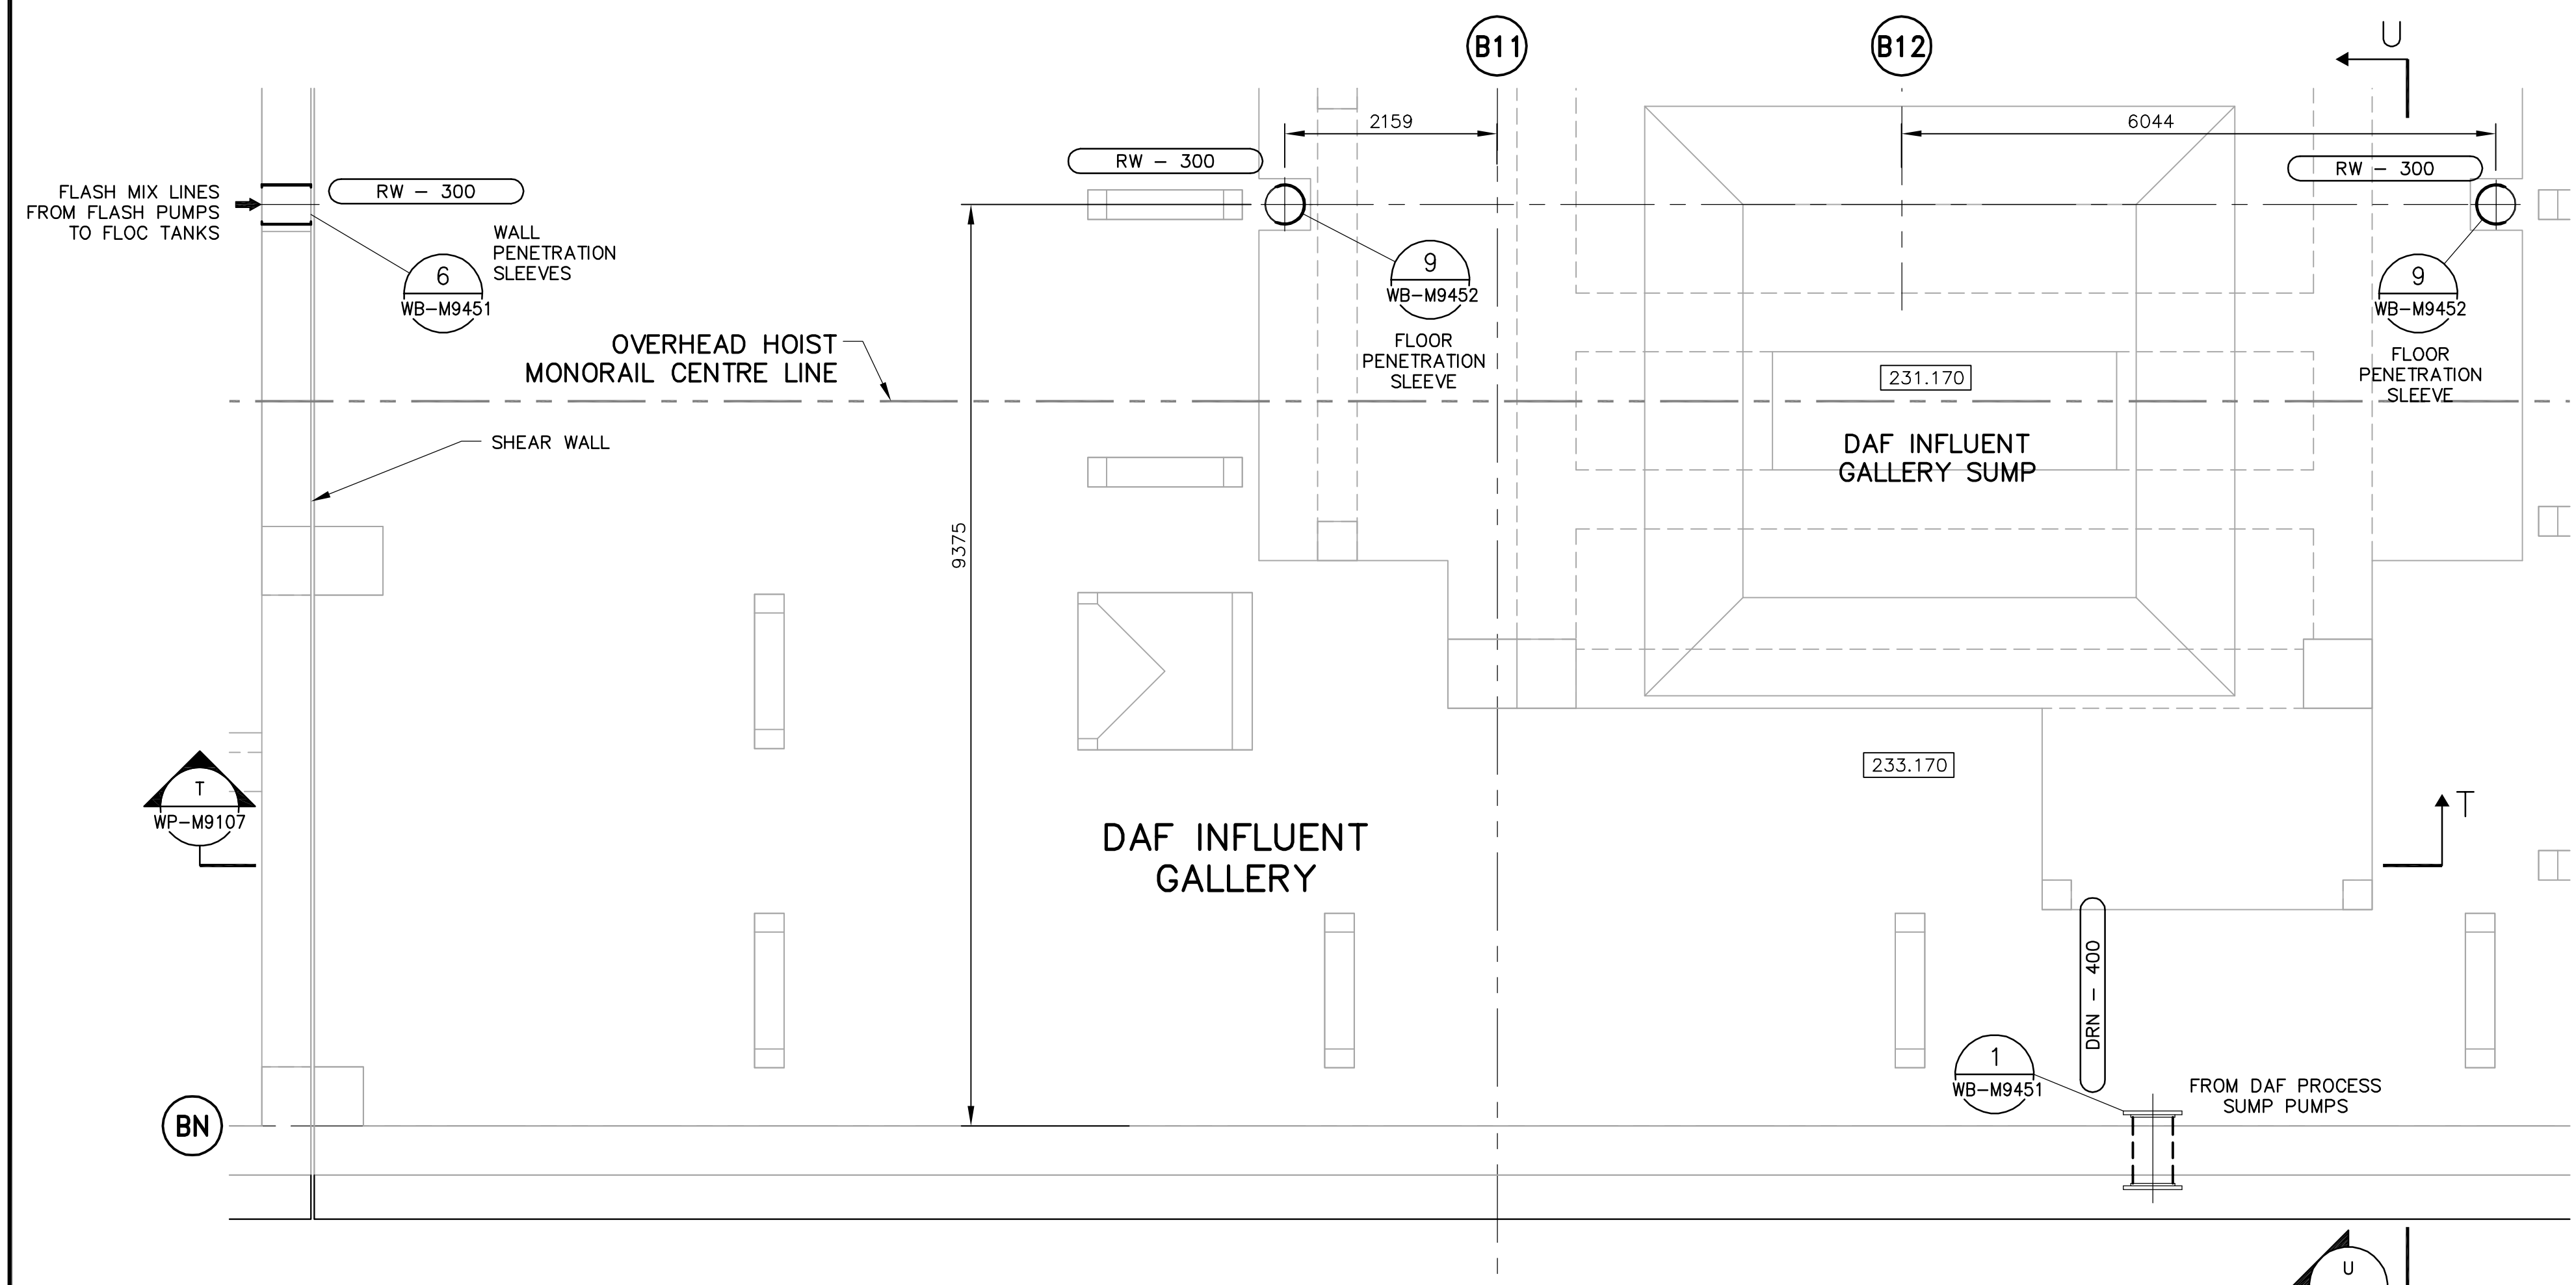


T SECTION - DAF INFLUENT GALLERY SUMP PUMPS
WP-M9107 1:50


U SECTION - DAF INFLUENT GALLERY SUMP PUMPS
WP-M9107 1:50

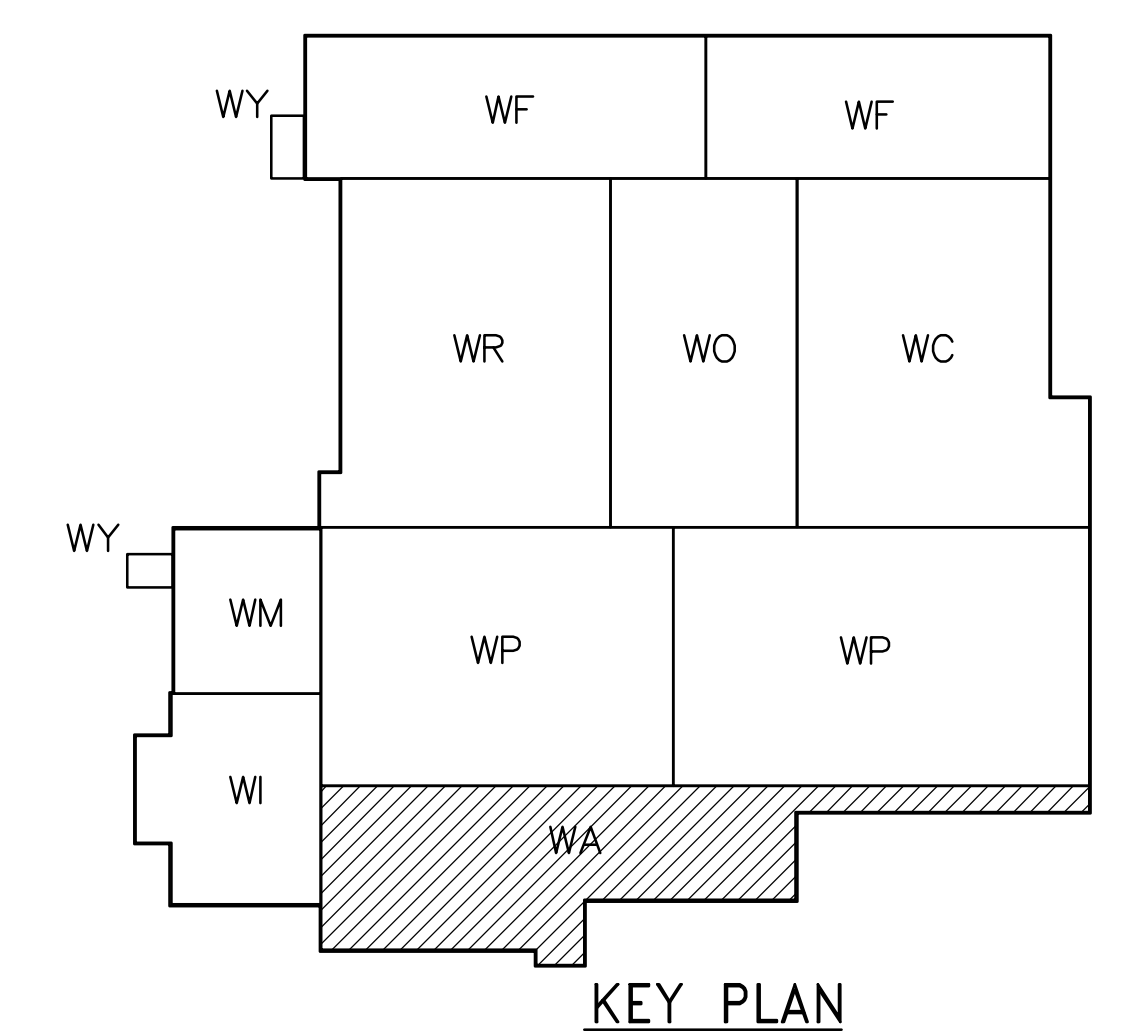

23 FIRST FLOOR PLAN - DAF INFLUENT GALLERY SUMP PUMPS
WP-M9107 1:50

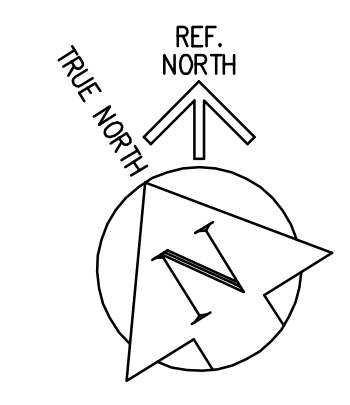

KEY PLAN

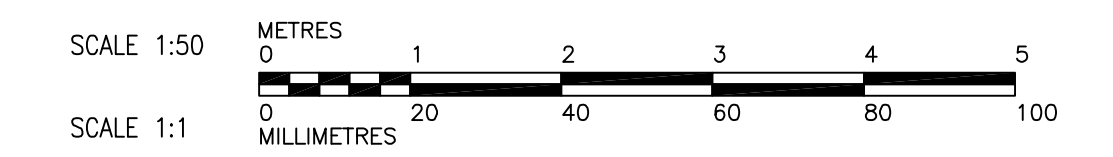

<p>APEGN Certificate of Authorization Earth Tech Canada Inc. No. 730 Expiry: April 30, 2007</p>		<p>CH2M HILL Frederickson Cooper ARCHITECTS</p>		<p>EarthTech A Tech International Ltd. Company</p>		<p>ENGINEER'S SEAL</p> <p>ORIGINAL SIGNED BY S.R. BILEVICIUS 2006/02/07</p> <p>CONSULTANT DRAWING NO. WP-M9107</p>	
DESIGNED BY	KAS	CHECKED BY	SRB	SCALE:	AS SHOWN	RELEASED FOR CONSTRUCTION BY:	R. SOROKOWSKI
DRAWN BY	PL/LC	APPROVED BY	DJT	DATE	2005/11/28	DATE	2006/02/07
NO.	REVISIONS	DATE	BY				
01	742-2005 ADDENDUM 3	06/05/05	LAE				
00	ISSUED FOR TENDER	06/02/03	PL				

<p>B.M. ELEV.</p>		<p>DESIGNED BY</p>		<p>CHECKED BY</p>		<p>ENGINEER'S SEAL</p>	
		KAS		SRB		ORIGINAL SIGNED BY S.R. BILEVICIUS 2006/02/07	
		DRAWN BY PL/LC		APPROVED BY DJT		CONSULTANT DRAWING NO. WP-M9107	
		SCALE: AS SHOWN		RELEASED FOR CONSTRUCTION BY: R. SOROKOWSKI		CITY FILE NUMBER	
		DATE 2005/11/28		DATE 2006/02/07		SHEET OF	
						CITY DRAWING NUMBER	
						1-0601P-A-M9107-001-01D	

THE CITY OF WINNIPEG
WATER AND WASTE DEPARTMENT
ENGINEERING DIVISION

WATER TREATMENT PLANT
FLOCCULATION AND DAF
FOUNDATIONS AND CONCRETE STRUCTURES

PIPE EMBEDS
FIRST FLOOR PLAN AND SECTIONS
RAW WATER SUMP DISCHARGE PIPING