
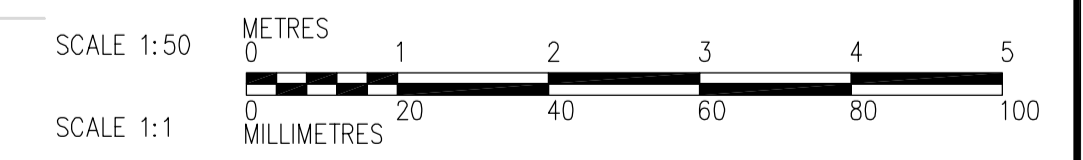


NOTES
 1. SEE MCC 3A & 3B SINGLE LINE DIAGRAMS AND PANNEL SCHEDULES FOR DRR-21 & DPR-22 FOR 600V POWER DISTRIBUTION.

SECOND FLOOR PROCESS PLAN
 1:100

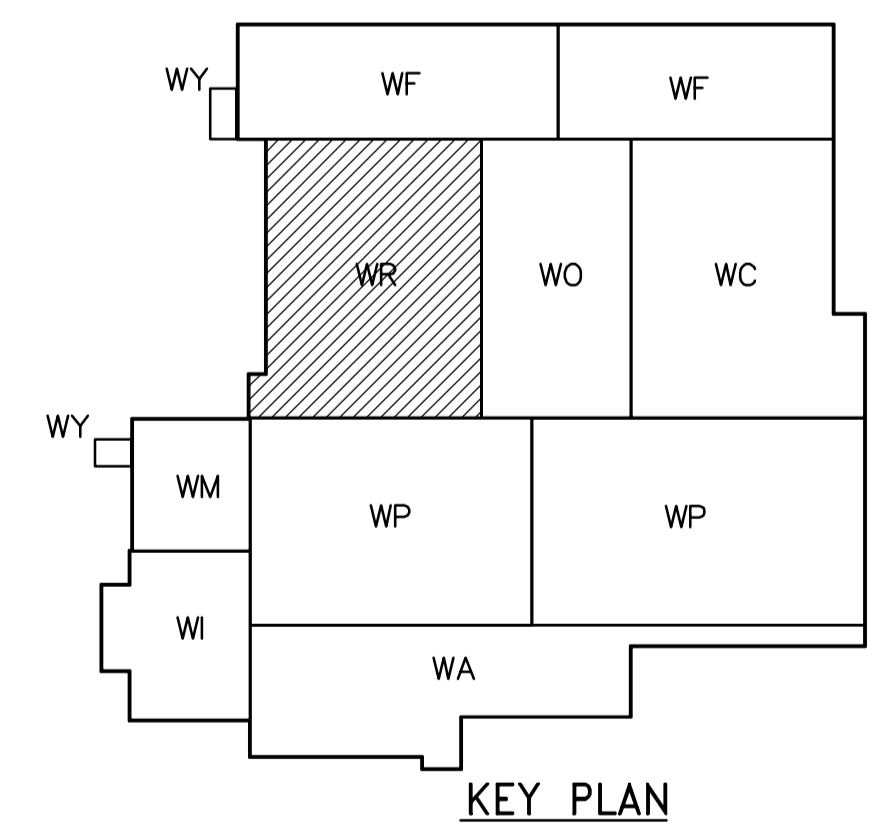

<p>APECA Certificate of Authorization CH2M HILL Canada Ltd. No. 1441 Expiry: April 30, 2007</p>	B.M. ELEV.	<p>Frederickson Cooper ARCHITECTS</p>	<p>EarthTech A Tyco International Ltd. Company</p>	ENGINEER'S SEAL	<p>THE CITY OF WINNIPEG WATER AND WASTE DEPARTMENT ENGINEERING DIVISION</p>		
				DESIGNED BY LL		CHECKED BY ND	ORIGINAL SIGNED BY L.D. LLEWELLYN
				DRAWN BY TL		APPROVED BY AHL	2006/03/29
				SCALE: 1:50		RELEASED FOR CONSTRUCTION BY: R. SOROKOWSKI	CONSULTANT DRAWING NO. WR-E0401
	NO. REVISIONS	DATE	DATE	DATE	WATER TREATMENT PLANT RESIDUALS HANDLING MECHANICAL AND ELECTRICAL ELECTRICAL RESIDUALS HANDLING AREA SECOND FLOOR PROCESS PLAN		
					CITY FILE NUMBER SHEET OF CITY DRAWING NUMBER 1-0601R-A-E0401-001-01D		