

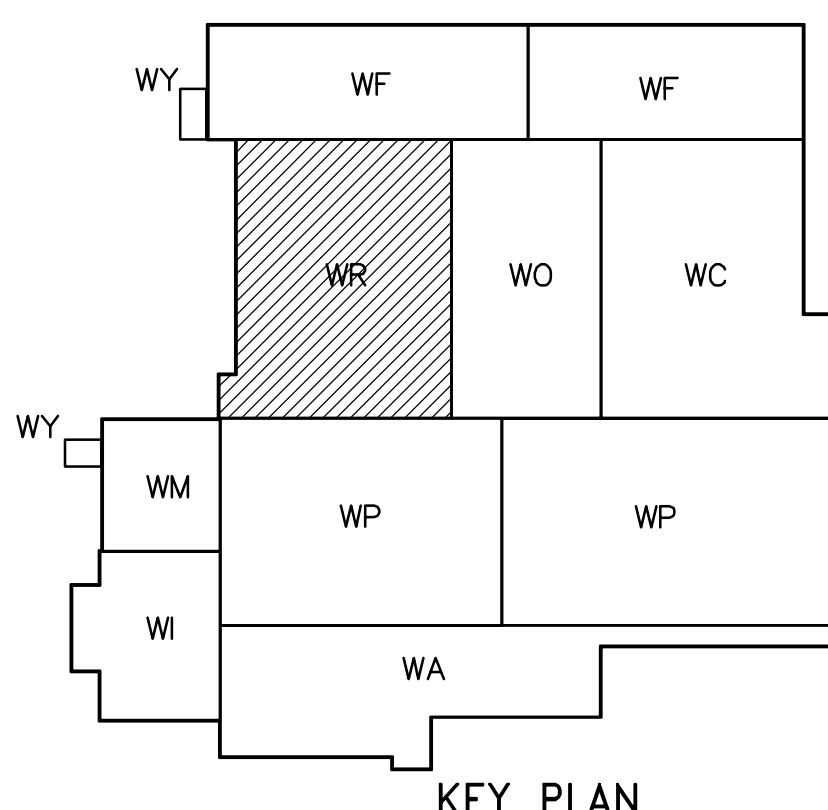


1
-
1:50
DETAIL

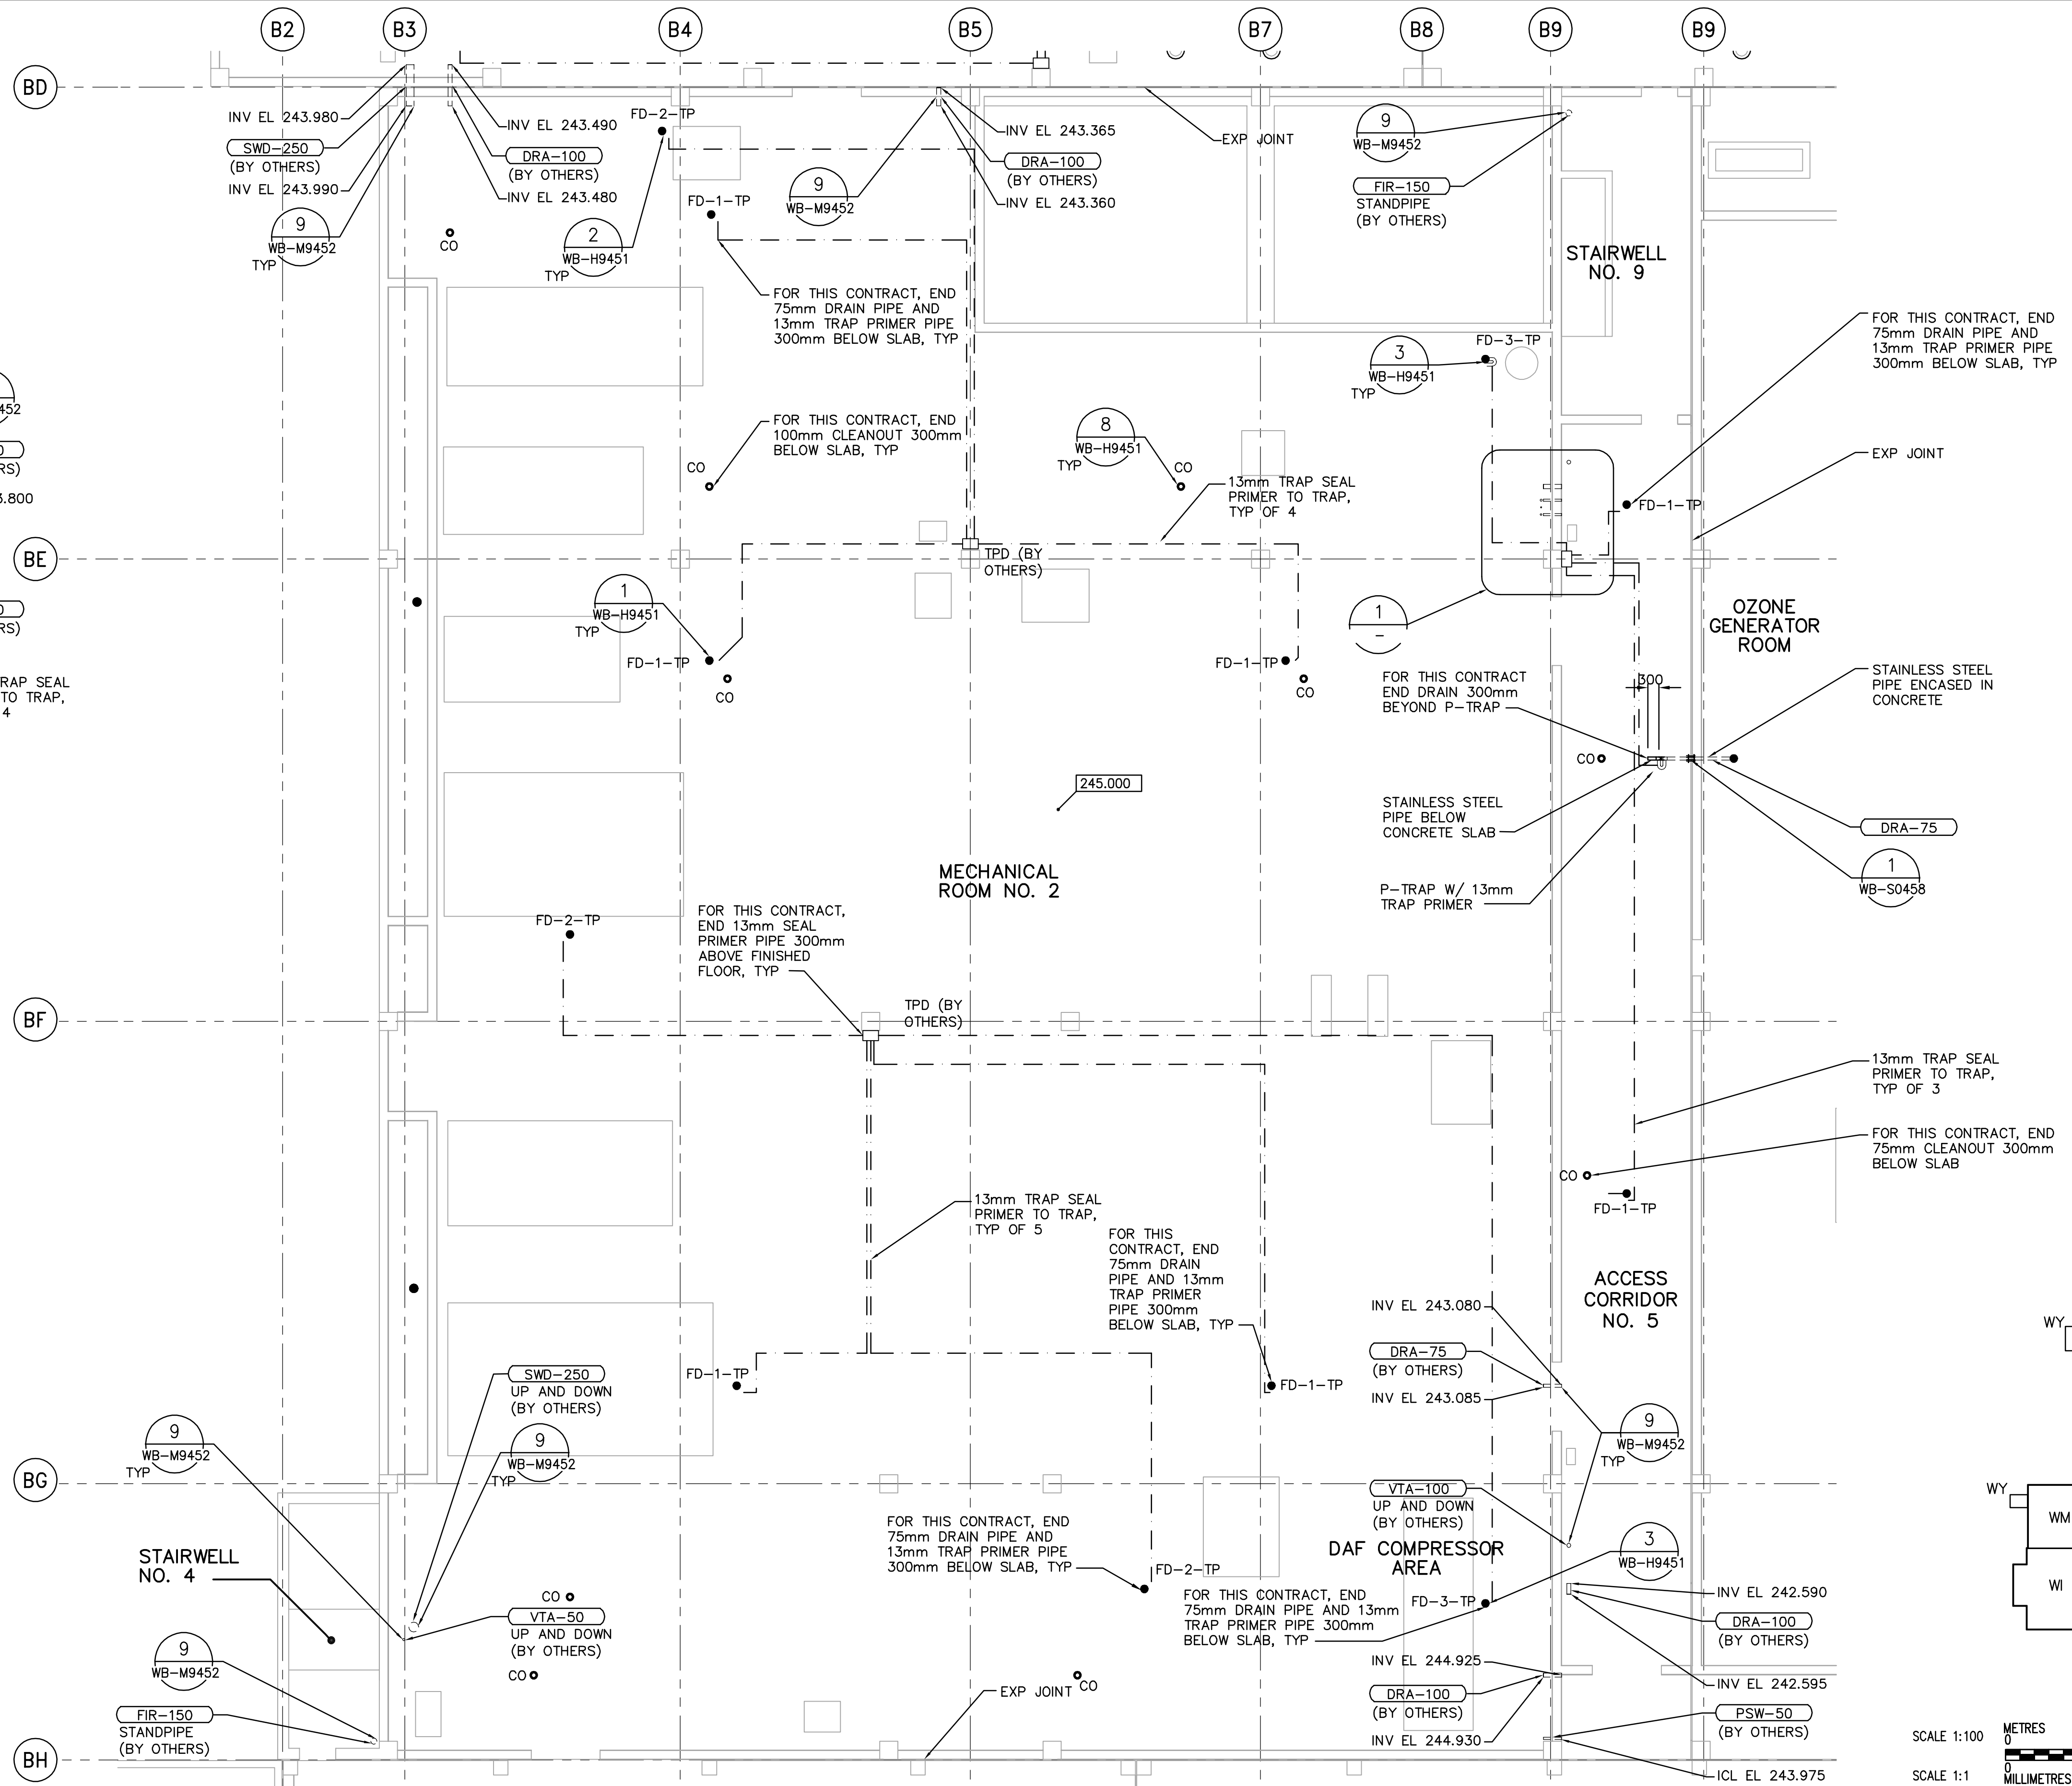

KEY PLAN

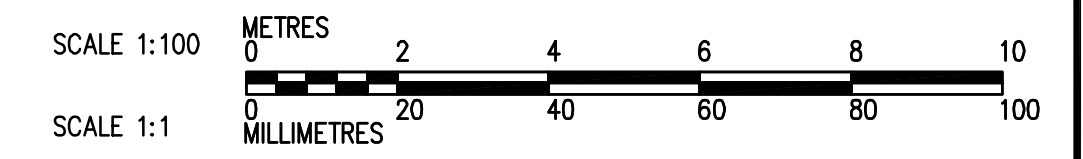

THIRD FLOOR PLAN
1:100

<p>Certificate of Authorization CH2M HILL Canada Ltd. No. 1441 Expiry: April 30, 2007</p>	B.M. ELEV.	<p>Frederickson Cooper ARCHITECTS</p>	<p>A Tyco International Ltd. Company</p>	ENGINEER'S SEAL	<p>THE CITY OF WINNIPEG WATER AND WASTE DEPARTMENT ENGINEERING DIVISION</p>	
	DESIGNED BY JZ/SW			CHECKED BY DL		ORIGINAL SIGNED BY D.K. CUDDINGTON
	DRAWN BY JmCP			APPROVED BY DJT		2006/02/06
	SCALE: 1:100			RELEASED FOR CONSTRUCTION BY: R. SOROKOWSKI		CONSULTANT DRAWING NO. WR-H9132
01 742-2005 ADDENDUM 3 06/05/05 SW	DATE 2005/08/02	DATE 2006/02/08	DATE 2006/02/08	PLUMBING PIPE EMBEDS RESIDUALS AREA THIRD FLOOR PLAN	CITY FILE NUMBER SHEET OF CITY DRAWING NUMBER 1-0601R-A-H9132-001-01D	