



**NOTE:**  
1. ALL LUMINARIES 27a\* ARE FED FROM LP-A11

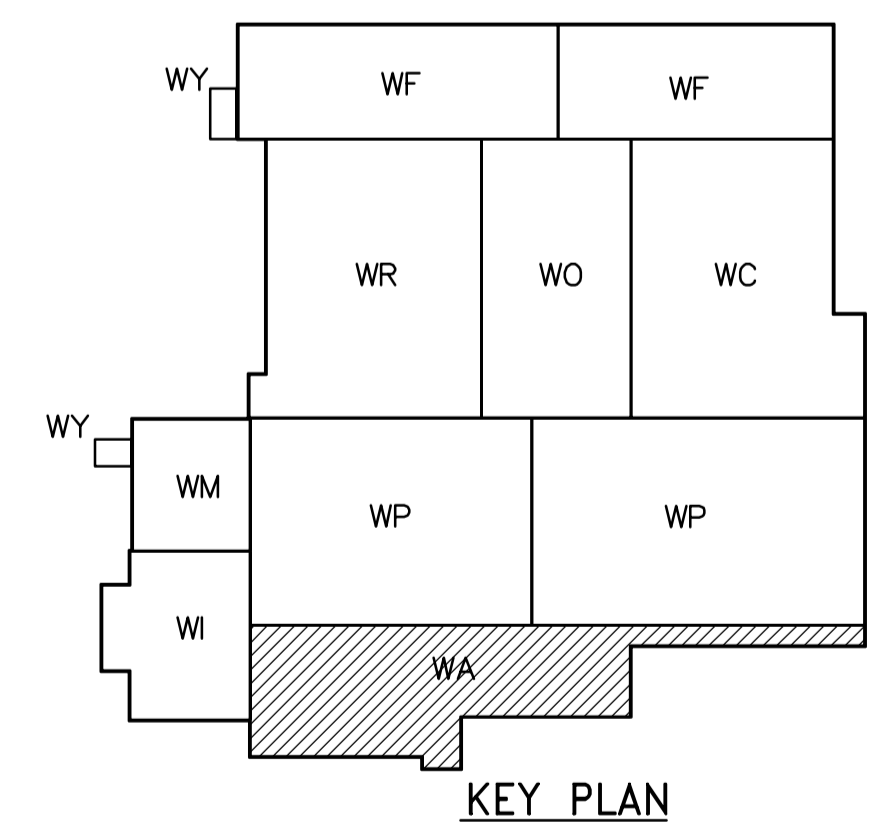

**SECOND FLOOR POWER AND LIGHTING PLAN**  
1:100

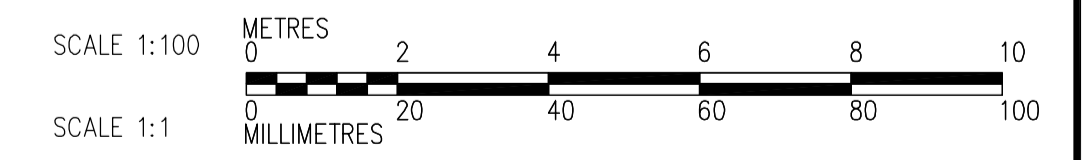

 <b>APEGN</b> Certificate of Authorization CH2M HILL Canada Ltd. No. 1441 Expiry: April 30, 2007	 Frederickson Cooper ARCHITECTS		 A Terra International Ltd. Company		ENGINEER'S SEAL  ORIGINAL SIGNED BY L.D. LLEWELLYN  2006/03/29	 <b>THE CITY OF WINNIPEG</b> WATER AND WASTE DEPARTMENT ENGINEERING DIVISION  WATER TREATMENT PLANT ADMINISTRATION AREA MECHANICAL AND ELECTRICAL  ELECTRICAL ADMINISTRATION AREA SECOND FLOOR POWER AND LIGHTING PLAN	CITY FILE NUMBER
	DESIGNED BY PF CHECKED BY ND DRAWN BY TL APPROVED BY AHL		SCALE: 1:100 RELEASED FOR CONSTRUCTION BY: R. SOROKOWSKI		CONSULTANT DRAWING NO. WA-E0123		SHEET OF
	NO. REVISIONS DATE BY DATE 2006/02/07 DATE 2006/03/29		02 742-2005 ADDENDUM 4 06/05/12 LL 01 742-2005 ADDENDUM 3 06/05/05 LL 00 ISSUED FOR TENDER 06/03/26 LL		CITY DRAWING NUMBER 1-0601A-A-E0123-001-020		