
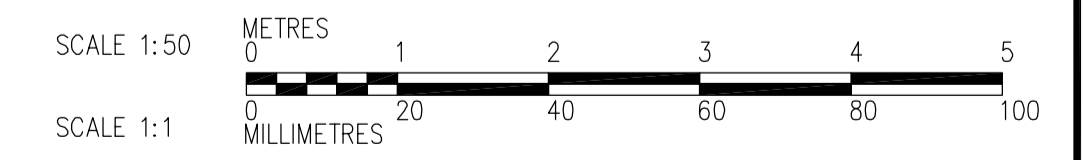


- NOTES:**
- ALL 120V AND 208V LOADS ARE FED FROM LP-A31.
  - EMERGENCY LIGHTING EM-X-1 ARE FED FROM BATTERY PACK EM-X.

**1 THIRD FLOOR POWER AND LIGHTING PLAN**  
WA-E0133 1:100

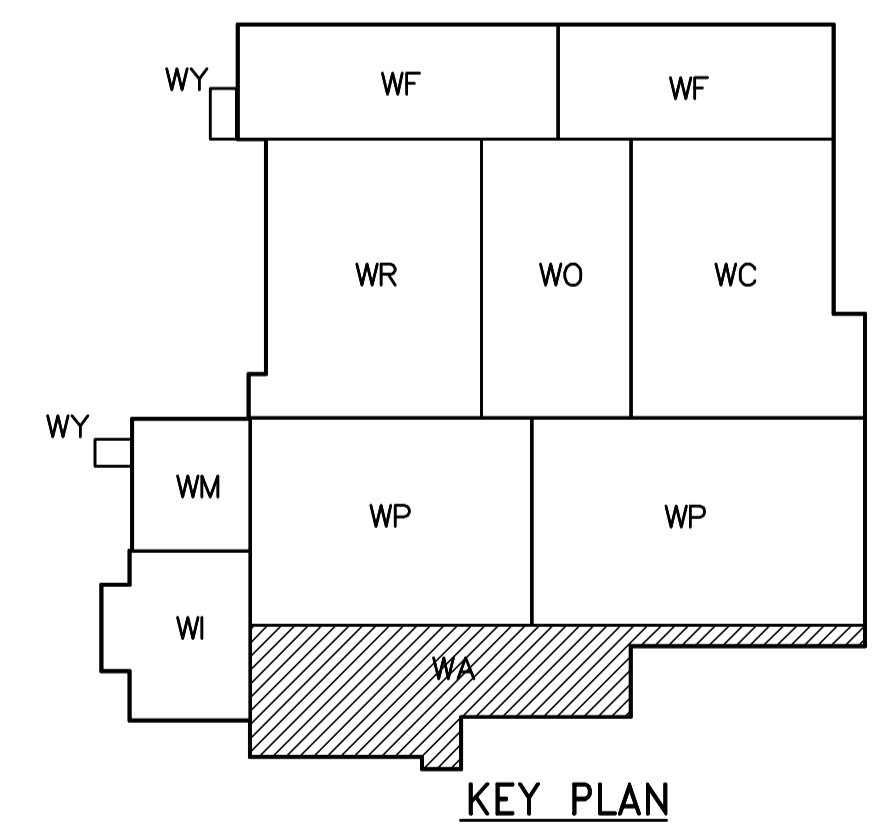

<p><b>APEGN</b> Certificate of Authorization CH2M HILL Canada Ltd. No. 1441 Expiry: April 30, 2007</p>	<p>B.M. ELEV.</p> <table border="1"> <tr><td> </td><td> </td><td> </td></tr> <tr><td> </td><td> </td><td> </td></tr> <tr><td> </td><td> </td><td> </td></tr> </table>										<p>Frederickson Cooper ARCHITECTS</p>	<p>A Terra International Ltd. Company</p>	<p>ENGINEER'S SEAL</p> <p>ORIGINAL SIGNED BY L.D. LLEWELLYN 2006/03/29</p>	<p><b>THE CITY OF WINNIPEG</b> WATER AND WASTE DEPARTMENT ENGINEERING DIVISION</p> <p>WATER TREATMENT PLANT ADMINISTRATION MECHANICAL AND ELECTRICAL</p> <p>ELECTRICAL ADMINISTRATION AREA THIRD FLOOR POWER AND LIGHTING PLAN</p>										
<table border="1"> <tr><td>02</td><td>742-2005 ADDENDUM 4</td><td>06/05/12</td><td>LL</td></tr> <tr><td>01</td><td>742-2005 ADDENDUM 3</td><td>06/05/05</td><td>LL</td></tr> <tr><td>00</td><td>ISSUED FOR TENDER</td><td>06/03/29</td><td>LL</td></tr> </table>	02	742-2005 ADDENDUM 4	06/05/12	LL	01	742-2005 ADDENDUM 3	06/05/05	LL	00	ISSUED FOR TENDER	06/03/29	LL	<table border="1"> <tr><td>DESIGNED BY</td><td>LL</td><td>CHECKED BY</td><td>ND</td></tr> <tr><td>DRAWN BY</td><td>TL</td><td>APPROVED BY</td><td>AHL</td></tr> </table>	DESIGNED BY	LL	CHECKED BY	ND	DRAWN BY	TL	APPROVED BY	AHL	<p>SCALE: 1:50</p> <p>RELEASED FOR CONSTRUCTION BY: R. SOROKOWSKI</p>	<p>CONSULTANT DRAWING NO. WA-E0403</p>	<p>CITY FILE NUMBER</p> <p>SHEET OF</p> <p>CITY DRAWING NUMBER 1-0601A-A-E0403-001-020</p>
02	742-2005 ADDENDUM 4	06/05/12	LL																					
01	742-2005 ADDENDUM 3	06/05/05	LL																					
00	ISSUED FOR TENDER	06/03/29	LL																					
DESIGNED BY	LL	CHECKED BY	ND																					
DRAWN BY	TL	APPROVED BY	AHL																					
<table border="1"> <tr><th>NO.</th><th>REVISIONS</th><th>DATE</th><th>BY</th><th>DATE</th><th>DATE</th></tr> <tr><td> </td><td> </td><td> </td><td> </td><td> </td><td> </td></tr> </table>	NO.	REVISIONS	DATE	BY	DATE	DATE							<p>DATE 2006/03/10</p> <p>DATE 2006/03/29</p>	<p>DATE 2006/03/10</p> <p>DATE 2006/03/29</p>	<p>DATE 2006/03/10</p> <p>DATE 2006/03/29</p>	<p>DATE 2006/03/10</p> <p>DATE 2006/03/29</p>								
NO.	REVISIONS	DATE	BY	DATE	DATE																			
<p>WA-E0133</p>	<p>2006/03/10</p>	<p>2006/03/29</p>	<p>2006/03/10</p>	<p>2006/03/29</p>																				