



- NOTES:**
- SEE MCC #2A & #2B SINGLE LINE DIAGRAM AND DP-P11 & DP-P12 POWER DISTRIBUTION FOR 600V POWER DISTRIBUTION.
  - ALL 120 AND 208V LOADS ARE FED FROM LP-P11.
  - PROVIDE STAIRWELL SMOKE DETECTORS AS SHOWN ON FIRE PROTECTION DRAWINGS
  - ALL 120 AND 208V LOADS ARE FED FROM LP-P11

CABLE TRAY TAGGING  
SEE DETAIL  
4  
WB-E0455

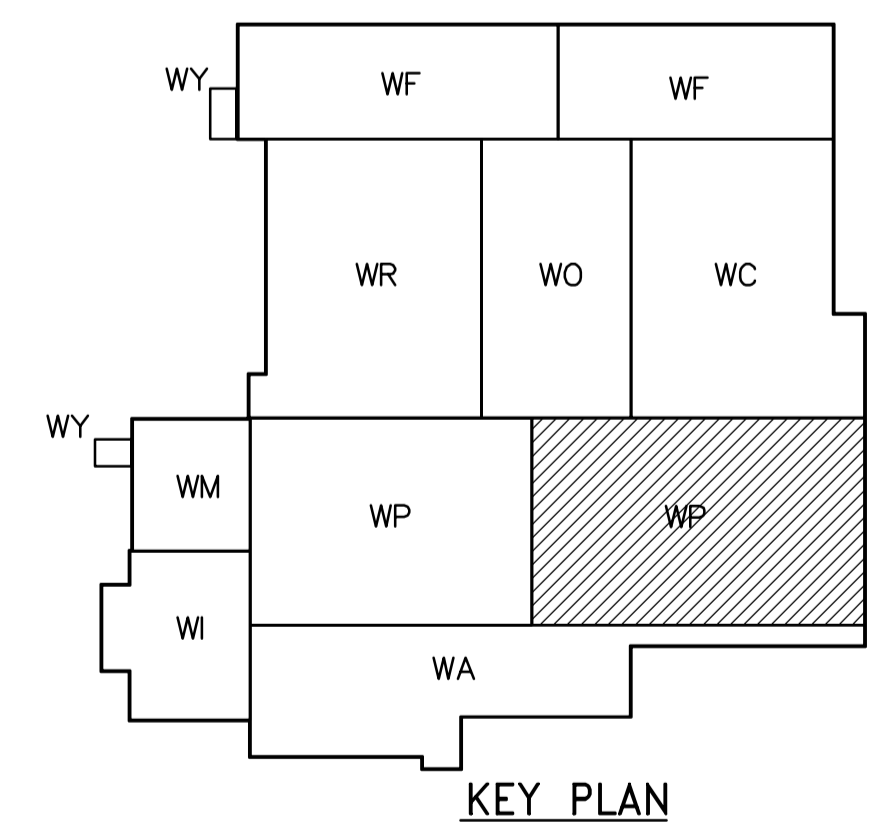

**FIRST FLOOR FACILITY PLAN (AREA 2)**  
1:100

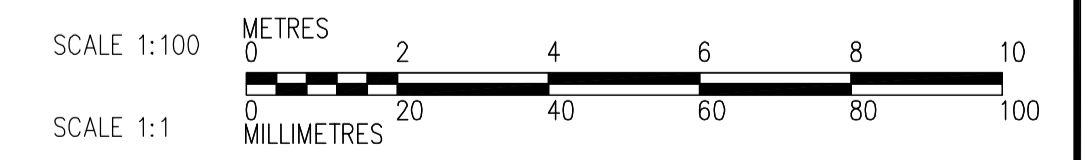

<p><b>APEGN</b> Certificate of Authorization CH2M HILL Canada Ltd. No. 1441 Expiry: April 30, 2007</p>	<p>Frederickson Cooper ARCHITECTS</p>	<p>EarthTech A Tyco International Ltd. Company</p>	ENGINEER'S SEAL	<p><b>THE CITY OF WINNIPEG</b> WATER AND WASTE DEPARTMENT ENGINEERING DIVISION</p>		
			DESIGNED BY JT		CHECKED BY ND	ORIGINAL SIGNED BY L.D. LLEWELLYN
			DRAWN BY KJ		APPROVED BY AHL	2006/03/29
			SCALE: 1:100		RELEASED FOR CONSTRUCTION BY: R. SOROKOWSKI	CONSULTANT DRAWING NO. WP-E0112
<p>WATER TREATMENT PLANT FLOCCULATION AND DAF MECHANICAL AND ELECTRICAL</p>			CITY FILE NUMBER	<p>CITY DRAWING NUMBER 1-0601P-A-E0112-001-02D</p>		
<p>ELECTRICAL FLOC/DAF AREA 2 FIRST FLOOR FACILITY PLAN</p>			SHEET OF			