


- NOTES:**
- ALL 120V AND 208V LOADS ARE FED FROM LP-P11.
  - EMERGENCY LIGHTING EM-X-1, -2 ETC ARE FED FROM BATTERY PACK EM-X.



**FIRST FLOOR POWER AND LIGHTING PLAN (AREA 1)**  
1:100

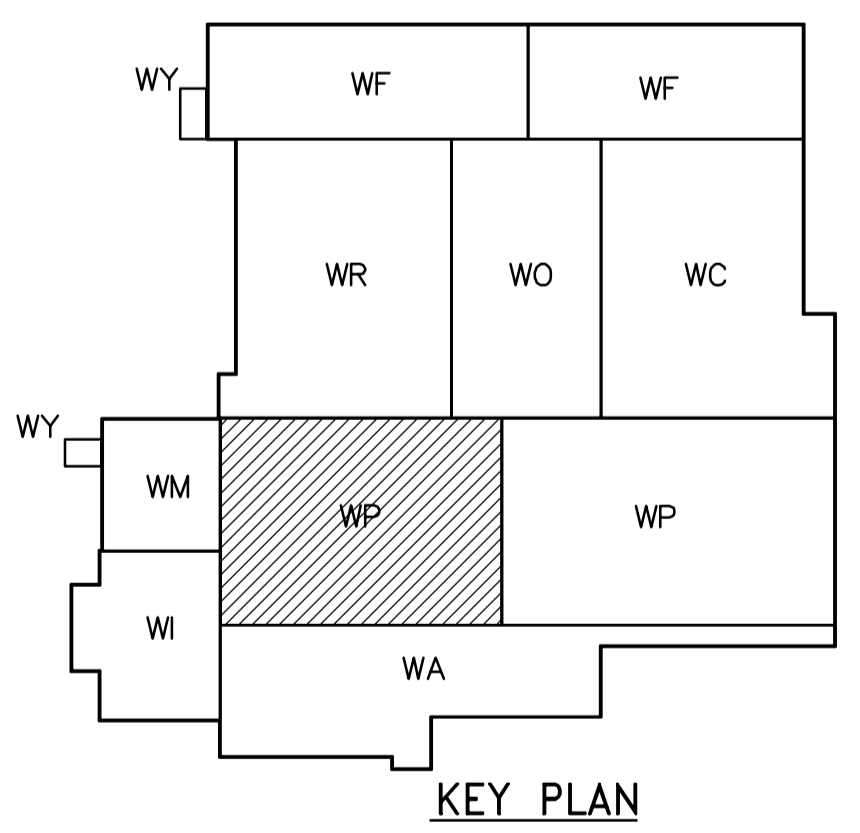

<p><b>APEGN</b> Certificate of Authorization CH2M HILL Canada Ltd. No. 1441 Expiry: April 30, 2007</p>	<p>Frederickson Cooper ARCHITECTS</p>	<p>A You International Ltd. Company</p>	ENGINEER'S SEAL  ORIGINAL SIGNED BY L.D. LLEWELLYN 2006/03/29	<p><b>THE CITY OF WINNIPEG</b> WATER AND WASTE DEPARTMENT ENGINEERING DIVISION</p>	
			DESIGNED BY: JT CHECKED BY: ND DRAWN BY: KJ APPROVED BY: AHL		CITY FILE NUMBER SHEET OF
			SCALE: 1:100 RELEASED FOR CONSTRUCTION BY: R. SOROKOWSKI		CITY DRAWING NUMBER 1-0601P-A-E0115-001-01D
			CONSULTANT DRAWING NO. WP-E0115		ELECTRICAL FLOC/DAF AREA 1 FIRST FLOOR POWER AND LIGHTING PLAN
B.M. ELEV.	DESIGNED BY: JT CHECKED BY: ND DRAWN BY: KJ APPROVED BY: AHL	SCALE: 1:100 RELEASED FOR CONSTRUCTION BY: R. SOROKOWSKI	CONSULTANT DRAWING NO. WP-E0115	CITY FILE NUMBER SHEET OF CITY DRAWING NUMBER 1-0601P-A-E0115-001-01D	
NO. REVISIONS DATE BY	DATE 2005/07/12 DATE 2006/03/29	DATE 2005/07/12 DATE 2006/03/29	DATE 2005/07/12 DATE 2006/03/29	DATE 2005/07/12 DATE 2006/03/29	