


- NOTES:
1. REFER TO DWG WM-E0011 AND WM-H0001 FOR SYMBOL LEGENDS.
  2. REFER TO HVAC DRAWINGS FOR DUCT MOUNTED SMOKE DETECTOR LOCATIONS.

- F. EXT-2 (TYP. OF 2)
- FIRE ALARM PANEL
- FIRE DEPARTMENT CONNECTION
- FIRE PUMP ROOM SEE WM-H0113
- F. EXT-1 (TYP.)

FIRST FLOOR PLAN  
1:300

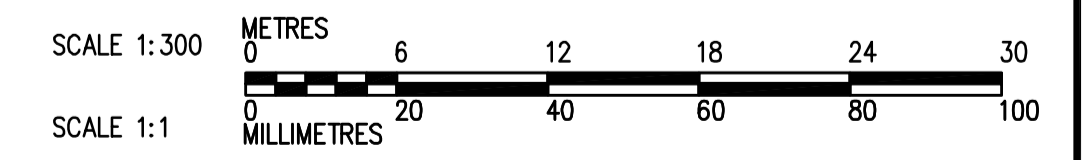

 <b>APEGN</b> Certificate of Authorization CH2M HILL Canada Ltd. No. 1441 Expiry: April 30, 2007	 <b>CH2MHILL</b> Frederickson Cooper ARCHITECTS	 <b>EarthTech</b> A Tyco International Ltd. Company	ENGINEER'S SEAL ORIGINAL SIGNED BY <b>D.K. CUDDINGTON</b> 2006/03/29	 <b>THE CITY OF WINNIPEG</b> WATER AND WASTE DEPARTMENT ENGINEERING DIVISION	CITY FILE NUMBER SHEET OF
DESIGNED BY <b>DKC</b> CHECKED BY <b>SW</b> DRAWN BY <b>VPS</b> APPROVED BY <b>AHL</b>			CONSULTANT DRAWING NO. <b>WB-H0112</b>		CITY DRAWING NUMBER <b>1-0601B-A-H0112-001-01D</b>
SCALE: 1:300 RELEASED FOR CONSTRUCTION BY: <b>R. SOROKOWSKI</b> DATE 2006/01/06      DATE 2006/03/29			FIRE PROTECTION OVERALL BUILDING FIRST FLOOR PLAN		