


- NOTES:
1. REFER TO DWG WM-E0011 AND WM-H0001 FOR SYMBOL LEGENDS.
  2. REFER TO HVAC DRAWINGS FOR DUCT MOUNTED SMOKE DETECTOR LOCATIONS.

**SECOND FLOOR PLAN**  
1:300

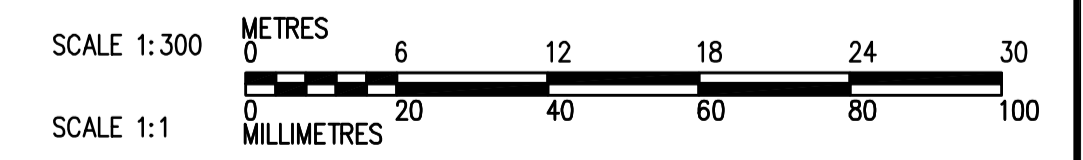

<p><b>APEGN</b> Certificate of Authorization CH2M HILL Canada Ltd. No. 1441 Expiry: April 30, 2007</p>	<p>B.M. ELEV.</p> <table border="1"> <tr><td> </td><td> </td><td> </td></tr> <tr><td> </td><td> </td><td> </td></tr> <tr><td> </td><td> </td><td> </td></tr> <tr><td> </td><td> </td><td> </td></tr> </table>													<p>Frederickson Cooper ARCHITECTS</p>	<p>EarthTech A Tyco International Ltd. Company</p>	<p>ENGINEER'S SEAL</p> <p>ORIGINAL SIGNED BY D.K. CUDDINGTON 2006/03/29</p>	<p><b>THE CITY OF WINNIPEG</b> WATER AND WASTE DEPARTMENT ENGINEERING DIVISION</p>	<p>DESIGNED BY DKC</p>	<p>CHECKED BY SW</p>	<p>WATER TREATMENT PLANT MAIN BUILDING MECHANICAL AND ELECTRICAL</p>	<p>CITY FILE NUMBER</p>
<p>DRAWN BY JMcP</p>	<p>APPROVED BY AHL</p>	<p>SHEET OF</p>																			
<p>SCALE: 1:300</p>	<p>RELEASED FOR CONSTRUCTION BY: R. SOROKOWSKI</p>	<p>CITY DRAWING NUMBER</p>																			
<p>NO. REVISIONS</p>	<p>DATE BY</p>	<p>DATE 2006/01/06</p>	<p>DATE 2006/03/29</p>	<p>FIRE PROTECTION OVERALL BUILDING SECOND FLOOR PLAN</p>	<p>1-0601B-A-H0122-001-01D</p>																