
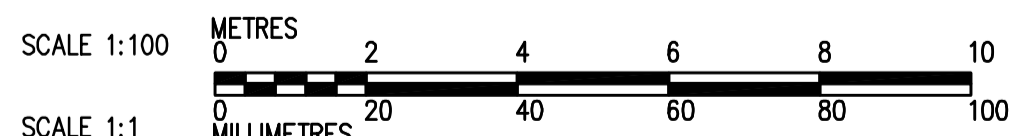


FIRST FLOOR PLAN  
1:100

THIRD FLOOR PLAN  
1:100

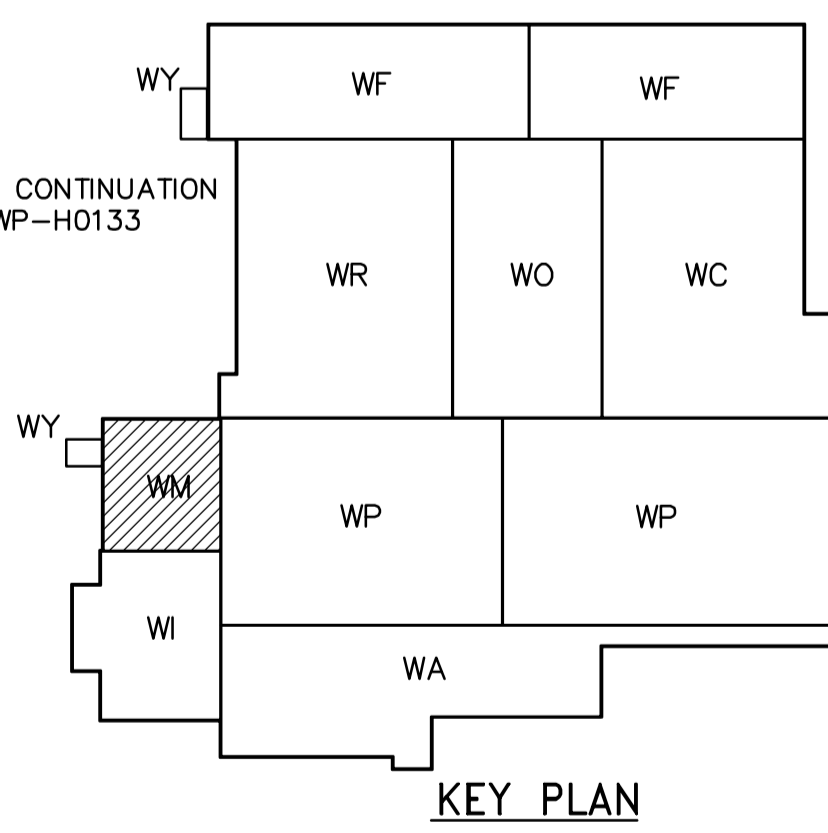

<p><b>APEGN</b> Certificate of Authorization CH2M HILL Canada Ltd. No. 1441 Expiry: April 30, 2007</p>	B.M. ELEV.	<p>Frederickson Cooper ARCHITECTS</p>	<p>EarthTech A Tyco International Ltd. Company</p>	ENGINEER'S SEAL	<p><b>THE CITY OF WINNIPEG</b> WATER AND WASTE DEPARTMENT ENGINEERING DIVISION</p>		
				DESIGNED BY JZ/SW		CHECKED BY SW	ORIGINAL SIGNED BY D.K. CUDDINGTON
		DRAWN BY JmCP	APPROVED BY AHL	2006/03/29		WATER TREATMENT PLANT GENERAL PLANT SERVICES/MISCELLANEOUS MECHANICAL AND ELECTRICAL	
		SCALE: 1:100	RELEASED FOR CONSTRUCTION BY: R. SOROKOWSKI	CONSULTANT DRAWING NO. WM-H0112		CITY FILE NUMBER SHEET OF CITY DRAWING NUMBER 1-0601M-A-H0112-001-01D	
	NO. REVISIONS	DATE	DATE	2005/10/18	DATE	2006/03/29	PLUMBING FIRE PUMP AND ELECTRICAL ROOM FIRST FLOOR AND THIRD FLOOR PLANS