


THIRD FLOOR PLAN
1:100

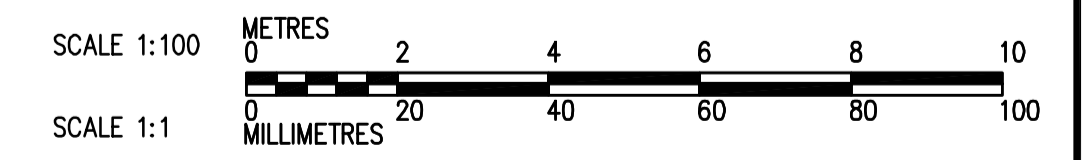

 APEGH Certificate of Authorization CH2M HILL Canada Ltd. No. 1441 Expiry: April 30, 2007	 Frederickson Cooper ARCHITECTS	 A Terra International Ltd. Company	ENGINEER'S SEAL	 THE CITY OF WINNIPEG WATER AND WASTE DEPARTMENT ENGINEERING DIVISION		
			DESIGNED BY JZ/SW		CHECKED BY DL	ORIGINAL SIGNED BY D.K. CUDDINGTON
			DRAWN BY JMcP		APPROVED BY AHL	2006/03/29
			SCALE: 1:100		RELEASED FOR CONSTRUCTION BY: R. SOROKOWSKI	CONSULTANT DRAWING NO. WP-H0133
B.M. ELEV.			WATER TREATMENT PLANT FLOCCULATION AND DAF MECHANICAL AND ELECTRICAL			
NO. REVISIONS DATE BY DATE 2005/07/15 DATE 2006/03/29			CITY FILE NUMBER SHEET OF CITY DRAWING NUMBER 1-0601P-A-H0133-001-01D			
PLUMBING FLOC/DAF AREA 1 THIRD FLOOR PLAN						