
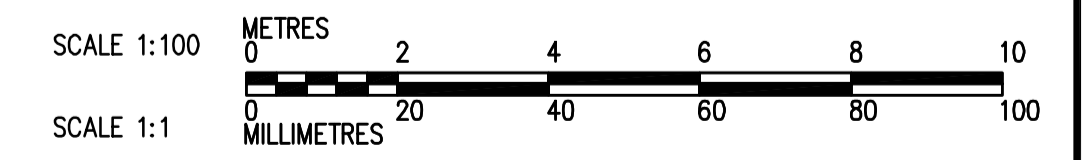


THIRD FLOOR PLAN
1:100

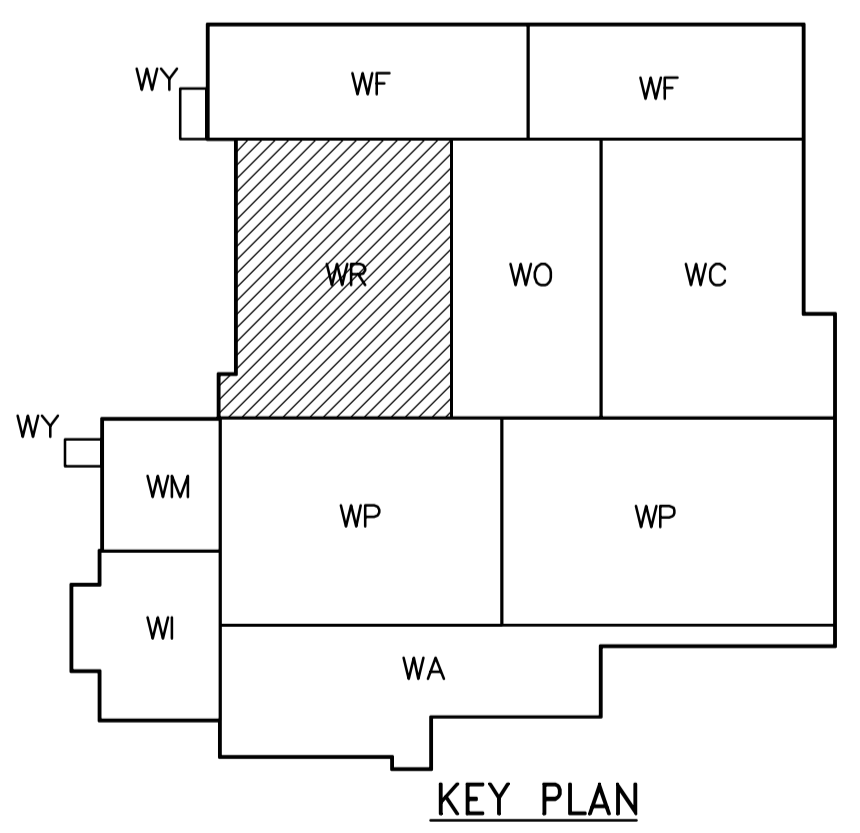

APECA
Certificate of Authorization
CH2M HILL Canada Ltd.
No. 1441 Expiry: April 30, 2007

NO.	REVISIONS	DATE	BY
01	742-2005 ADDENDUM 5	06/05/19	SW
00	ISSUED FOR TENDER	06/03/29	SW

CH2MHILL
Frederickson Cooper
ARCHITECTS

EarthTech
A Yoo International Ltd. Company

DESIGNED BY: JZ/SW
DRAWN BY: JMcP
SCALE: 1:100

CHECKED BY: DL
APPROVED BY: AHL
RELEASED FOR CONSTRUCTION BY: R. SOROKOWSKI
DATE: 2005/08/02

ENGINEER'S SEAL
ORIGINAL SIGNED BY: D.K. CUDDINGTON
DATE: 2006/03/29
CONSULTANT DRAWING NO.: WR-H0132

THE CITY OF WINNIPEG
WATER AND WASTE DEPARTMENT
ENGINEERING DIVISION

WATER TREATMENT PLANT
RESIDUALS HANDLING
MECHANICAL AND ELECTRICAL

PLUMBING
RESIDUALS AREA
THIRD FLOOR PLAN

CITY FILE NUMBER: _____
SHEET OF: _____
CITY DRAWING NUMBER: 1-0601R-A-H0132-001-01D