
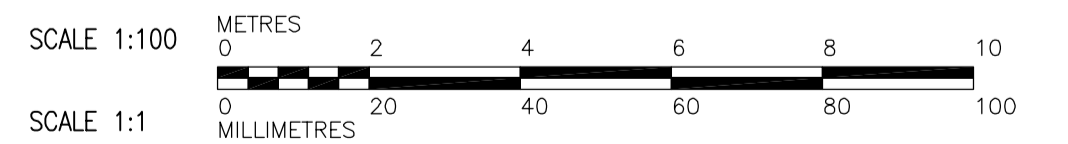


SECOND FLOOR PLAN
1:100

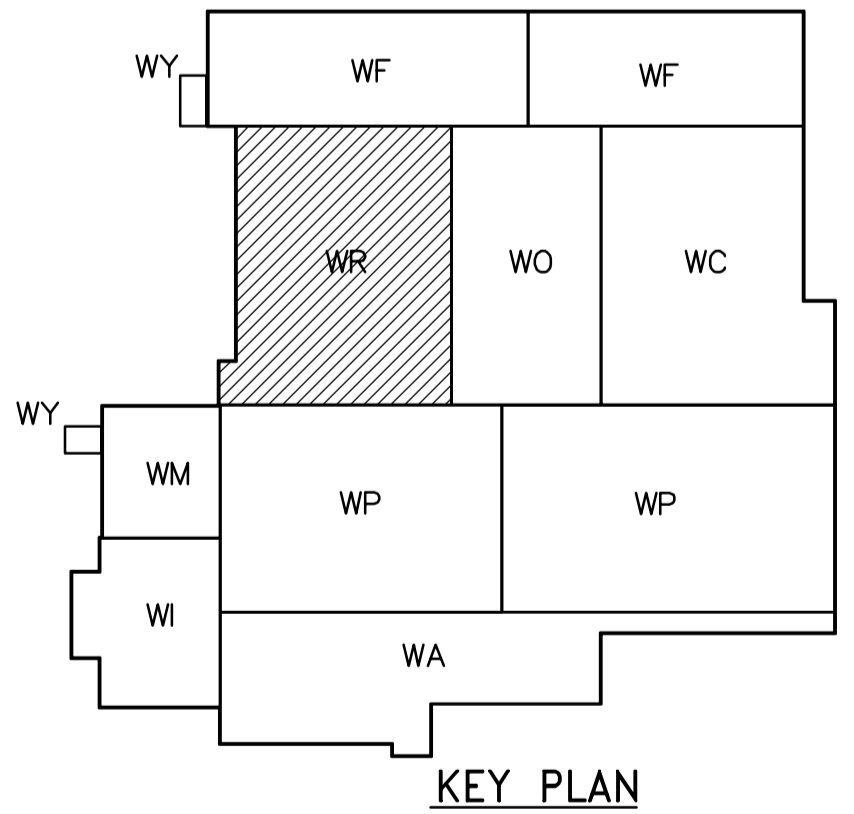

<p>Certificate of Authorization CH2M HILL Canada Ltd. No. 1441 Expiry: April 30, 2007</p>	<p>Frederickson Cooper ARCHITECTS</p>		<p>A You International Ltd. Company</p>		<p>ENGINEER'S SEAL</p> <p>ORIGINAL SIGNED BY D.K. CUDDINGTON 2006/03/29</p>		<p>THE CITY OF WINNIPEG WATER AND WASTE DEPARTMENT ENGINEERING DIVISION</p>	
	<p>DESIGNED BY TT CHECKED BY DL</p> <p>DRAWN BY AM APPROVED BY AHL</p> <p>SCALE: 1:100</p>		<p>RELEASED FOR CONSTRUCTION BY: R. SOROKOWSKI</p> <p>CONSULTANT DRAWING NO. WR-H0121</p>		<p>WATER TREATMENT PLANT RESIDUALS HANDLING MECHANICAL AND ELECTRICAL</p>		<p>CITY FILE NUMBER</p> <p>SHEET OF</p> <p>CITY DRAWING NUMBER</p> <p>1-0601R-A-H0121-001-01D</p>	
<p>B.M. ELEV.</p>		<p>01 742-2005 ADDENDUM 6 06/05/26 TT</p> <p>00 ISSUED FOR TENDER 06/03/29 TT</p> <p>NO. REVISIONS DATE BY</p>		<p>DATE 2005/07/04 DATE 2006/03/29</p>		<p>HVAC RESIDUALS HANDLING AREA SECOND FLOOR PLAN</p>		