



1 SERVICE TUNNEL PLAN
SA5.01 1:50

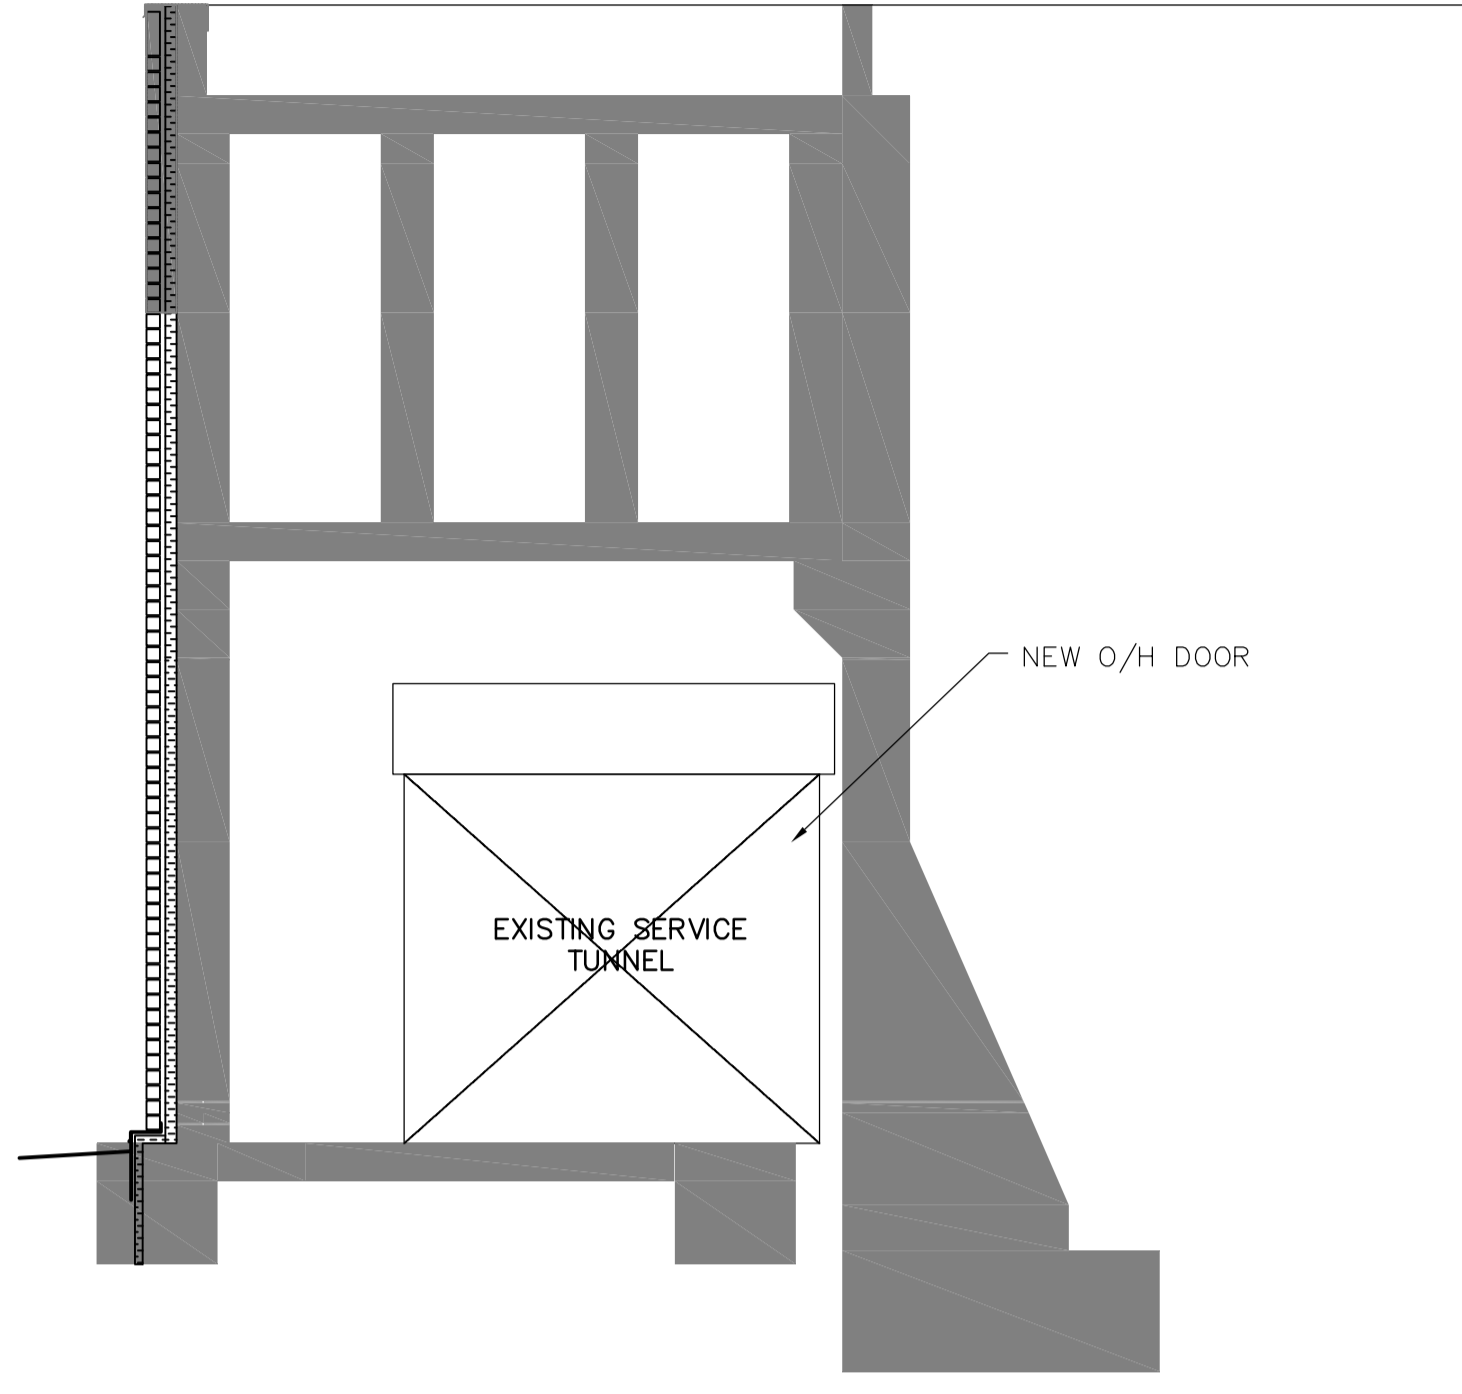

3 BUILDING SECTION
SA5.01 1:100

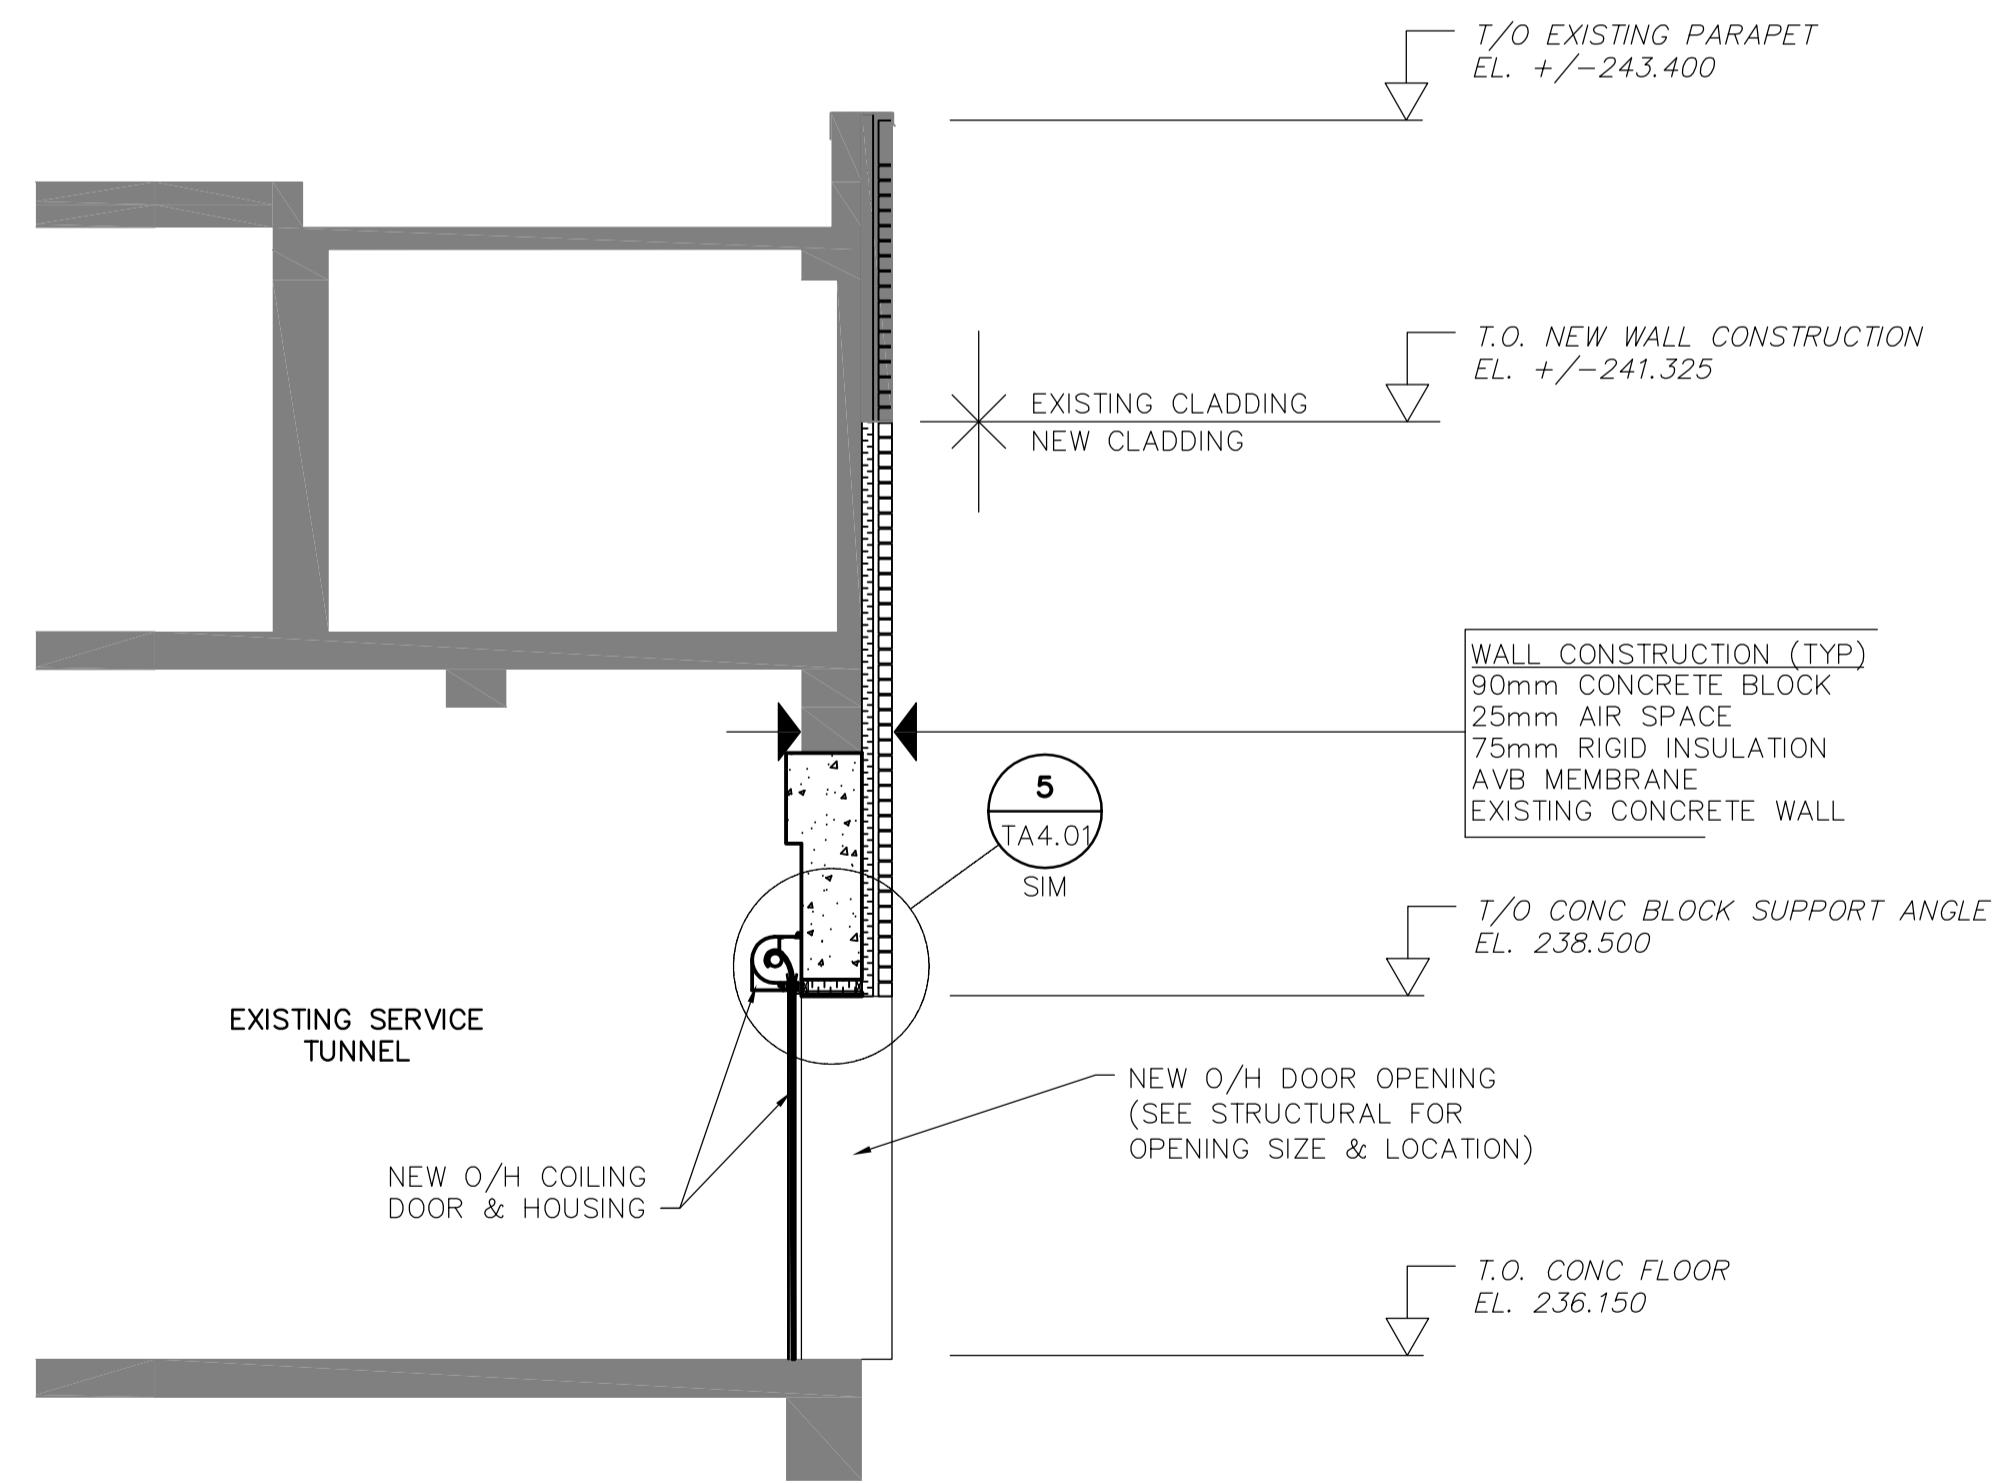

2 BUILDING SECTION
SA5.01 1:100

△ 01

DOOR SCHEDULE																
DOOR NO	DOOR							FRAME				HDW GROUP	FIRE RATING	GRILLES	COMMENTS	
	TO ROOM	SIZE	SWING	TYPE	MAT	CORE	FINISH	COLOUR	PROFILE	MAT	TYPE					FINISH
D101	SERVICE TUNNEL	45x2440x2440	O/H	1	METAL	INSUL	PREFIN	A	N/A	N/A	N/A	N/A	N/A	N/A	N/A	



B.M. ELEV.	<p>EarthTech A Tyco International Ltd. Company</p>	ORIGINAL SIGNED BY N. COOPER 2006/04/26	<p>THE CITY OF WINNIPEG WATER AND WASTE DEPARTMENT ENGINEERING DIVISION</p>
	DESIGNED BY: NC CHECKED BY: NC DRAWN BY: LK/AL APPROVED BY: JEH	CONSULTANT DRAWING NO. SA5.01	<p>WEWPC BIOLOGICAL NUTRIENT REMOVAL UPGRADE CONTRACT No. 3</p>
	HOR. SCALE: AS NOTED VERTICAL SCALE: AS NOTED RELEASED FOR CONSTRUCTION BY: J. VEILLEUX		ARCHITECTURAL AREA S - BIOREACTORS BUILDING SECTIONS
NO. REVISIONS DATE BY DATE	01 21-2006 ADDENDUM 06 06/06/30 LK 00 ISSUED FOR TENDER 06/04/26 LK	DATE 2006/02/24 DATE 2006/04/26	CITY FILE NUMBER SHEET 1 OF 2 CITY DRAWING NUMBER