


A
B
C
D
E
F
G

BLOWER BUILDING

2
M1.04

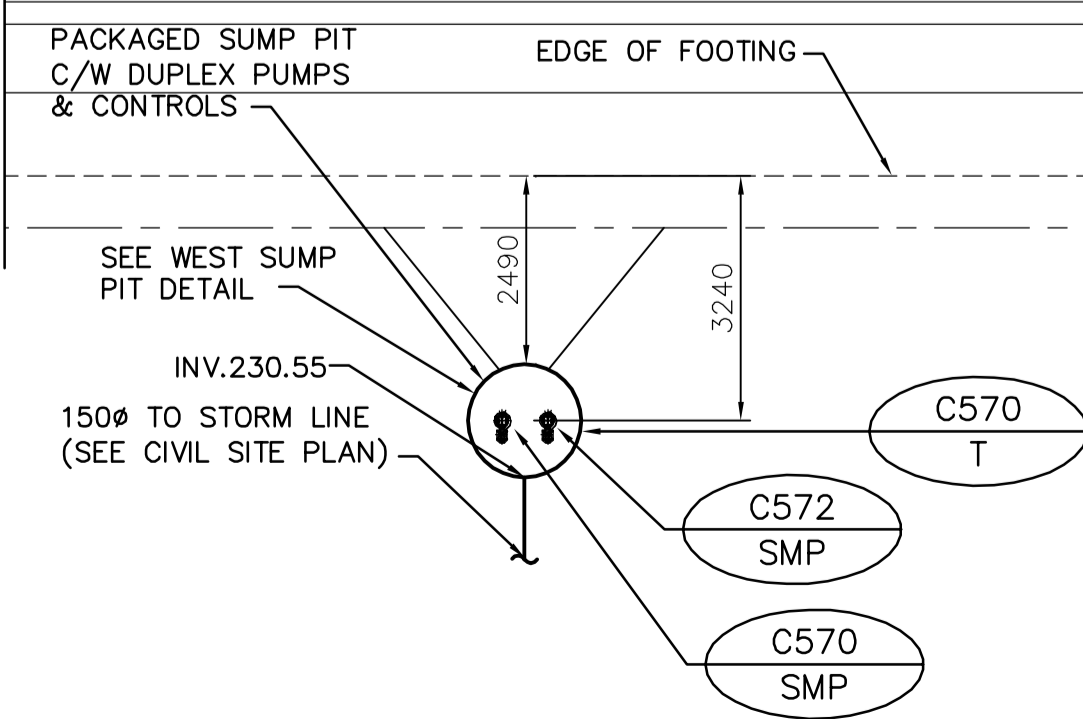

1 PARTIAL SBR BUILDING PLAN
M1.03 SCALE 1:100

APEGM
Certificate of Authorization
Earth Tech Canada Inc.
No. 730 Expiry: April 30, 2007

B.M. ELEV.			
DESIGNED BY	AB	CHECKED BY	AB
DRAWN BY	DJP	APPROVED BY	JEH
SCALE:	AS NOTED	RELEASED FOR CONSTRUCTION BY:	K. MARTENS
NO. REVISIONS	DATE	BY	DATE
01	291-2006 ADDENDUM 6	06/07/26	DJP
00	ISSUED FOR TENDER	06/05/15	DJP
2006/05/15		2006/05/15	

EarthTech
A Tyco International Ltd. Company

ENGINEER'S SEAL
ORIGINAL SIGNED BY
A. BURACHYNSKY
2006/05/15
CONSULTANT DRAWING NO.
M1.03

THE CITY OF WINNIPEG
WATER AND WASTE DEPARTMENT
ENGINEERING DIVISION

NEWPCC CENTRATE NUTRIENT TREATMENT
NITROGEN REMOVAL FACILITY

MECHANICAL
SBR BUILDING
PLUMBING AND HVAC PLAN

CITY FILE NUMBER
SHEET OF
CITY DRAWING NUMBER