


4-WEST ELEVATION
SCALE 1:75

3-SOUTH ELEVATION
SCALE 1:75

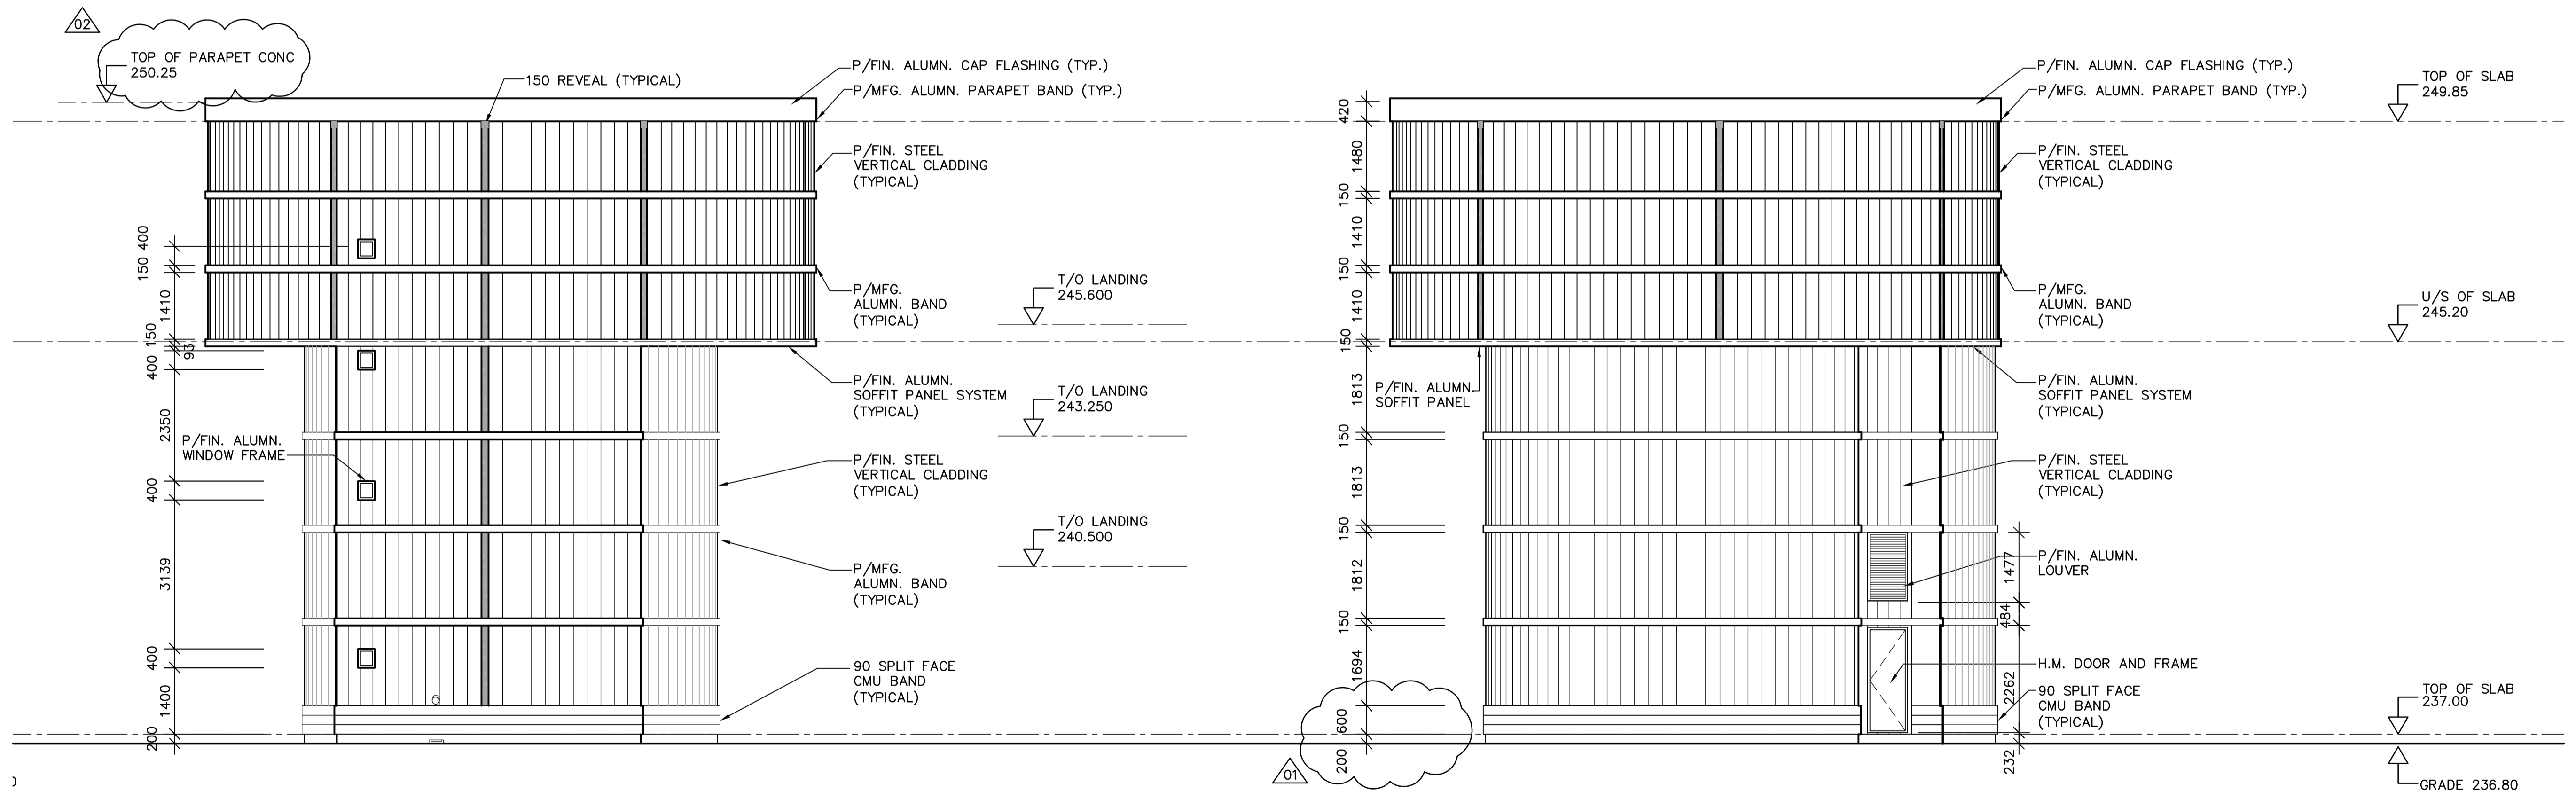

1-NORTH ELEVATION
SCALE 1:75

2-EAST ELEVATION
SCALE 1:75



NO.	REVISIONS	DATE	BY
02	37-2006 ADDENDUM 3	06/06/13	LK
01	37-2006 ADDENDUM 1	06/05/24	LK
00	ISSUED FOR TENDER	06/05/03	LK

 Frederickson Cooper ARCHITECTS		 A Tyco International Ltd. Company	
DESIGNED BY	TWS	CHECKED BY	TWS
DRAWN BY	SM	APPROVED BY	AHL
SCALE:	AS NOTED	RELEASED FOR CONSTRUCTION BY:	R. SOROKOWSKI
DATE	2006/04/21	DATE	2006/05/03

ENGINEER'S SEAL
ORIGINAL SIGNED BY
N. COOPER
2006/05/03
CONSULTANT DRAWING NO.
WB-B0300

THE CITY OF WINNIPEG
 WATER AND WASTE DEPARTMENT
 ENGINEERING DIVISION

WATER TREATMENT PLANT
 YARD PIPING AND VALVE CHAMBERS
 SURGE TOWER CONSTRUCTION

ARCHITECTURAL
 ELEVATIONS

CITY FILE NUMBER	
SHEET	OF
CITY DRAWING NUMBER	
1-0601Y-A-B0300-001-02D	