




4 ROOF/WALL SECTION DETAIL
WG-B0202 1:20

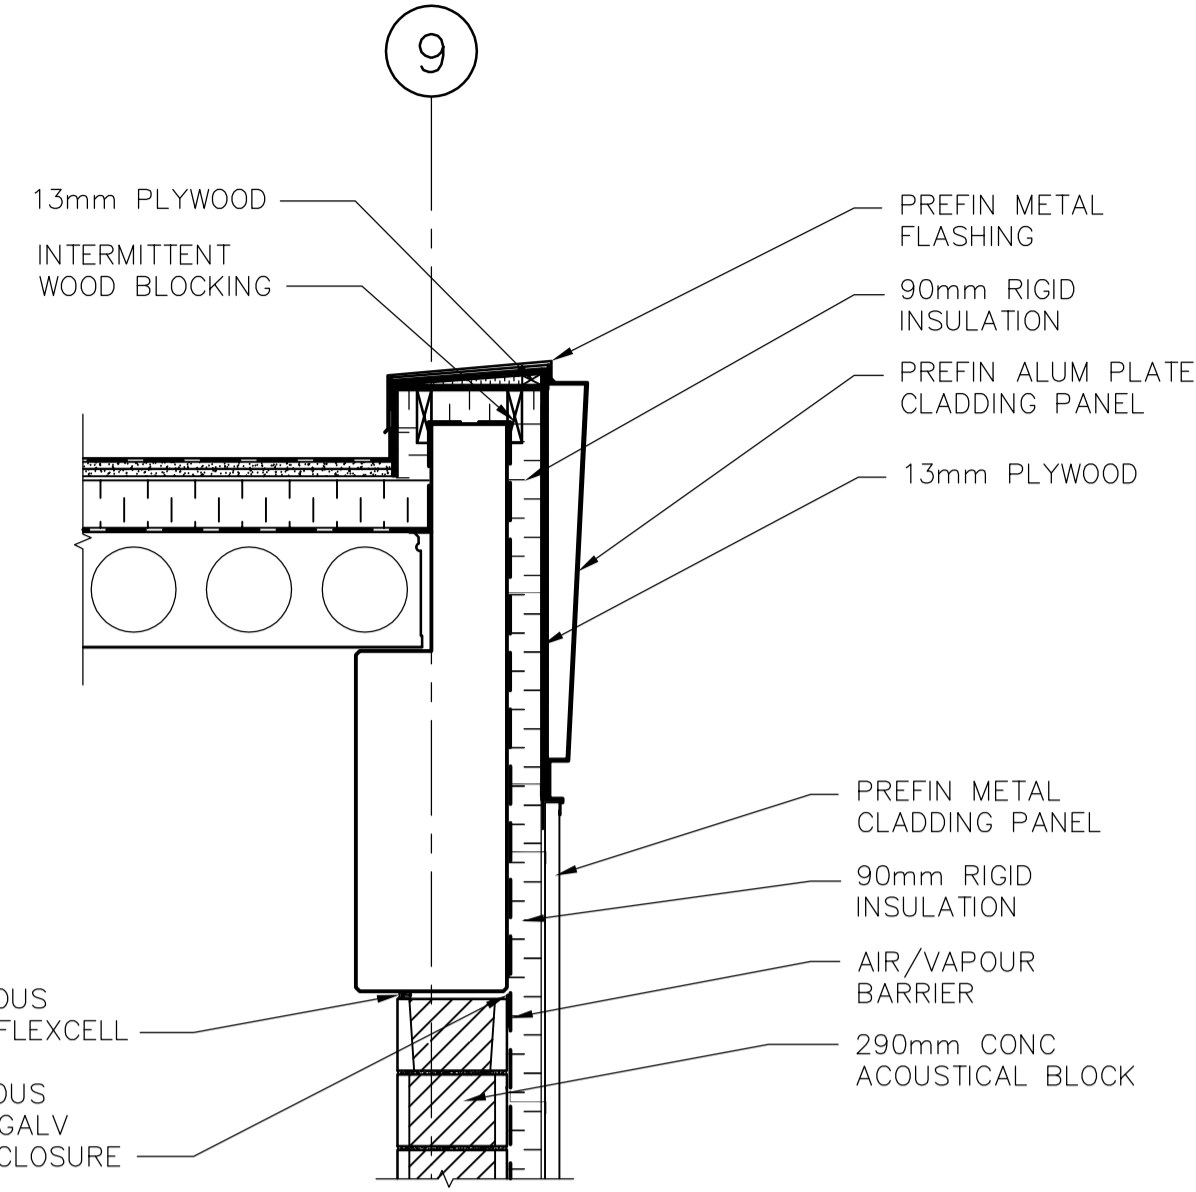


5 ROOF/WALL SECTION DETAIL
WG-B0202 1:20

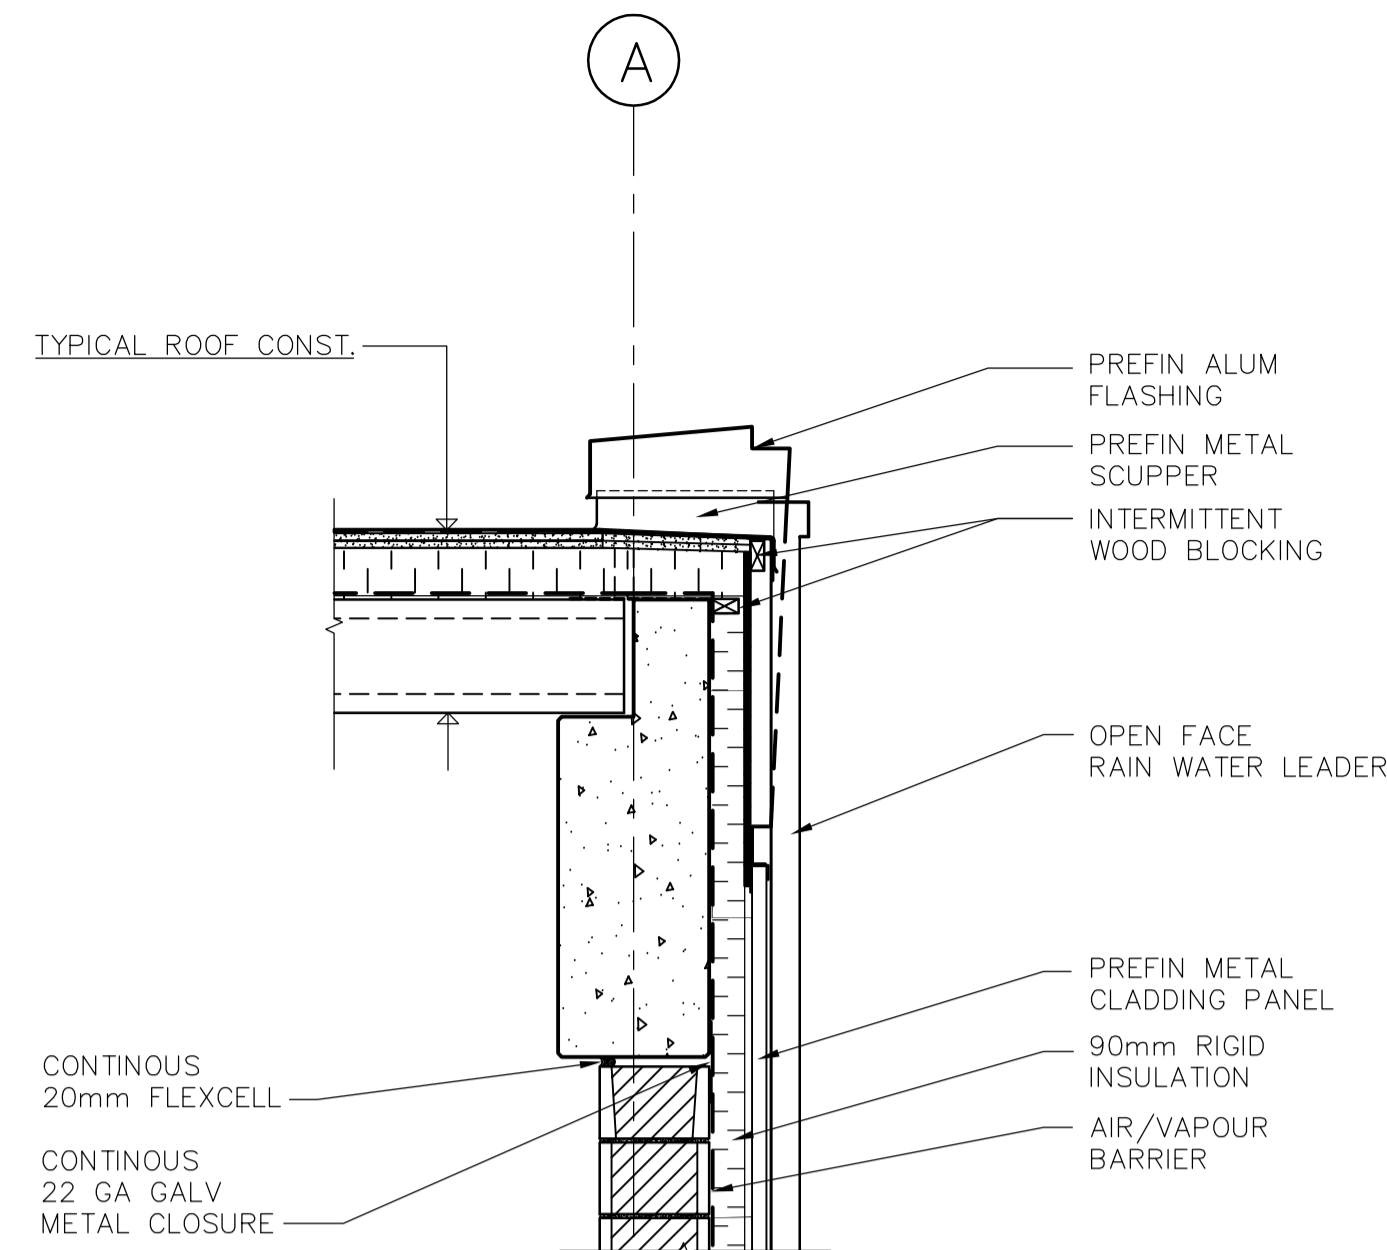


6 SCUPPER DETAIL
WG-B0140 1:20

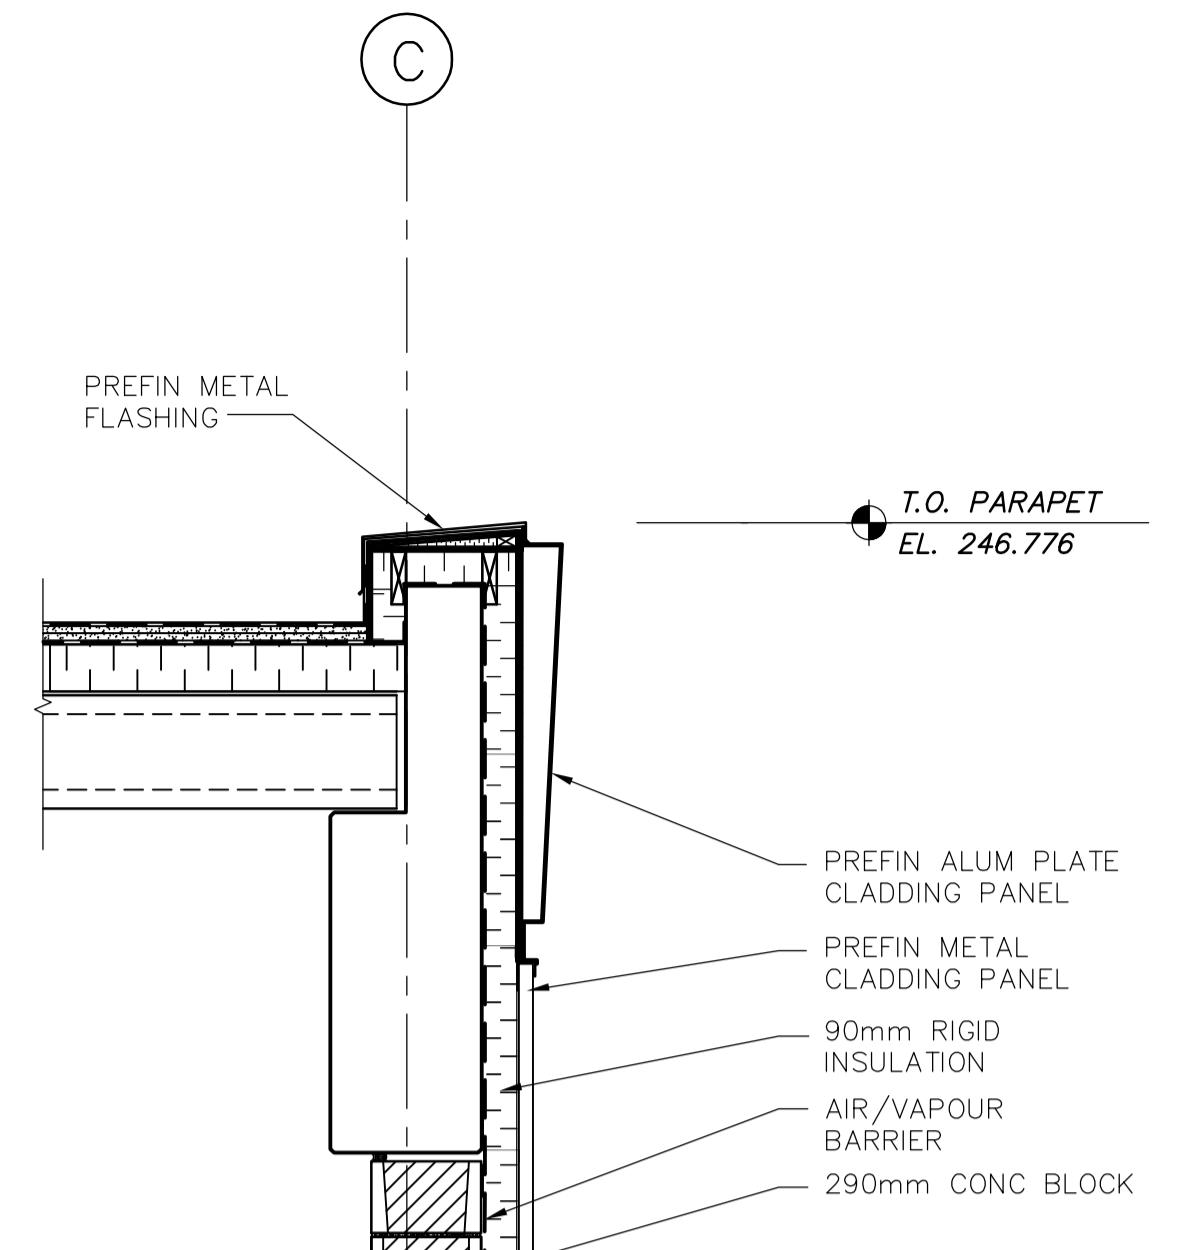


7 WALL SECTION DETAIL
WG-B0203 1:20

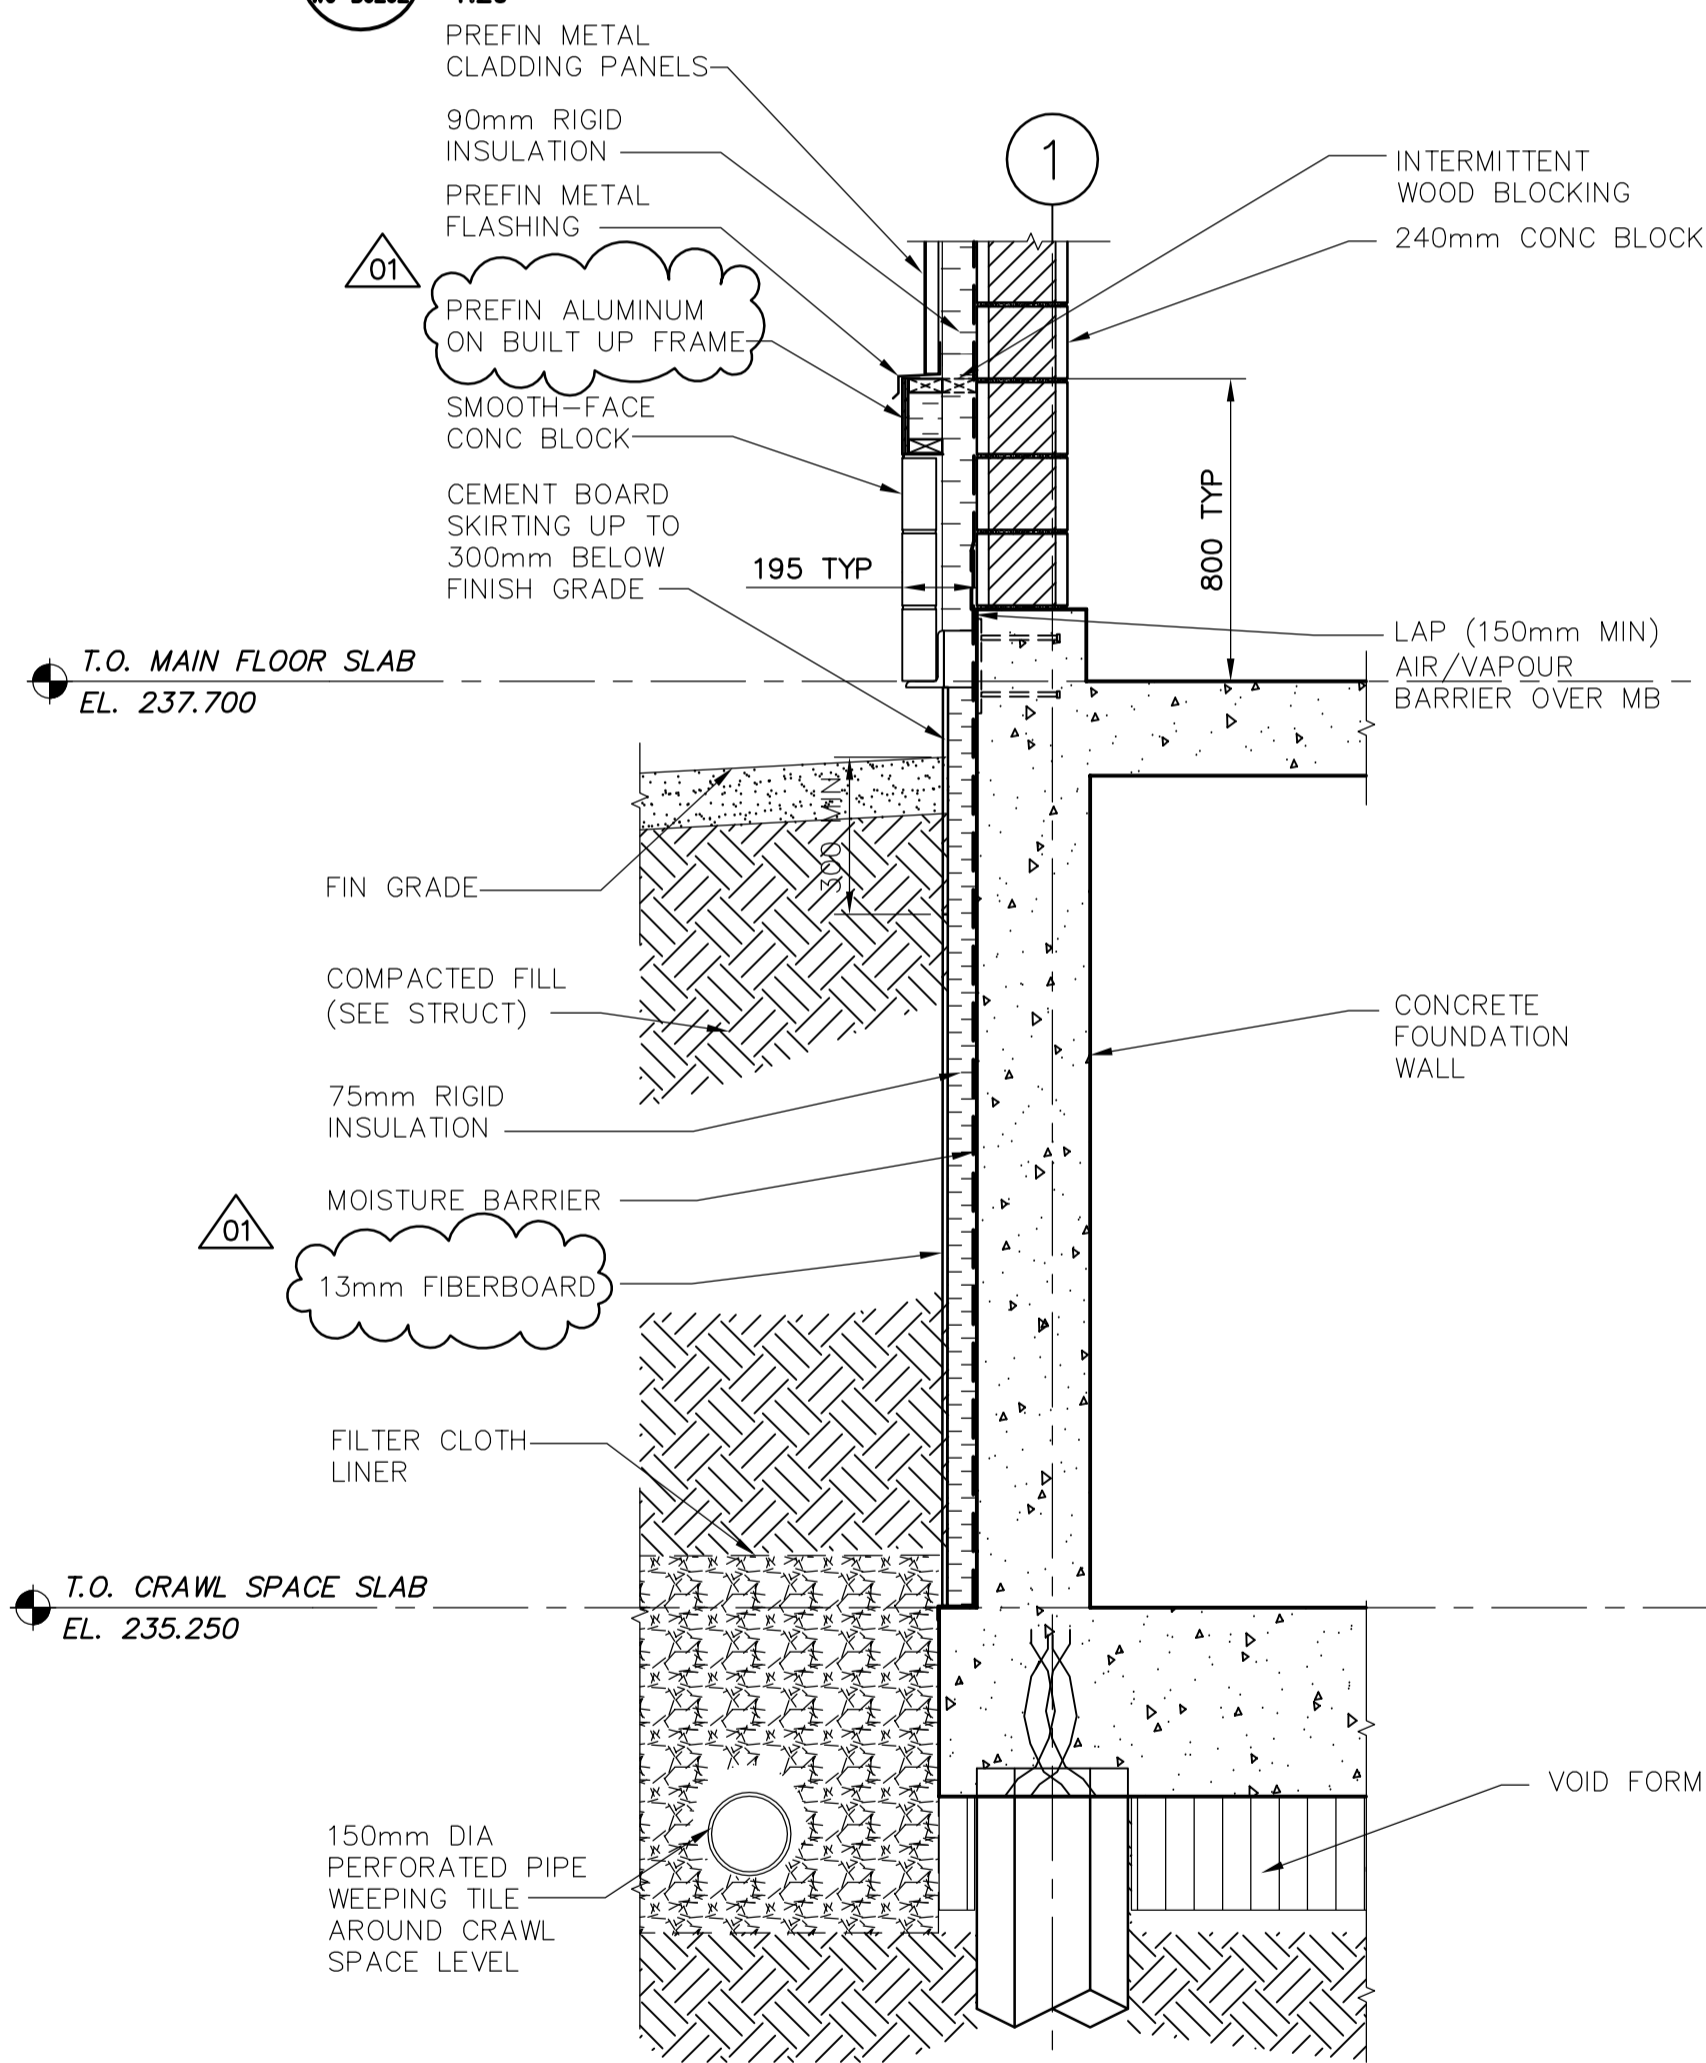


1 FOUNDATION WALL SECTION DETAIL
WG-B0202 1:20

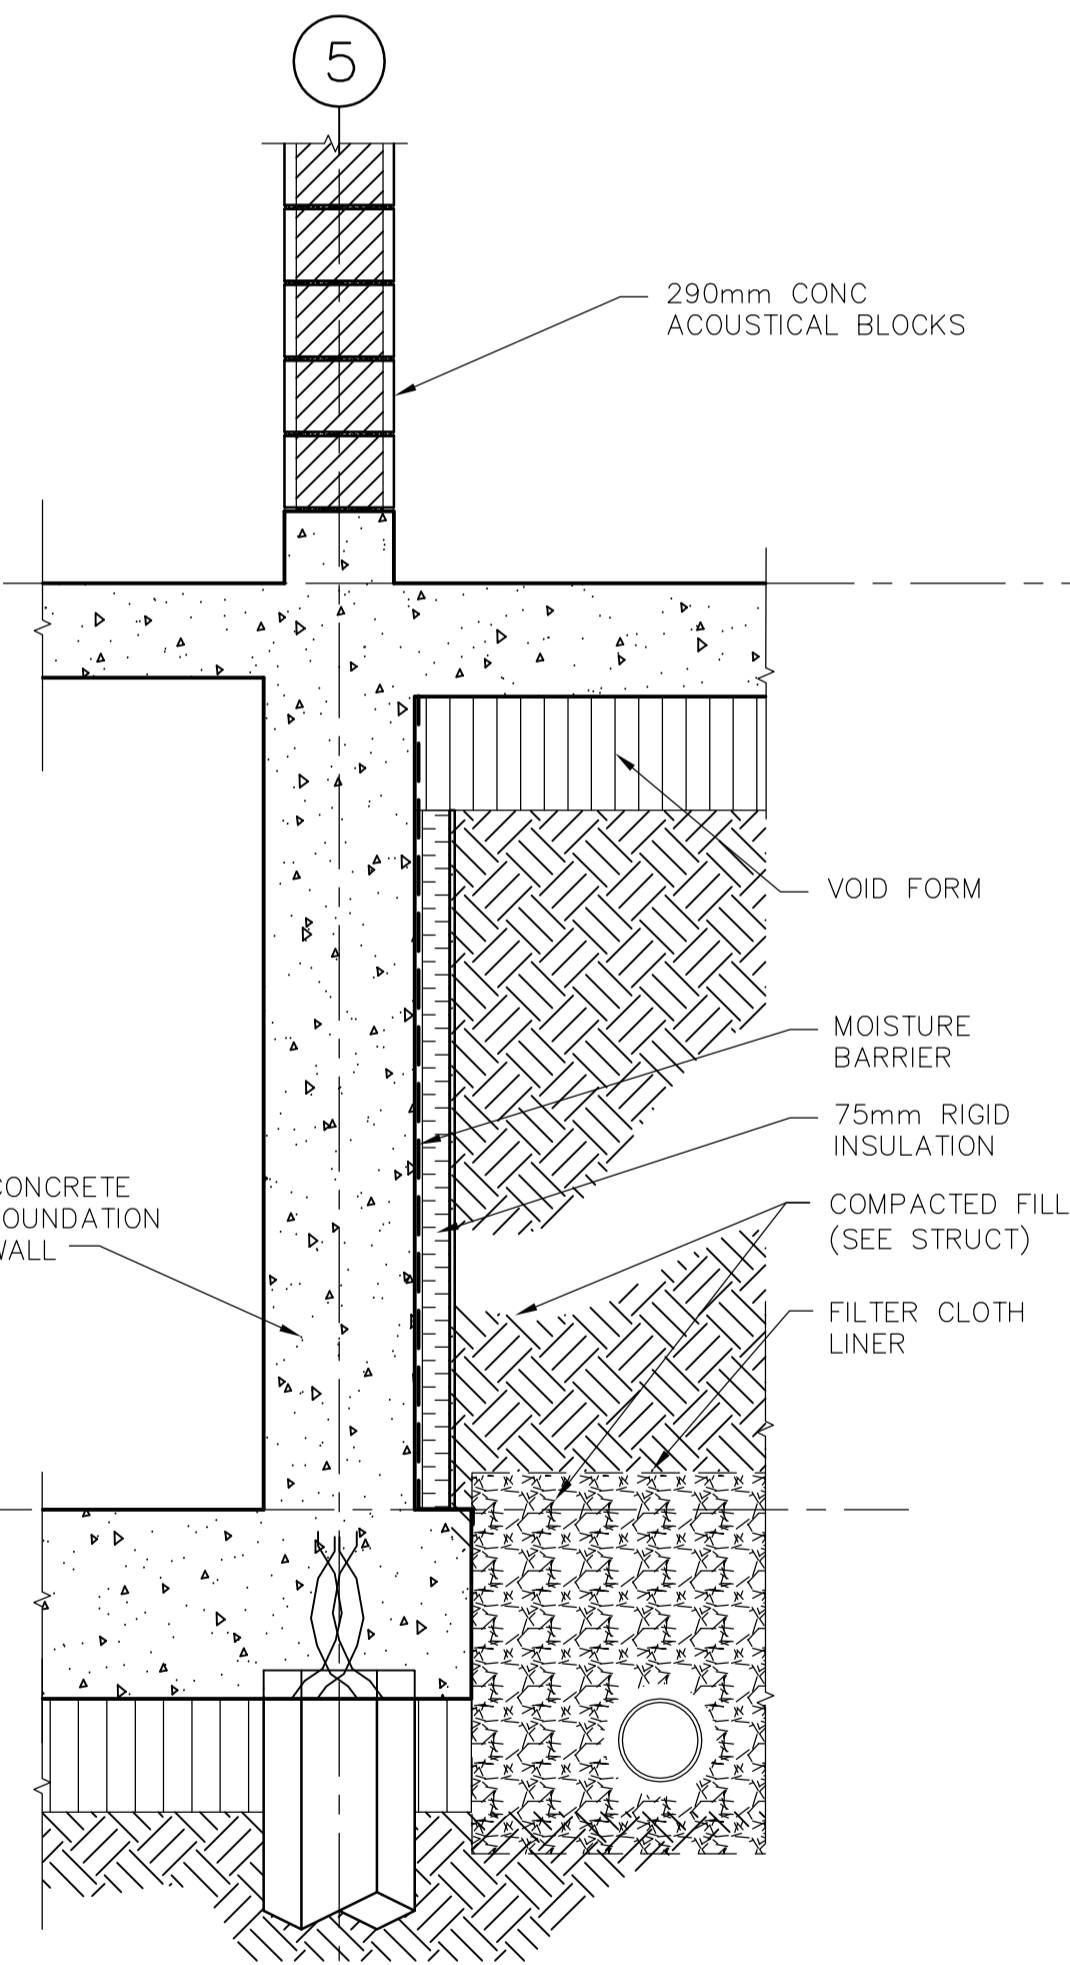

2 FOUNDATION WALL SECTION DETAIL
WG-B0202 1:20

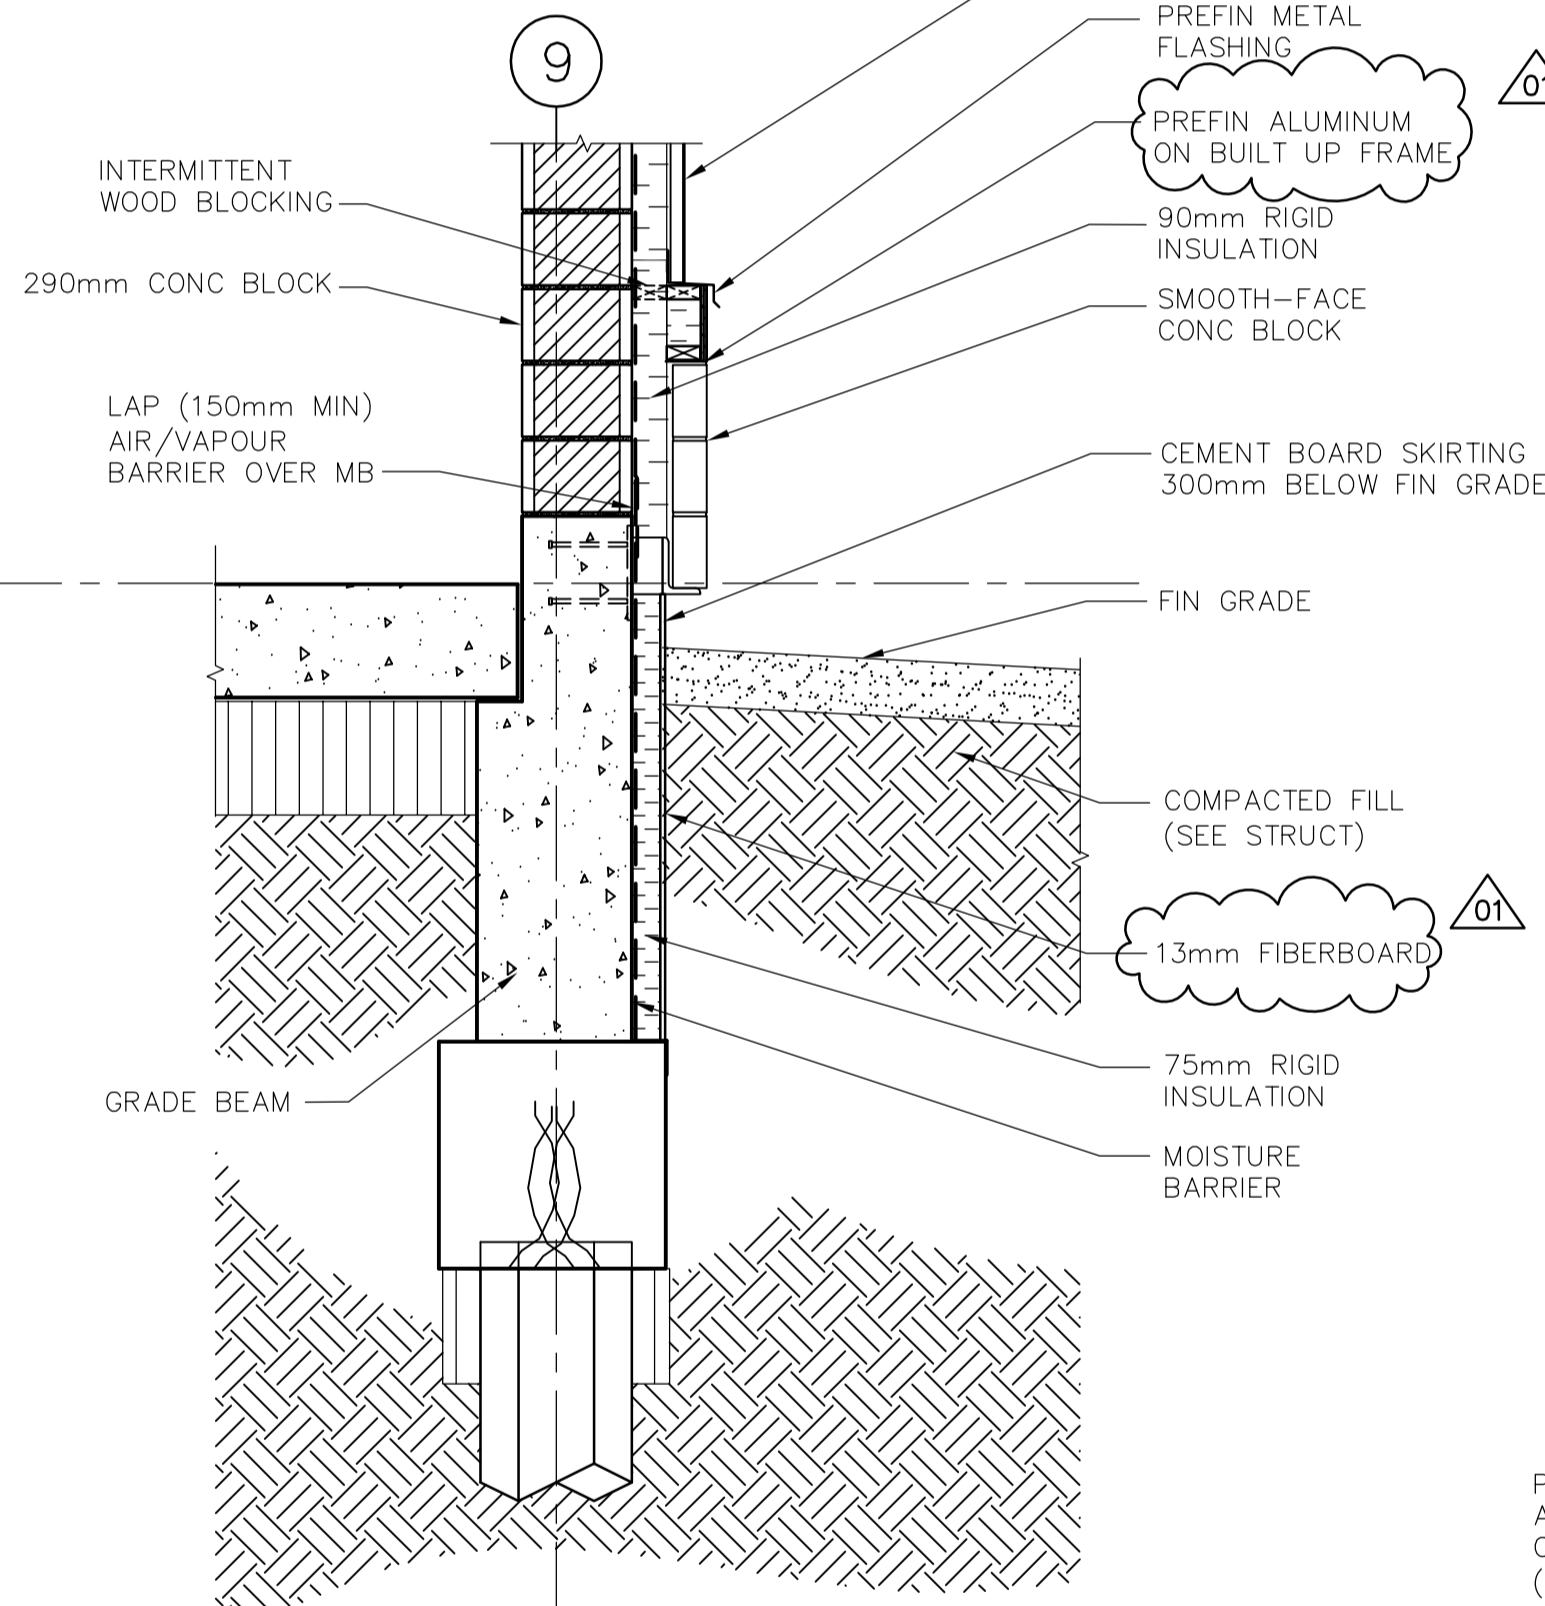

3 FOUNDATION WALL SECTION DETAIL
WG-B0202 1:20

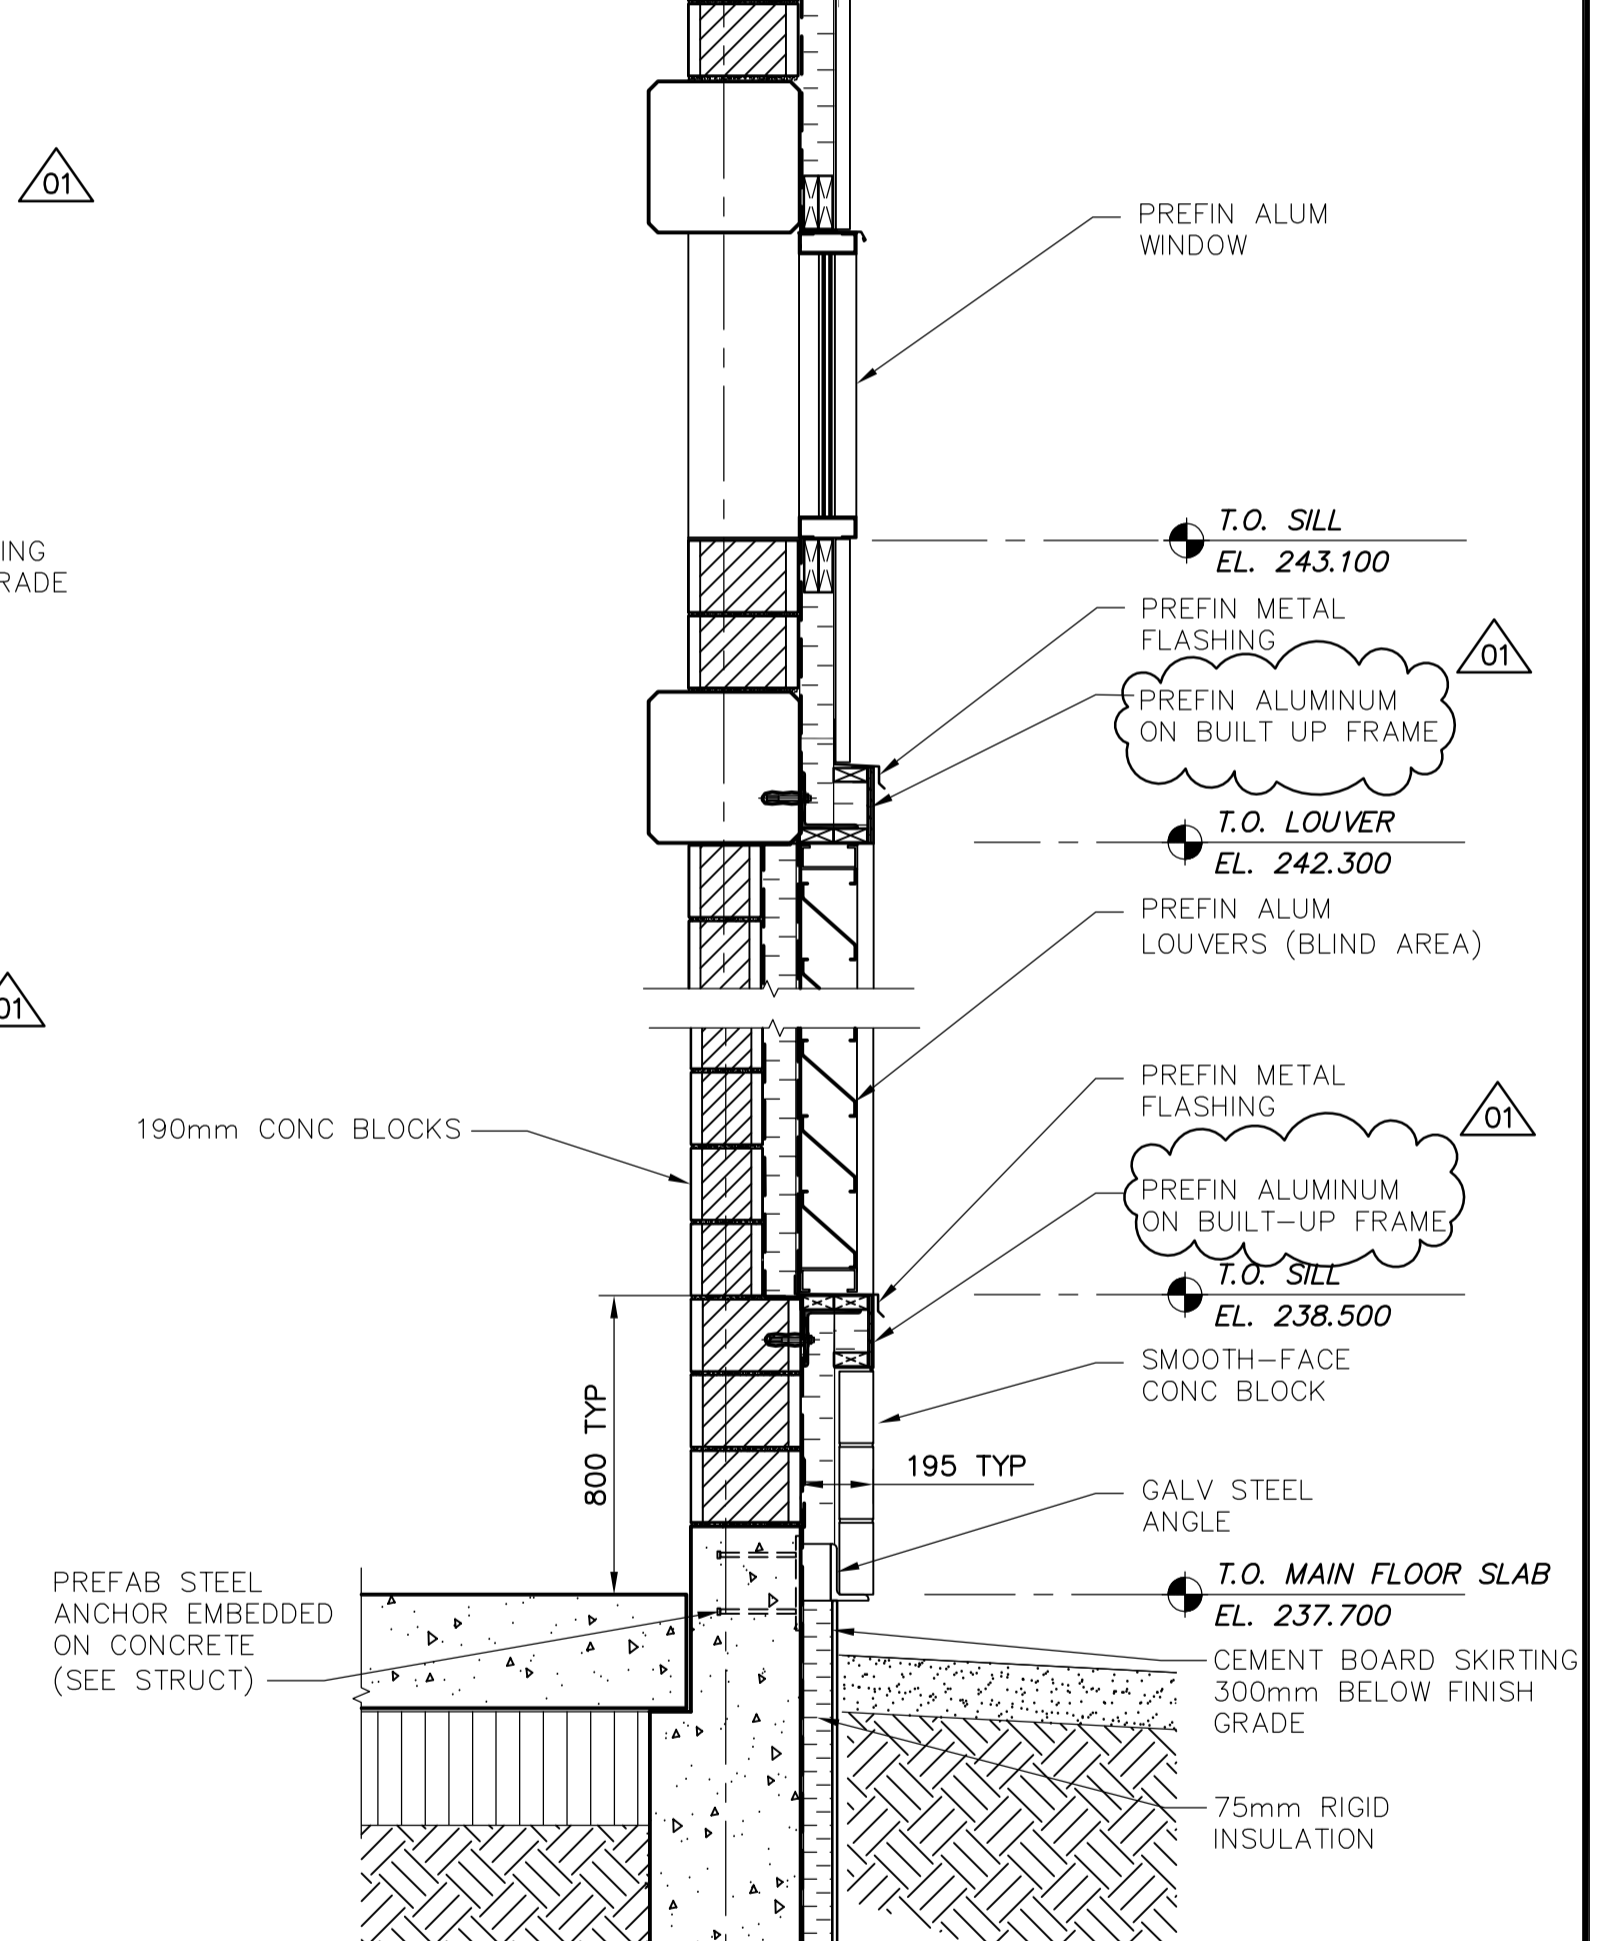

9 FOUNDATION WALL SECTION DETAIL
WG-B0202 1:20

B.M. ELEV.			
01	498-2006 ADDENDUM 10	06/10/24	AL
00	ISSUED FOR TENDER	06/08/28	AL
NO.	REVISIONS	DATE	BY

CH2MHILL
Frederickson Cooper
ARCHITECTS

EarthTech
A Type International Ltd. Company

DESIGNED BY	NC	CHECKED BY	LK
DRAWN BY	AL	APPROVED BY	AHL
SCALE:	AS SHOWN	RELEASED FOR CONSTRUCTION BY:	R. SOROKOWSKI
DATE	2006/06/01	DATE	2006/08/30

ENGINEER'S SEAL	
ORIGINAL SIGNED BY	N. COOPER
	2006/08/30
CONSULTANT DRAWING NO.	WG-B0401

THE CITY OF WINNIPEG
WATER AND WASTE DEPARTMENT
Winnipeg ENGINEERING DIVISION

WATER TREATMENT PLANT
STANDBY POWER GENERATOR

ARCHITECTURAL
WALL SECTION AND DETAILS

CITY FILE NUMBER
SHEET OF
CITY DRAWING NUMBER
1-0601G-A-B0401-001-01D