



**INLET BUILDING MAIN FLOOR POWER PLAN**  
1:50

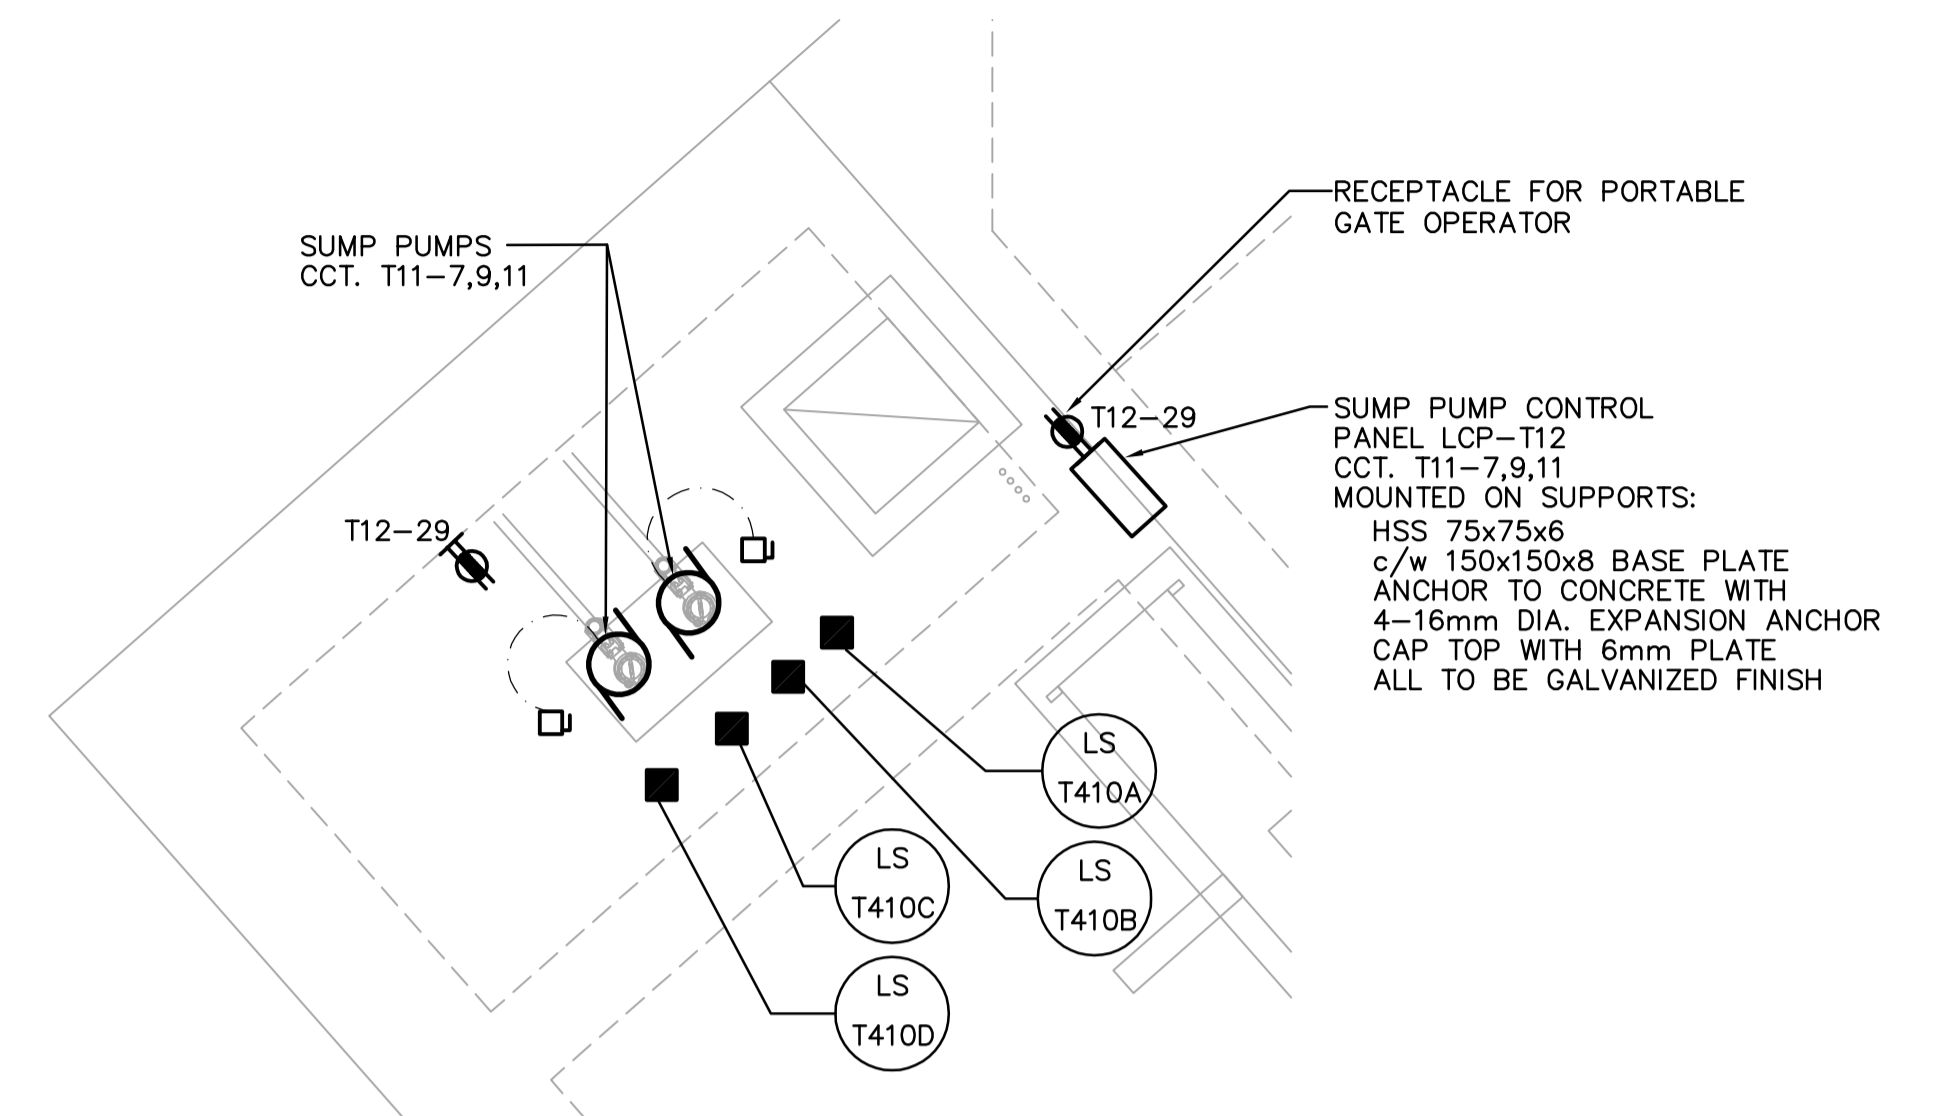

**SUMP PIT AREA POWER PLAN**  
1:50

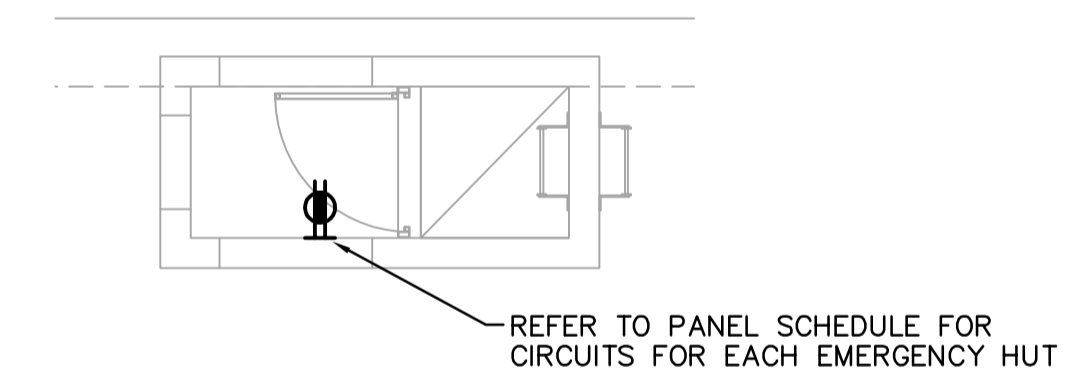

**EMERGENCY HUT POWER PLAN**  
1:50

<p>Certificate of Authorization Earth Tech Canada Inc. No. 730 Expiry: April 30, 2007</p>	<p>Frederickson Cooper ARCHITECTS</p>		<p>A Tyco International Ltd. Company</p>		<p>ENGINEER'S SEAL</p> <p>ORIGINAL SIGNED BY B.L. MOORE 2006/08/30</p>		<p>THE CITY OF WINNIPEG WATER AND WASTE DEPARTMENT ENGINEERING DIVISION</p>	
	<p>DESIGNED BY: BLM</p> <p>CHECKED BY: PS</p>		<p>DRAWN BY: ERC</p> <p>APPROVED BY: AHL</p>		<p>SCALE: 1:50</p> <p>RELEASED FOR CONSTRUCTION BY: R. SOROKOWSKI</p>		<p>CITY FILE NUMBER</p> <p>SHEET OF</p>	
	<p>NO. REVISIONS</p> <p>DATE BY</p>		<p>DATE</p>		<p>CONSULTANT DRAWING NO. WT-E0112</p>		<p>CITY DRAWING NUMBER 1-0601T-A-E0112-001-010</p>	
	<p>01 498-2006 ADDENDUM 3 06/09/29 ERC</p> <p>00 ISSUED FOR TENDER 06/08/30 ERC</p>		<p>DATE 2005/03/18</p> <p>DATE 2006/08/30</p>		<p>ELECTRICAL POWER AND FIRE ALARMS FLOOR PLANS</p>		<p>1-0601T-A-E0112-001-010</p>	