



CRAWLSPACE FLOOR PLAN
1:100

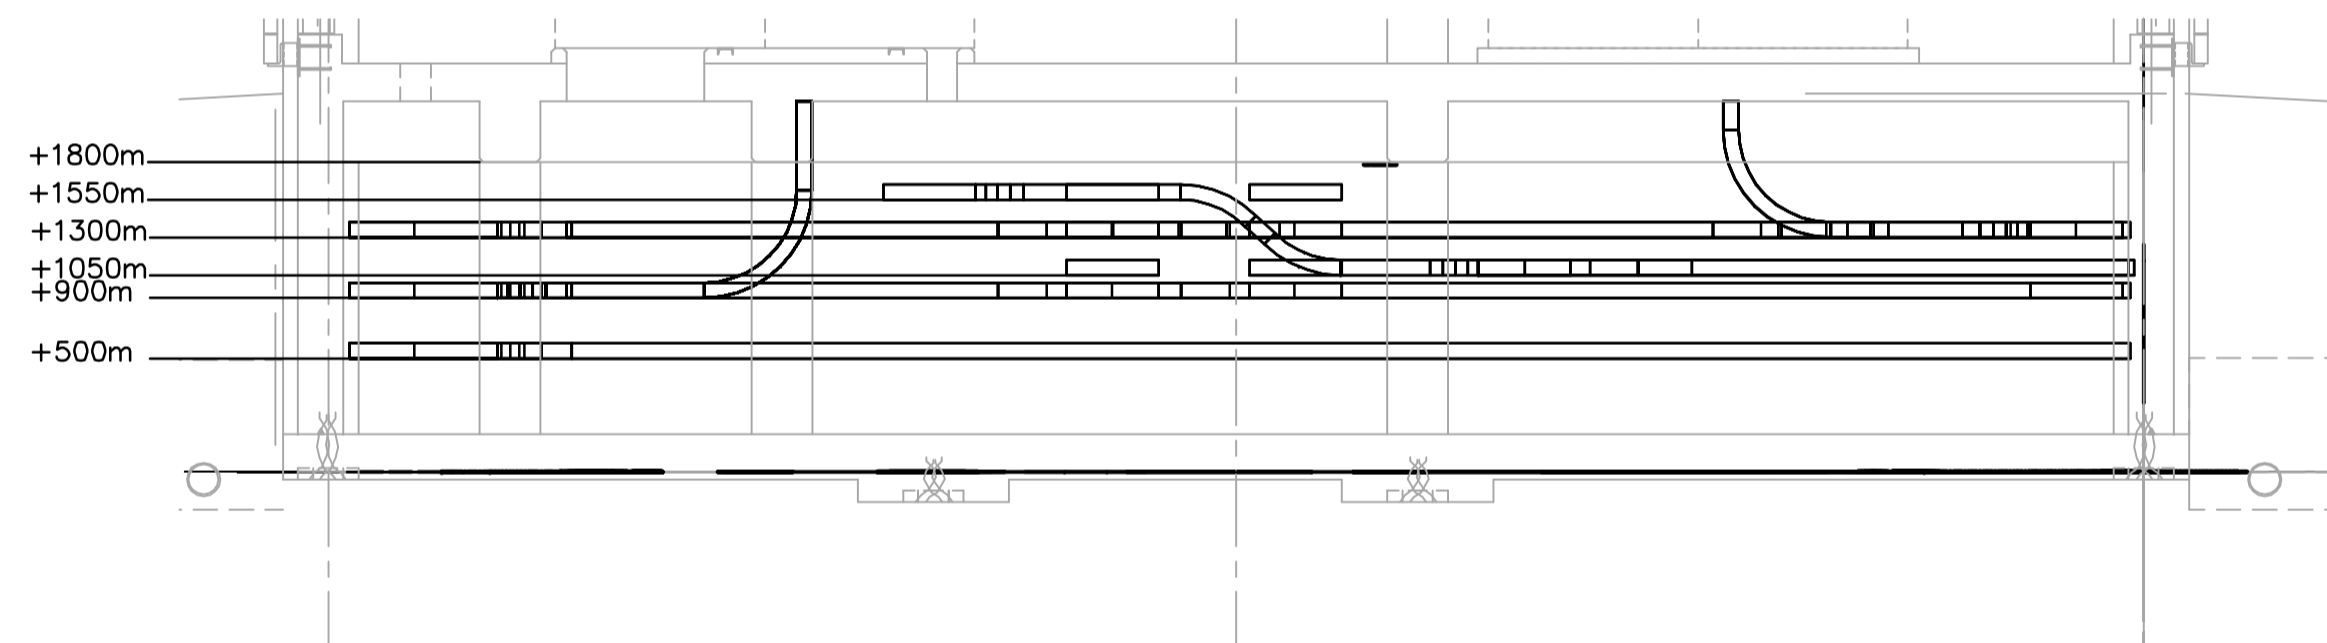

A SECTION
WG-E0102 1:50

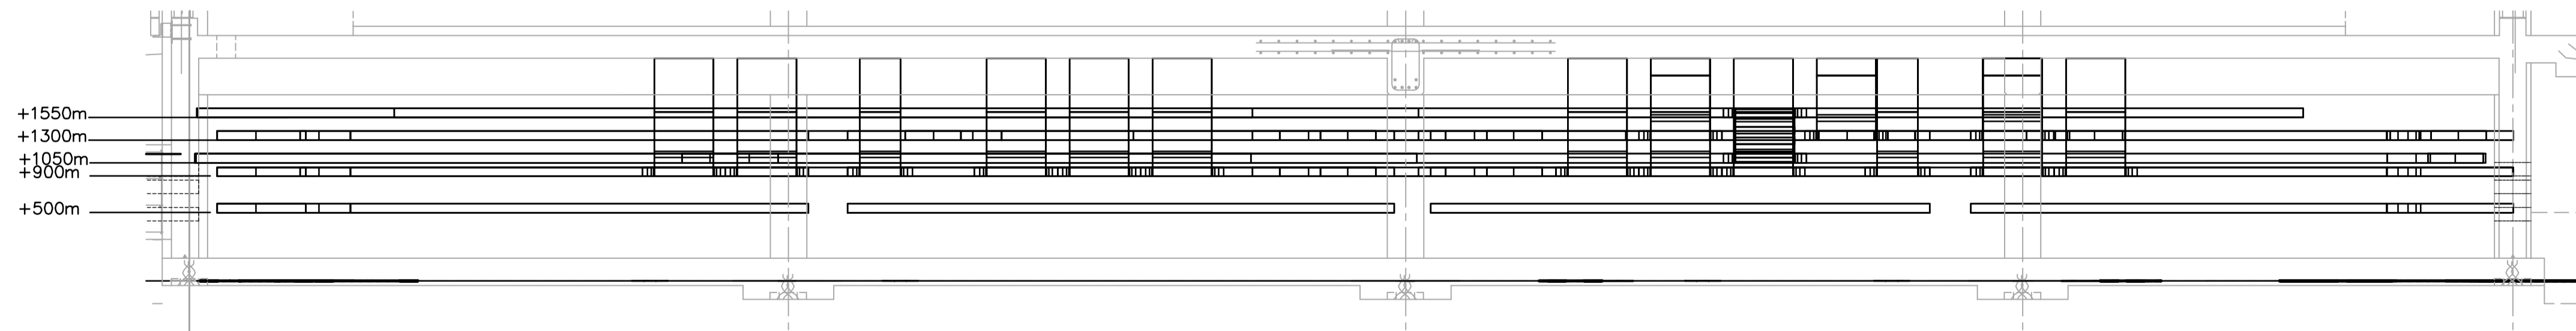

B SECTION
WG-E0102 1:50

DRAWING NOTES

① REFER TO SHOP DRAWINGS OF CITY SUPPLIED EQUIPMENT SPECIFIED IN D2 FOR CABLE REQUIREMENTS. TECK CABLES SHALL BE USED IN PLACE OF METALLIC CONDUITS.

APECM
Certificate of Authorization
Earth Tech Canada Inc.
No. 730 Expiry: April 30, 2007

NO.	REVISIONS	DATE	BY
02	498-2006 ADDENDUM 4	06/10/10	ERC
01	498-2006 ADDENDUM 3	06/09/29	ERC
00	ISSUED FOR TENDER	06/08/30	ERC

CH2M HILL Frederickson Cooper ARCHITECTS		EarthTech A Tech International Ltd. Company	
DESIGNED BY	BLM	CHECKED BY	PS
DRAWN BY	ERC	APPROVED BY	AHL
SCALE:	AS SHOWN	RELEASED FOR CONSTRUCTION BY:	R. SOROKOWSKI
DATE	2006/06/13	DATE	2006/08/30

ENGINEER'S SEAL
ORIGINAL SIGNED BY
B.L. MOORE
2006/08/30
CONSULTANT DRAWING NO.
WG-E0102

THE CITY OF WINNIPEG
WATER AND WASTE DEPARTMENT
ENGINEERING DIVISION

WATER TREATMENT PLANT
STANDBY POWER GENERATOR
GENERATOR BUILDING

ELECTRICAL
CRAWLSPACE POWER PLAN AND SECTIONS

CITY FILE NUMBER
SHEET OF
CITY DRAWING NUMBER
1-0601G-A-E0102-001-02D