


MAIN FLOOR PLAN
1:100

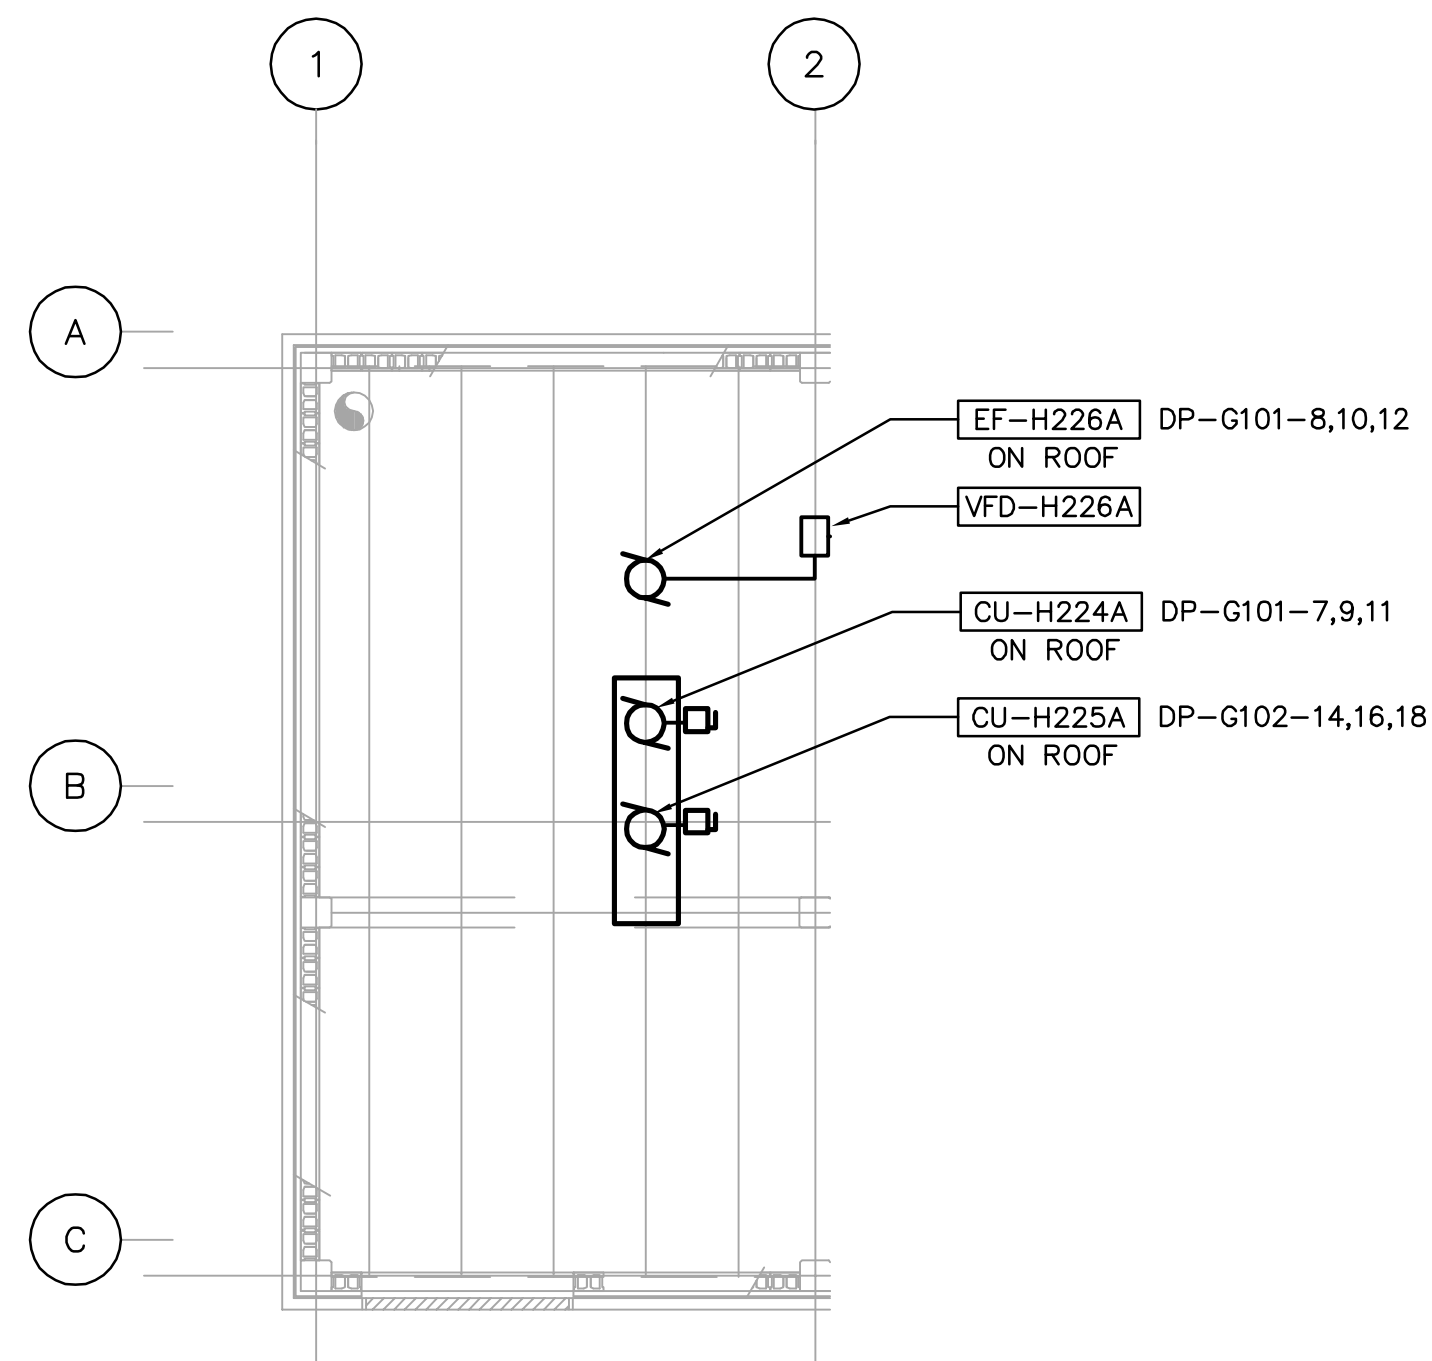

ROOF POWER PLAN
1:100

APECM
Certificate of Authorization
Earth Tech Canada Inc.
No. 730 Expiry: April 30, 2007

NO.	REVISIONS	DATE	BY
02	498-2006 ADDENDUM 4	06/10/10	ERC
01	498-2006 ADDENDUM 3	06/09/29	ERC
00	ISSUED FOR TENDER	06/08/30	ERC

 Frederickson Cooper ARCHITECTS		 A Tyco International Ltd. Company	
DESIGNED BY	BLM	CHECKED BY	PS
DRAWN BY	ERC	APPROVED BY	AHL
SCALE:	NTS	RELEASED FOR CONSTRUCTION BY:	R. SOROKOWSKI
DATE	2005/10/03	DATE	2006/08/30

ENGINEER'S SEAL
ORIGINAL SIGNED BY
B.L. MOORE
2006/08/30
CONSULTANT DRAWING NO.
WG-E0112

THE CITY OF WINNIPEG
WATER AND WASTE DEPARTMENT
ENGINEERING DIVISION

WATER TREATMENT PLANT
STANDBY POWER GENERATOR
GENERATOR BUILDING

ELECTRICAL
MAIN FLOOR POWER PLAN

CITY FILE NUMBER
SHEET OF
CITY DRAWING NUMBER
1-0601G-A-E0112-001-02D