


MAIN FLOOR PLAN
1:100

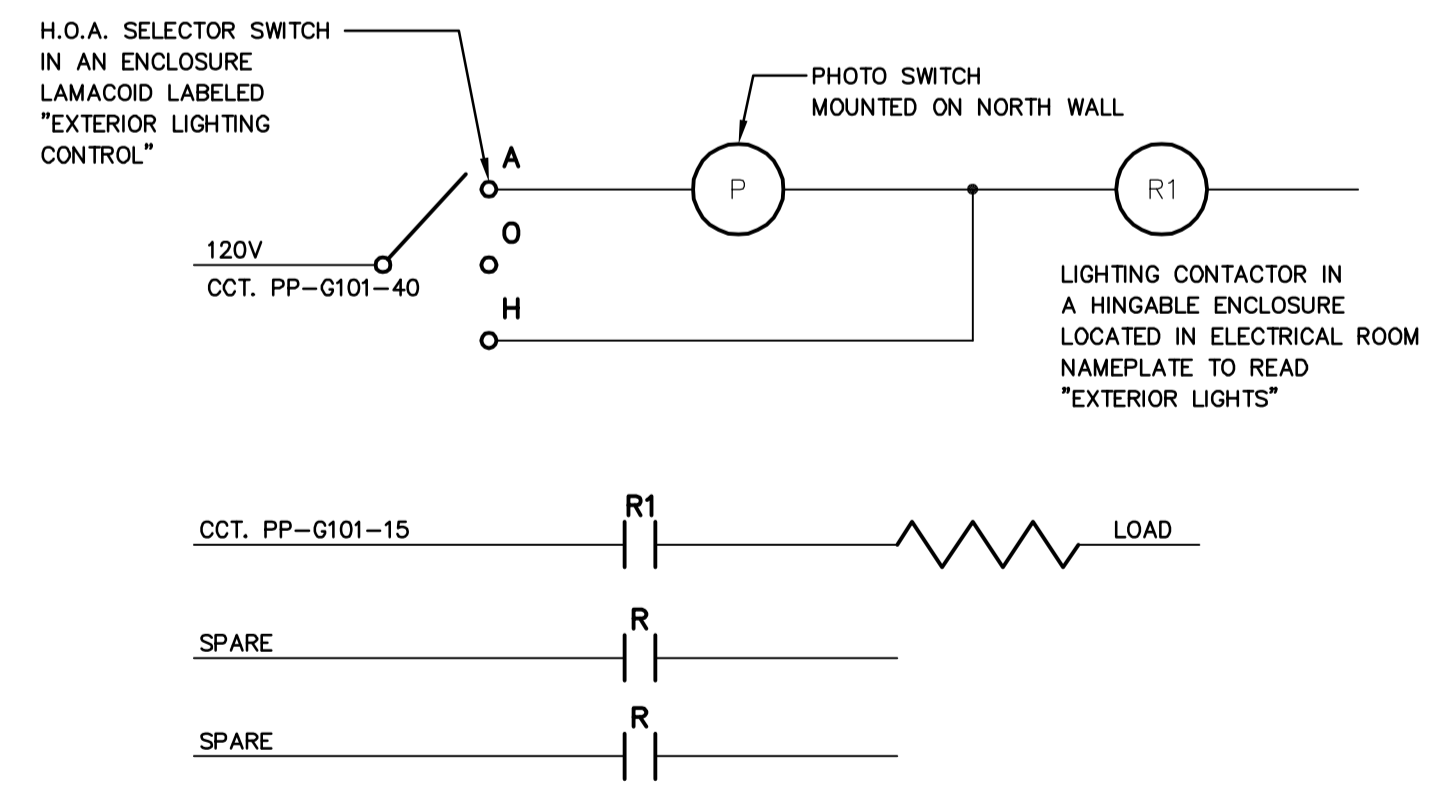

1 **DETAIL - EXTERIOR LIGHTING CONTROL**
WG-E0111 NTS

DRAWING NOTES	
1	COORDINATE LUMINAIRE CONNECTIONS WITH MECHANICAL PIPING AND DUCTWORK. WHERE REQUIRED SUSPEND LUMINAIRES BELOW SUCH EQUIPMENT.
2	PROVIDE LIGHTING CONTACTORS FOR ELECTRICAL ROOM AND GENERATOR ROOM SWITCHING.

GENERAL NOTES	
1.	COORDINATE WITH OTHER TRADES TO PREVENT CONFLICTS.
2.	USE PVC JACKETED TECK CABLE FOR ALL POWER WIRING.
3.	ALL CONDUIT TO BE 21mmØ MINIMUM UNLESS OTHERWISE NOTED.

APECM
Certificate of Authorization
Earth Tech Canada Inc.
No. 730 Expiry: April 30, 2007

NO.	REVISIONS	DATE	BY
01	498-2006 ADDENDUM 6	06/10/13	ERC
00	ISSUED FOR TENDER	06/08/30	ERC

CH2MHILL
Frederickson Cooper
ARCHITECTS

EarthTech
A Tyco International Ltd. Company

DESIGNED BY	BLM	CHECKED BY	PS
DRAWN BY	ERC	APPROVED BY	AHL
SCALE:	NTS		
RELEASED FOR CONSTRUCTION BY:	R. SOROKOWSKI		
DATE	2005/10/03	DATE	2006/08/30

ENGINEER'S SEAL
ORIGINAL SIGNED BY
B.L. MOORE
2006/08/30
CONSULTANT DRAWING NO.
WG-E0111

THE CITY OF WINNIPEG
WATER AND WASTE DEPARTMENT
ENGINEERING DIVISION

WATER TREATMENT PLANT
STANDBY POWER GENERATOR
GENERATOR BUILDING

ELECTRICAL
MAIN FLOOR LIGHTING PLAN

CITY FILE NUMBER
SHEET OF
CITY DRAWING NUMBER
1-0601G-A-E0111-001-01D