


1 FLOOR PLAN
1:25

PANEL SCHEDULE									
Panel PP-Y14									
DESCRIPTION	LOAD	BKR	CCT	A	B	CCT	BKR	LOAD	DESCRIPTION
Lighting - Interior		15	1	*	2	15	1		Receptacle
Lighting - Exterior		15	3	*	4	15	1		Receptacle - Pump
Spare		15	5	*	6	15	15		Spare
Spare		15	7	*	8	15	15		Spare
Space			9	*	10	15			Space
Space			11	*	12	20			Space
Space			13	*	14	30			Space
Space			15	*	16	20			Space

Voltage:	120V/1Ø/2 wire	Feeder:	2/C#8 Teck
Mains:	225A	Main Breaker:	N/A
Location:	Valve Chamber Building	Power Source:	Transformer XFMR-PP-Y14
Mounting:	Surface		

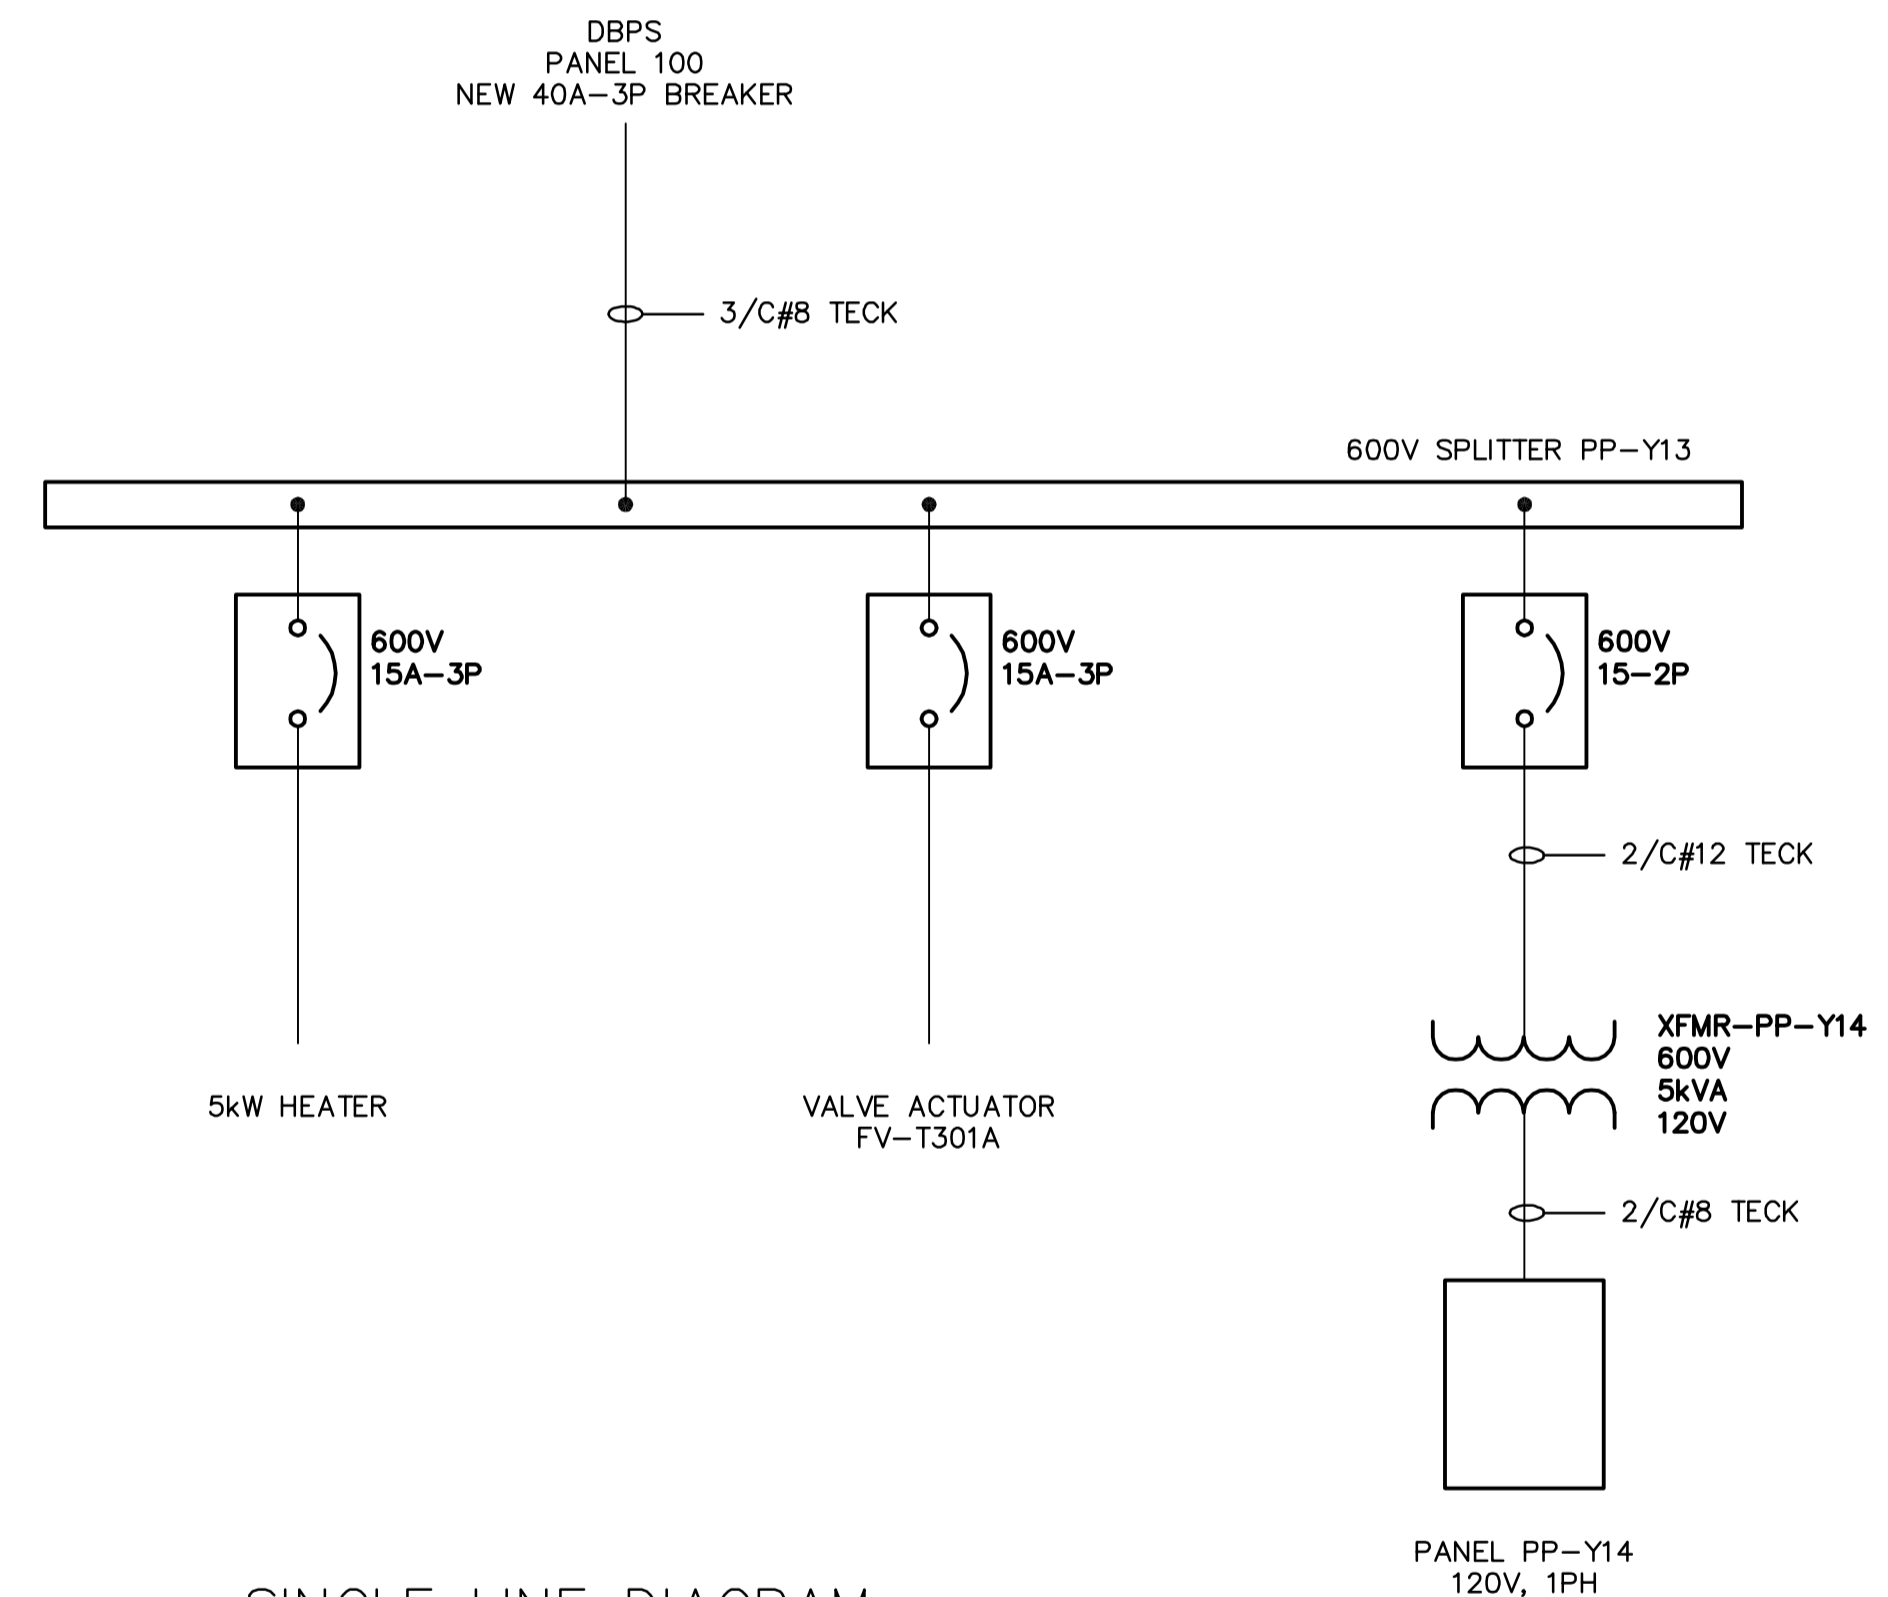

SINGLE LINE DIAGRAM
SCALE: NTS

 Certificate of Authorization Earth Tech Canada Inc. No. 730 Expiry: April 30, 2007	B.M. ELEV.	 Frederickson Cooper ARCHITECTS DESIGNED BY BLM CHECKED BY BLM DRAWN BY ERC APPROVED BY AHL SCALE: AS NOTED RELEASED FOR CONSTRUCTION BY: R. SOROKOWSKI DATE 2006/06/01 DATE 2006/08/30	ENGINEER'S SEAL ORIGINAL SIGNED BY B.L. MOORE 2006/08/30 CONSULTANT DRAWING NO. WY-E0121	 THE CITY OF WINNIPEG WATER AND WASTE DEPARTMENT ENGINEERING DIVISION WATER TREATMENT PLANT YARD PIPING AND VALVE CHAMBERS VALVE CHAMBERS ELECTRICAL POWER AND LIGHTING	CITY FILE NUMBER
					SHEET OF
					CITY DRAWING NUMBER
					1-0601Y-A-E0121-001-01D