


MAIN FLOOR PLAN
1:100

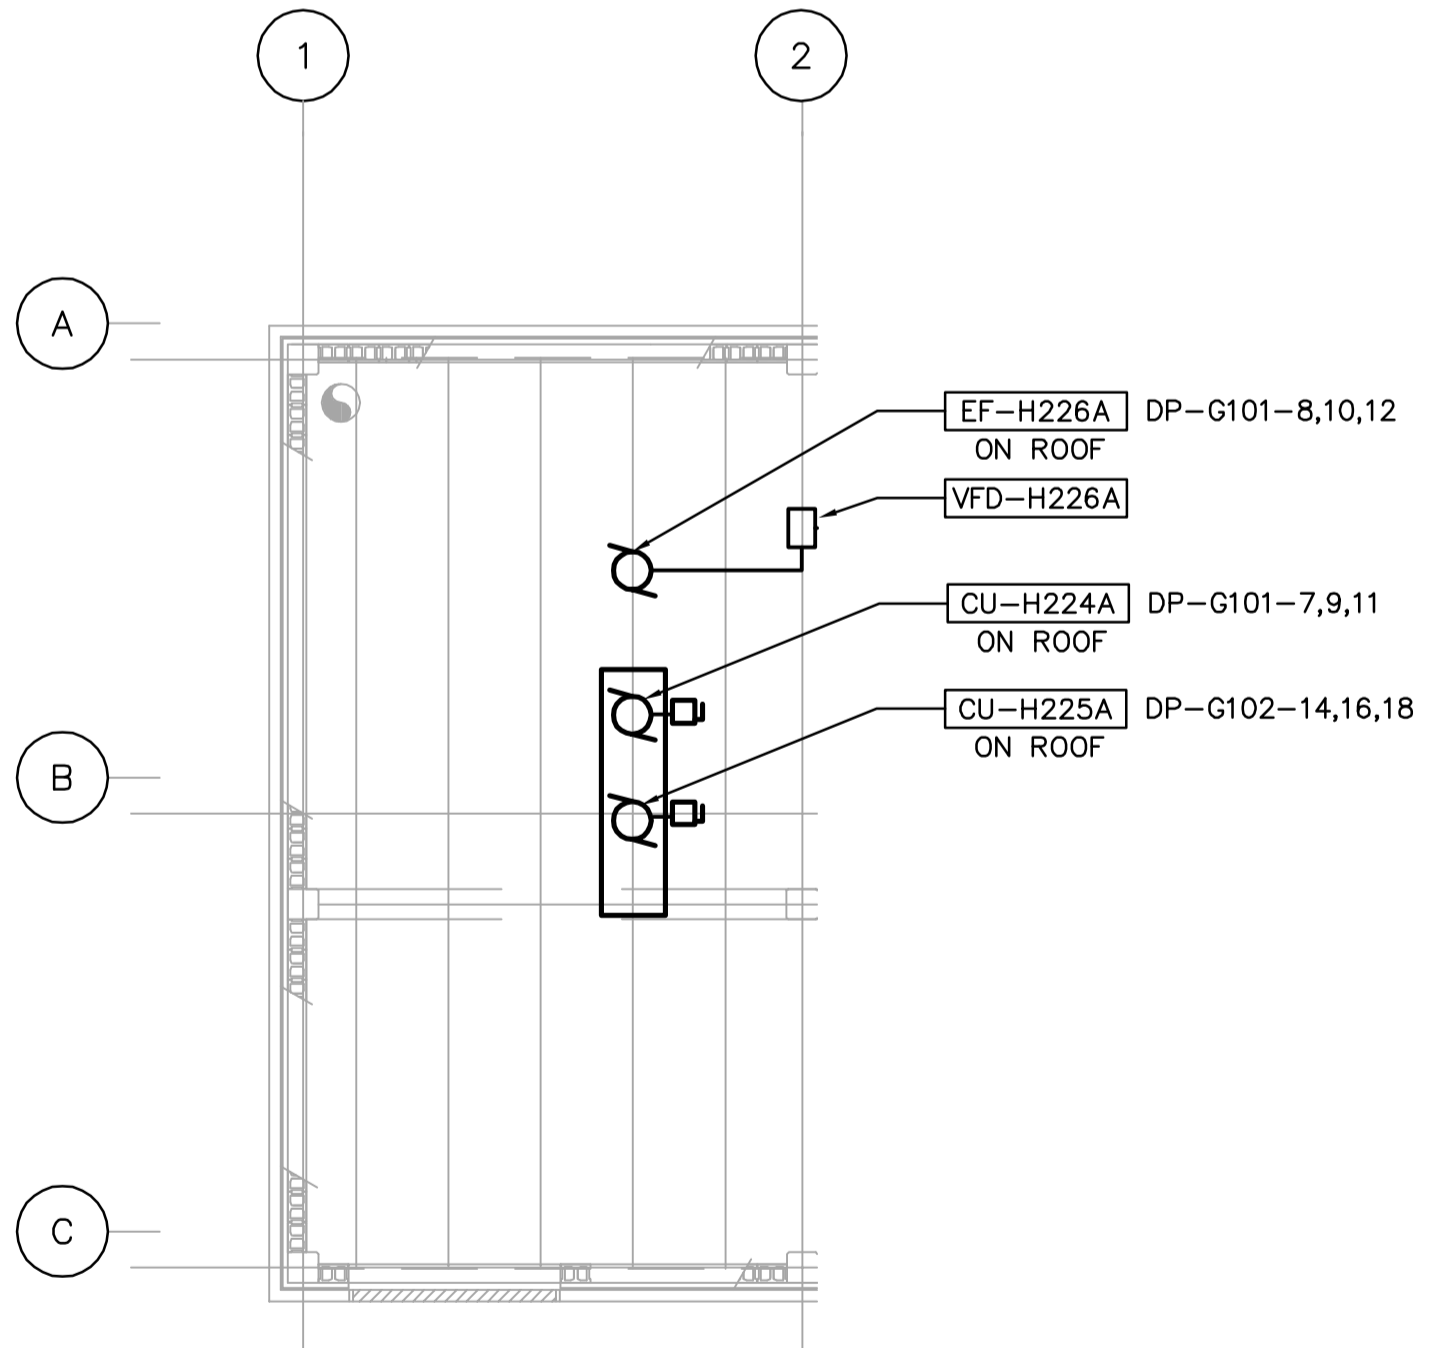

ROOF POWER PLAN
1:100

APECM
Certificate of Authorization
Earth Tech Canada Inc.
No. 730 Expiry: April 30, 2007

NO.	REVISIONS	DATE	BY
03	498-2006 ADDENDUM 7	06/10/19	ERC
02	498-2006 ADDENDUM 4	06/10/10	ERC
01	498-2006 ADDENDUM 3	06/09/29	ERC
00	ISSUED FOR TENDER	06/08/30	ERC

CH2M HILL
Frederickson Cooper
ARCHITECTS

EarthTech
A Tyco International Ltd. Company

DESIGNED BY	BLM	CHECKED BY	PS
DRAWN BY	ERC	APPROVED BY	AHL
SCALE:	NTS		
RELEASED FOR CONSTRUCTION BY:	R. SOROKOWSKI		
DATE	2005/10/03	DATE	2006/08/30

ENGINEER'S SEAL
ORIGINAL SIGNED BY
B.L. MOORE
2006/08/30
CONSULTANT DRAWING NO.
WG-E0112

THE CITY OF WINNIPEG
WATER AND WASTE DEPARTMENT
ENGINEERING DIVISION

WATER TREATMENT PLANT
STANDBY POWER GENERATOR
GENERATOR BUILDING

ELECTRICAL
MAIN FLOOR POWER PLAN

CITY FILE NUMBER	
SHEET	OF
CITY DRAWING NUMBER	1-0601G-A-E0112-001-03D