



INLET BUILDING MAIN FLOOR POWER PLAN
1:50

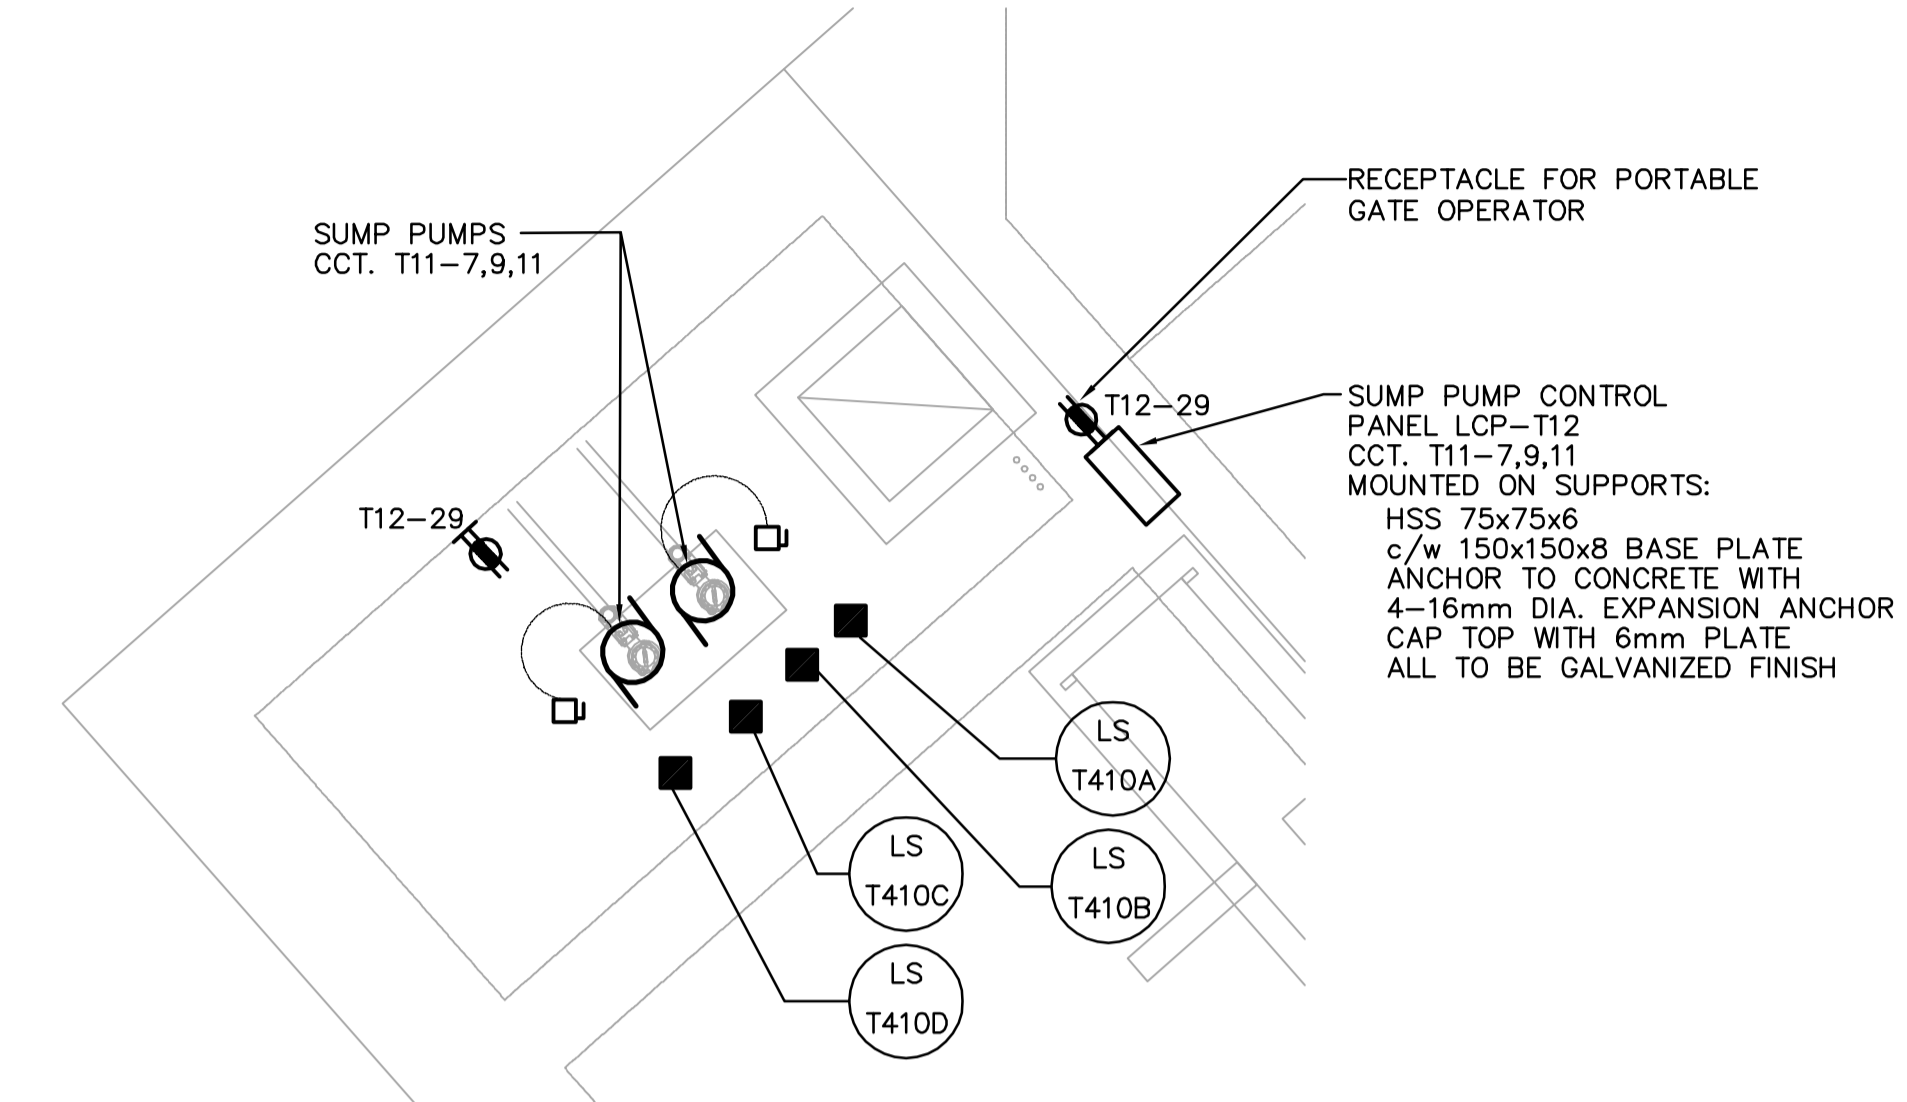

SUMP PIT AREA POWER PLAN
1:50

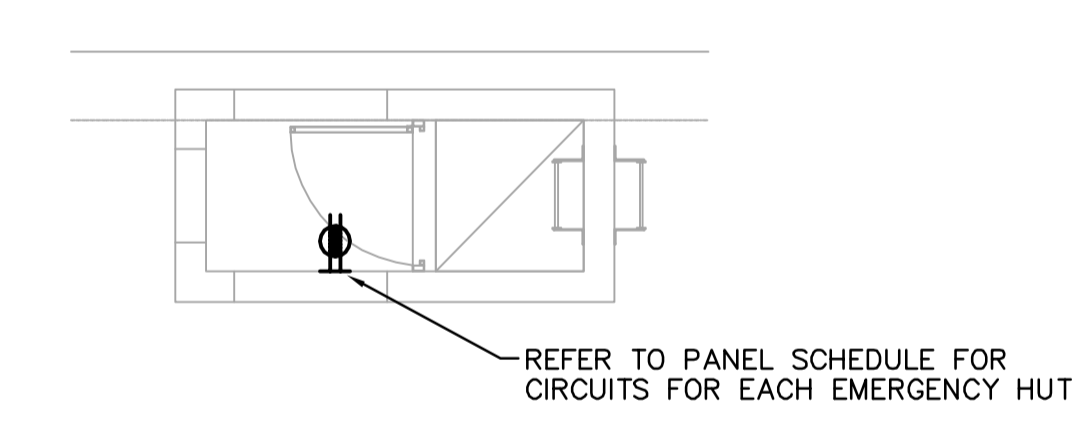

EMERGENCY HUT POWER PLAN
1:50

DRAWING NOTES

- COORDINATE WORK WITH OTHER TRADES TO AVOID CONFLICTS.
- PROVIDE VERTICAL CABLETRAY OVER THE MONORAIL.

 Certificate of Authorization Earth Tech Canada Inc. No. 730 Expiry: April 30, 2007	B.M. ELEV.	 Frederickson Cooper ARCHITECTS DESIGNED BY: BLM CHECKED BY: PS DRAWN BY: ERC APPROVED BY: AHL SCALE: 1:50 RELEASED FOR CONSTRUCTION BY: R. SOROKOWSKI DATE: 2005/03/18	 ENGINEER'S SEAL ORIGINAL SIGNED BY: B.L. MOORE DATE: 2006/08/30 CONSULTANT DRAWING NO.: WT-E0112	 THE CITY OF WINNIPEG WATER AND WASTE DEPARTMENT ENGINEERING DIVISION WATER TREATMENT PLANT TREATED WATER STORAGE INLET BUILDING ELECTRICAL POWER AND FIRE ALARMS FLOOR PLANS	CITY FILE NUMBER
					SHEET OF
					CITY DRAWING NUMBER
					1-0601T-A-E0112-001-03D