


CRAWLSPACE POWER PLAN
1:20

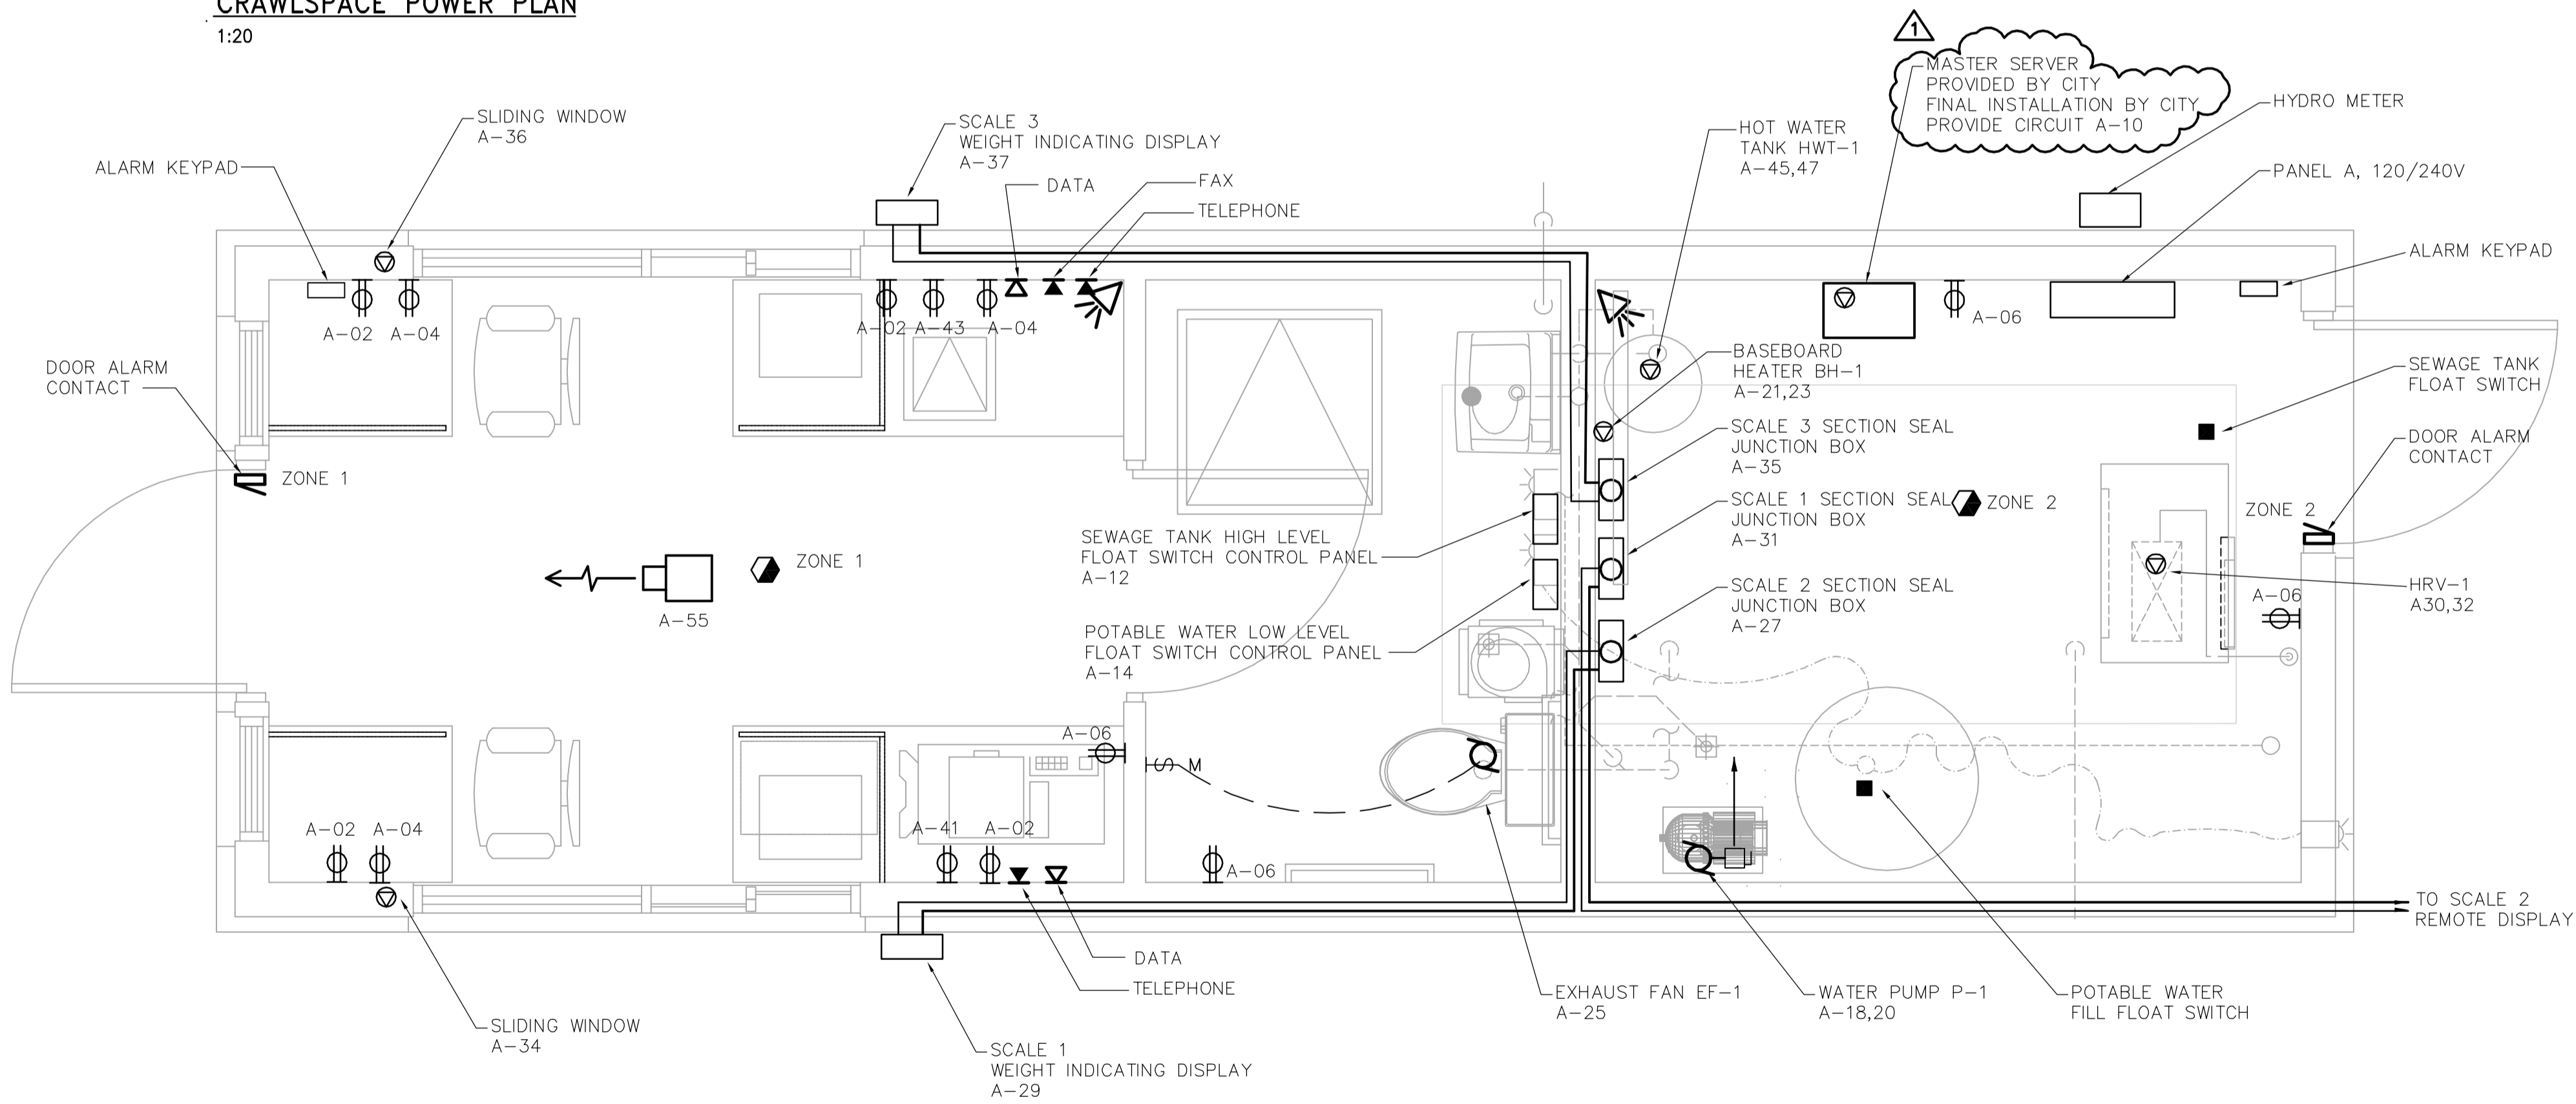

MAIN FLOOR POWER PLAN
1:20

<p>APECM Certificate of Authorization Earth Tech Canada Inc. No. 730</p>	B.M. ELEV.					ENGINEER'S SEAL ORIGINAL SIGNED BY P. STRYK 2007/07/20		THE CITY OF WINNIPEG WATER AND WASTE DEPARTMENT SOLID WASTE SERVICES DIVISION	
		DESIGNED BY	ERC	CHECKED BY	PS	BRADY RD. LANDFILL NEW ENTRANCE AND SCALE FACILITY		CITY FILE NUMBER SHEET OF	
		DRAWN BY	ERC	APPROVED BY	TGS	ELECTRICAL CRAWLSPACE AND MAIN FLOOR POWER PLAN		CITY DRAWING NUMBER SWD-D-391	
	01 357-2007 ADDENDUM 1 07/07/31 ERC 00 ISSUED FOR TENDER 07/07/20 ERC NO. REVISIONS DATE BY	SCALE: 1:20 RELEASED FOR CONSTRUCTION BY: V. JEANCART DATE 2007/07/20	DATE 2006/08/31	DATE 2007/07/20	CONSULTANT DRAWING NO. E1.04				