


PLOT: 08/01/24 10:56:59 AM
 UMA FILE NAME: D265-202-02_00-E-0003_RX.dwg Saved By: djf

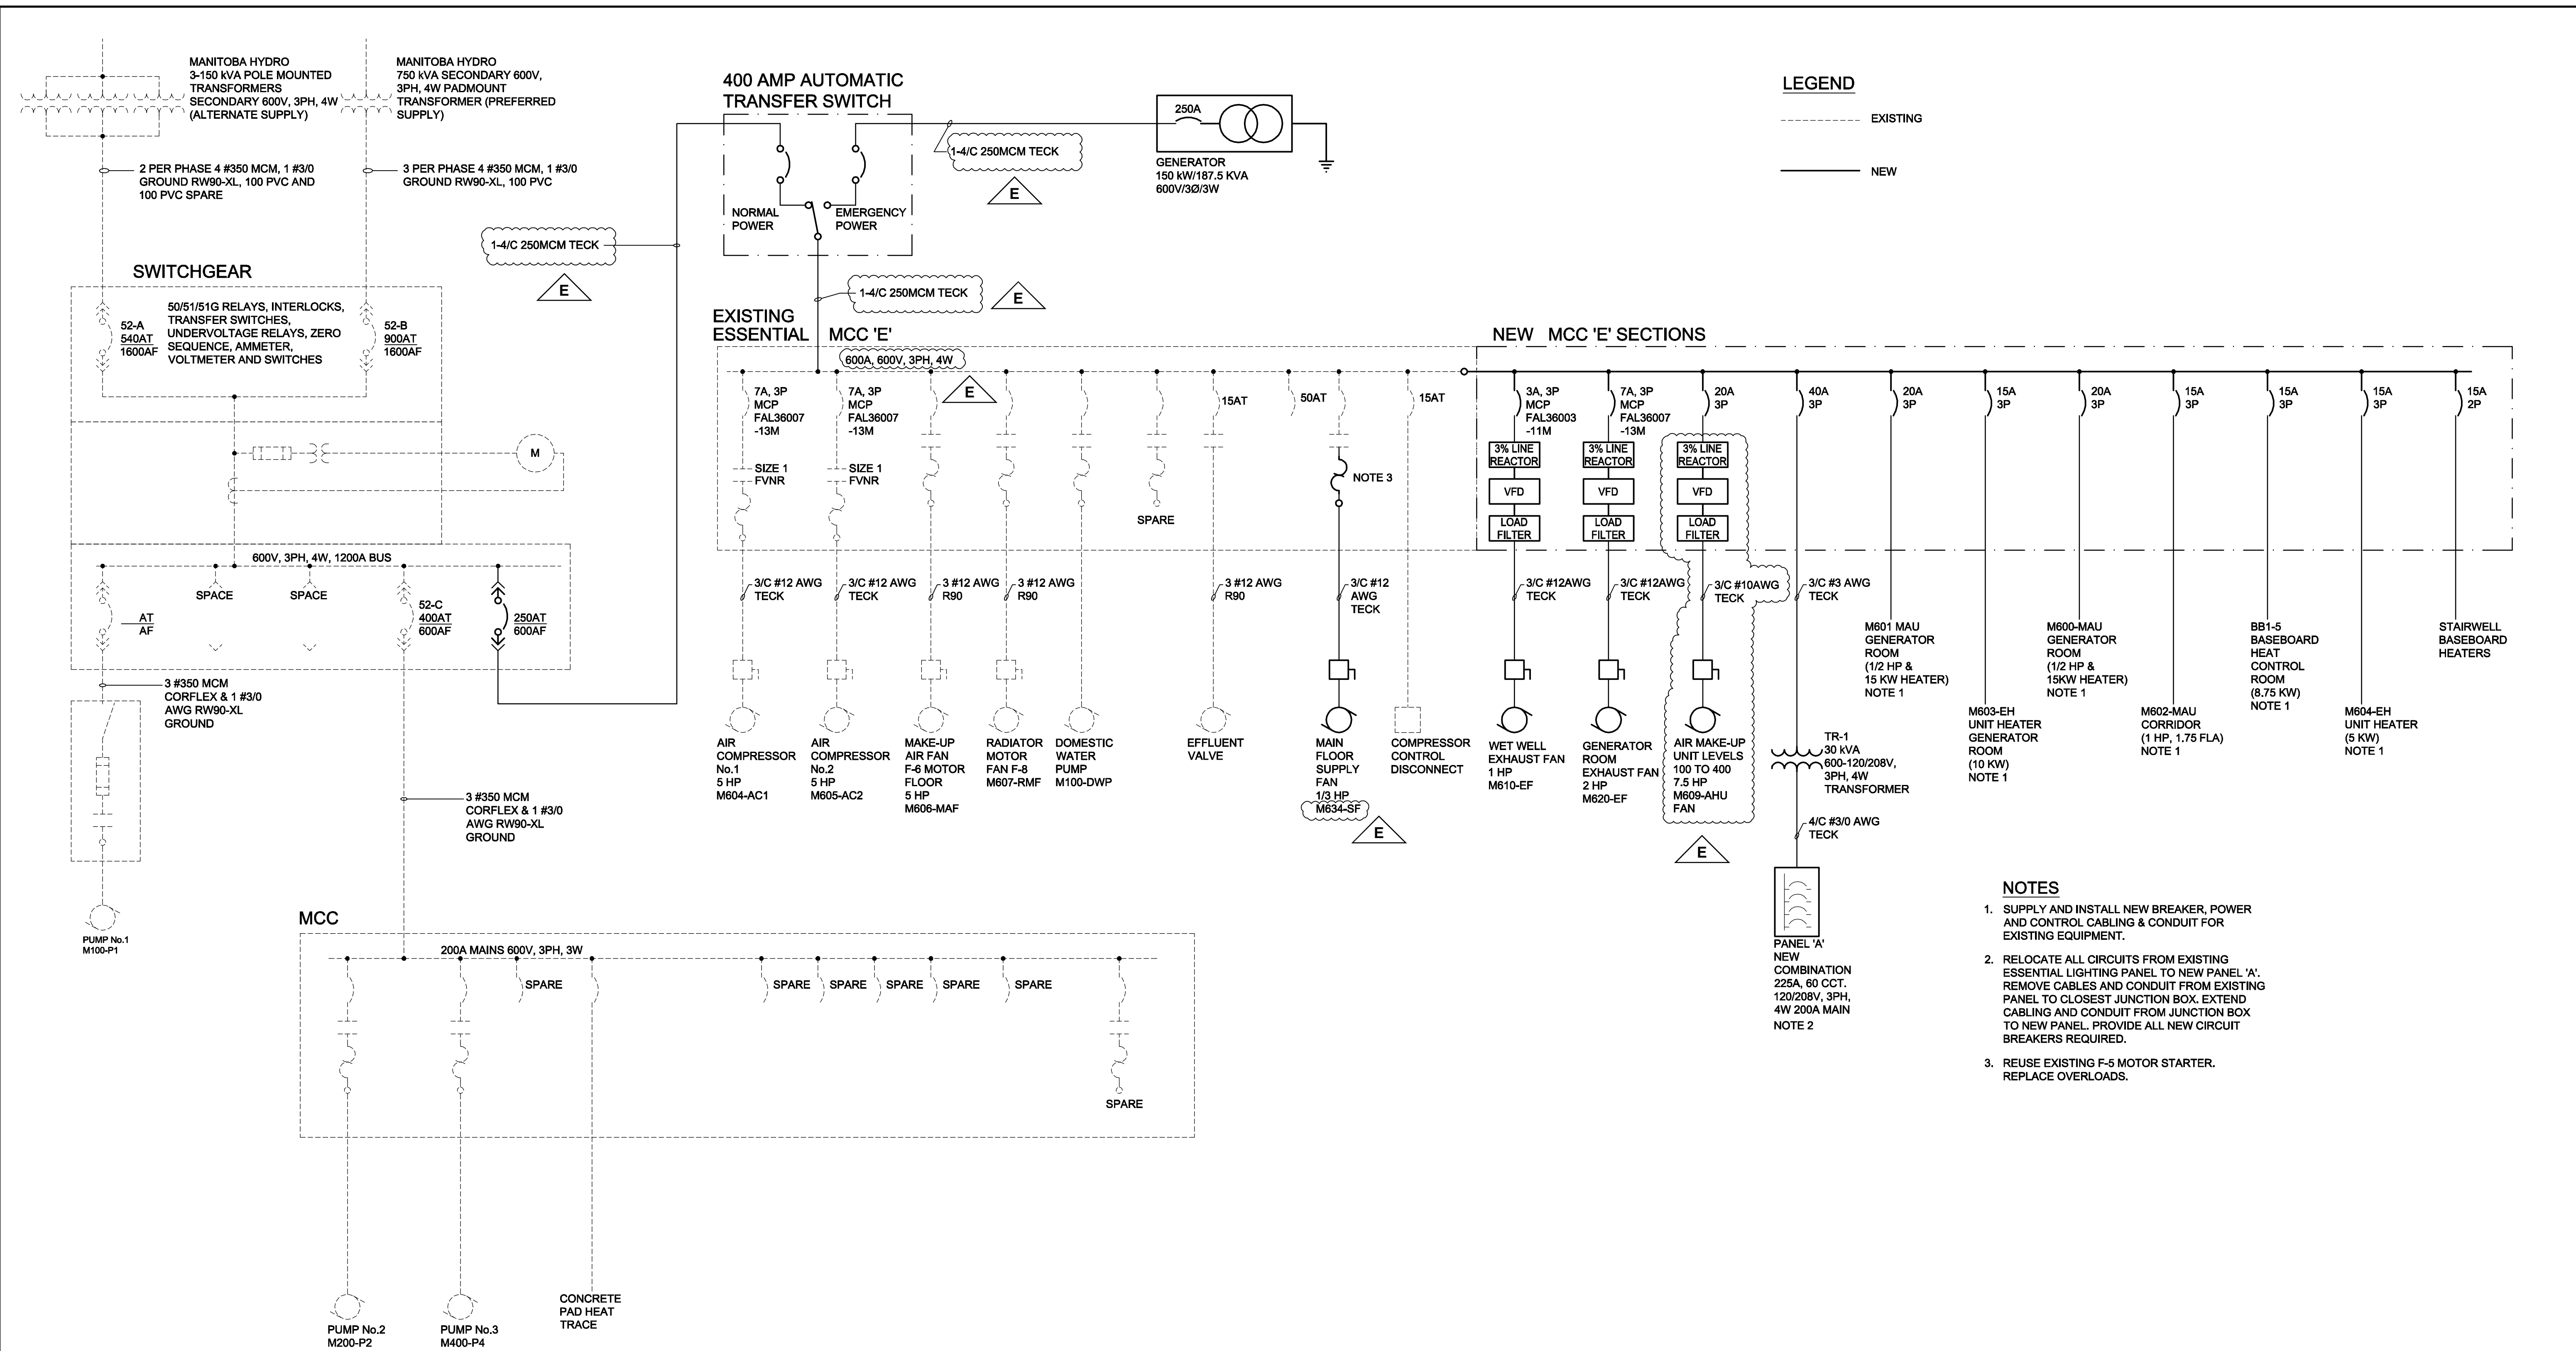

SINGLE LINE DIAGRAM
 SCALE: N.T.S.

APEGM
 Certificate of Authorization
 UMA Engineering Ltd. (MB)
 No. 256 Date: 07/12/14

QL	RS	LK	BM	SS
DRN	CHK	DES	ENG	IDR
UMA REVIEW				

B.M. ELEV.	FIELD BOOK #:	UMA AECOM	
POSTED TO LBIS		DESIGNED BY: BLM	CHECKED BY: _____
		DRAWN BY: QL	APPROVED BY: -
E ISSUED FOR ADDENDUM 3	08/01/23	QL	
D ISSUED FOR BID	07/12/14	LJV	
C ISSUED FOR 100% REVIEW	07/11/09	SCK	
B ISSUED FOR ZONING	07/08/21	SCK	
A ISSUED FOR 80% REVIEW	07/06/18	SCK	
NO. REVISIONS	DATE	BY	FILENAME: D265-202-02_00-E-0003_RX.dwg

ENGINEER'S SEAL
 ISSUE / REVISION D
 ISSUED FOR BID
 WAS SEALED BY
 B.L. MOORE
 AND DATED
 07/12/14

THE CITY OF WINNIPEG
 WATER AND WASTE DEPARTMENT

PERIMETER ROAD PUMPING STATION UPGRADES
 Contract B - Building Upgrades

Electrical
 SINGLE LINE DIAGRAM

CITY DRAWING NUMBER	SHEET	REV.	SIZE
1-0111L-E0002	001	E	D