



D SIZE 22" x 34" (559mm x 864mm)

PLOT: 1/31/2008 9:48:20 AM


NCA FILE NAME: A0010-AR STR SEC2.dwg Saved By: amirico.j

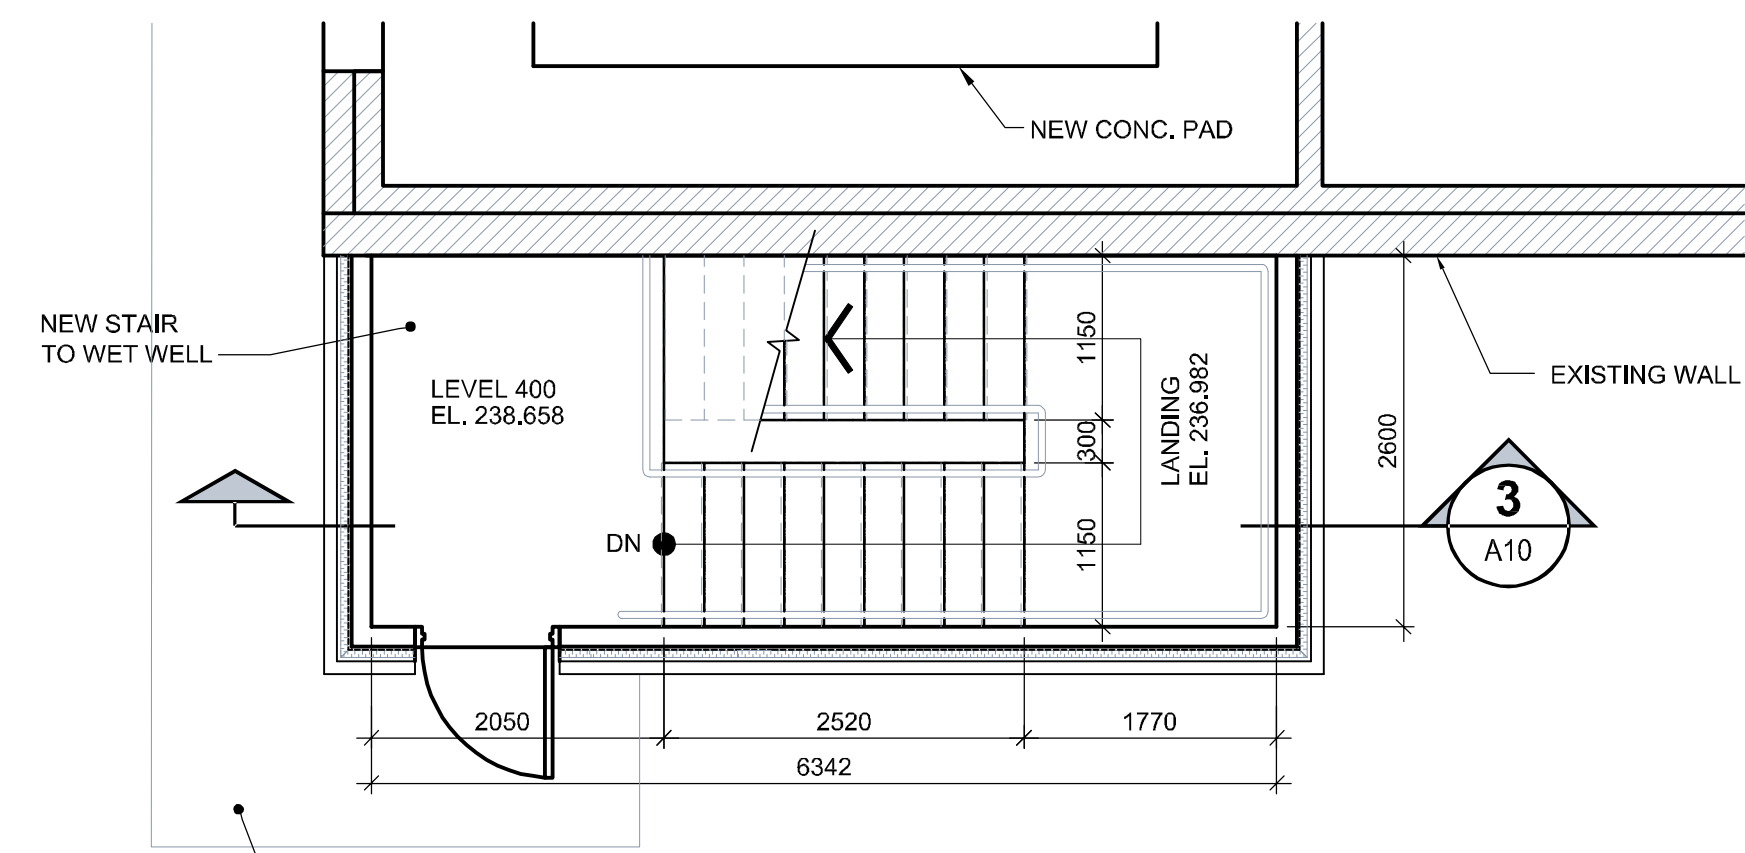


1 STAIR PLAN @ LEVEL 400
SCALE: 1:50

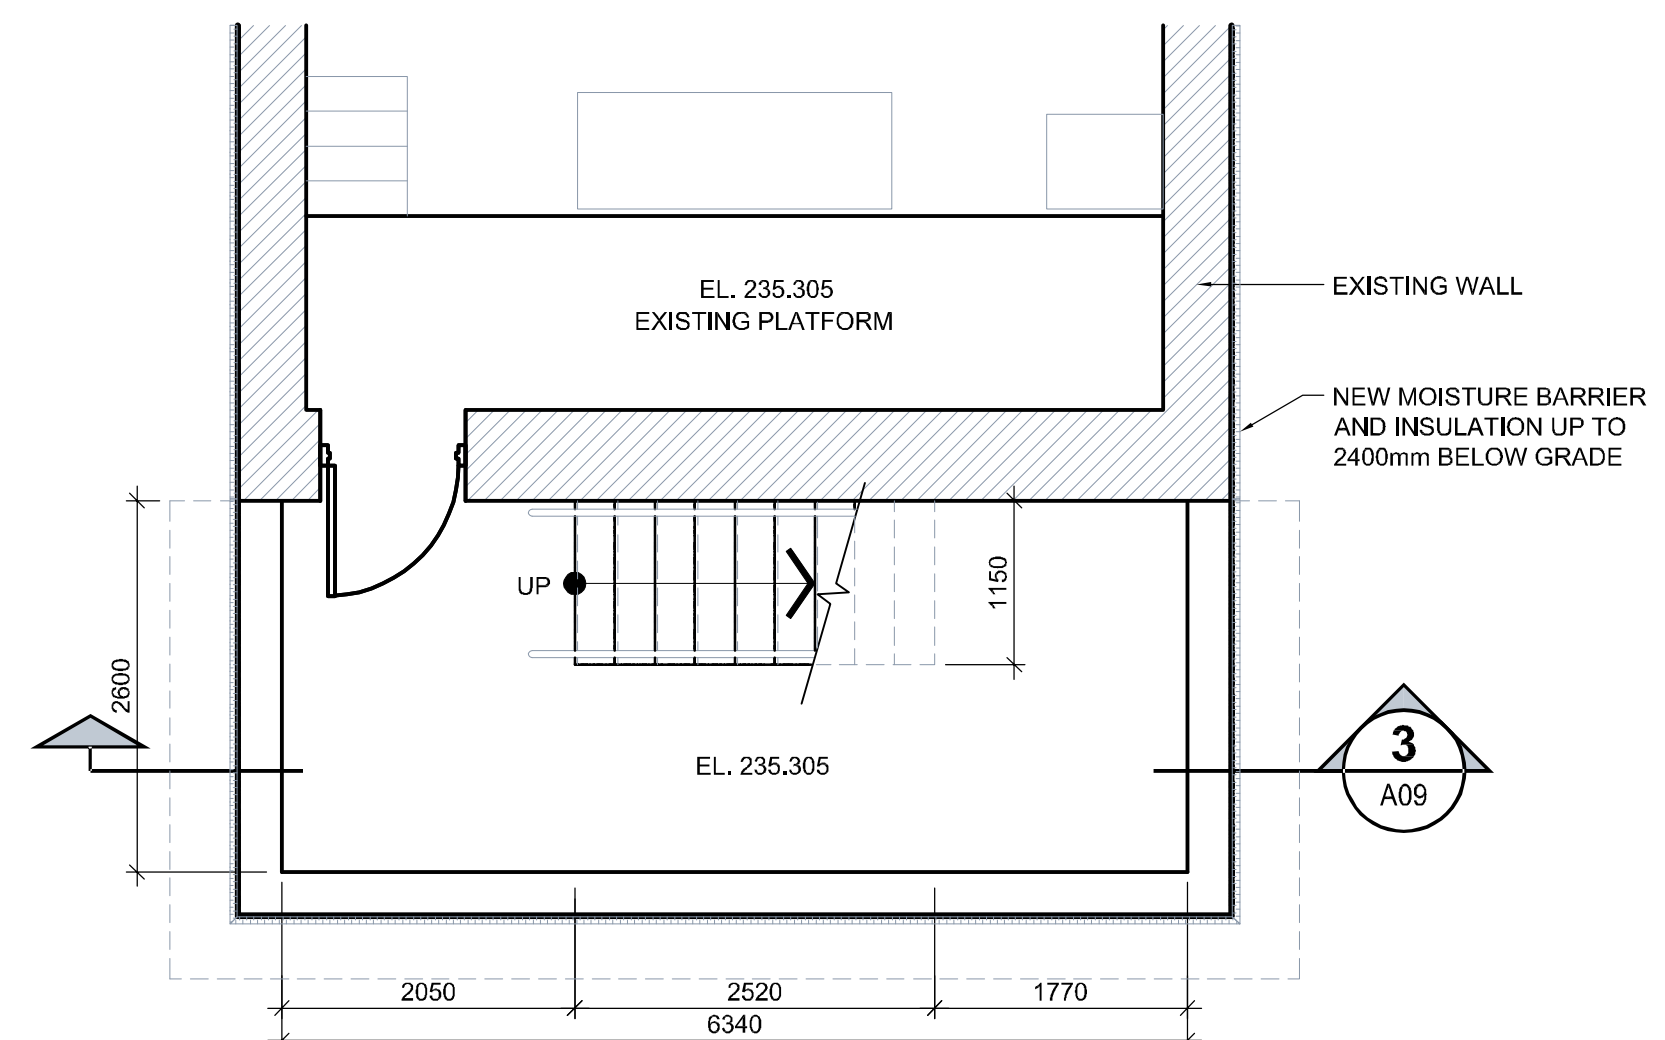


2 STAIR PLAN @ LEVEL 300
SCALE: 1:50

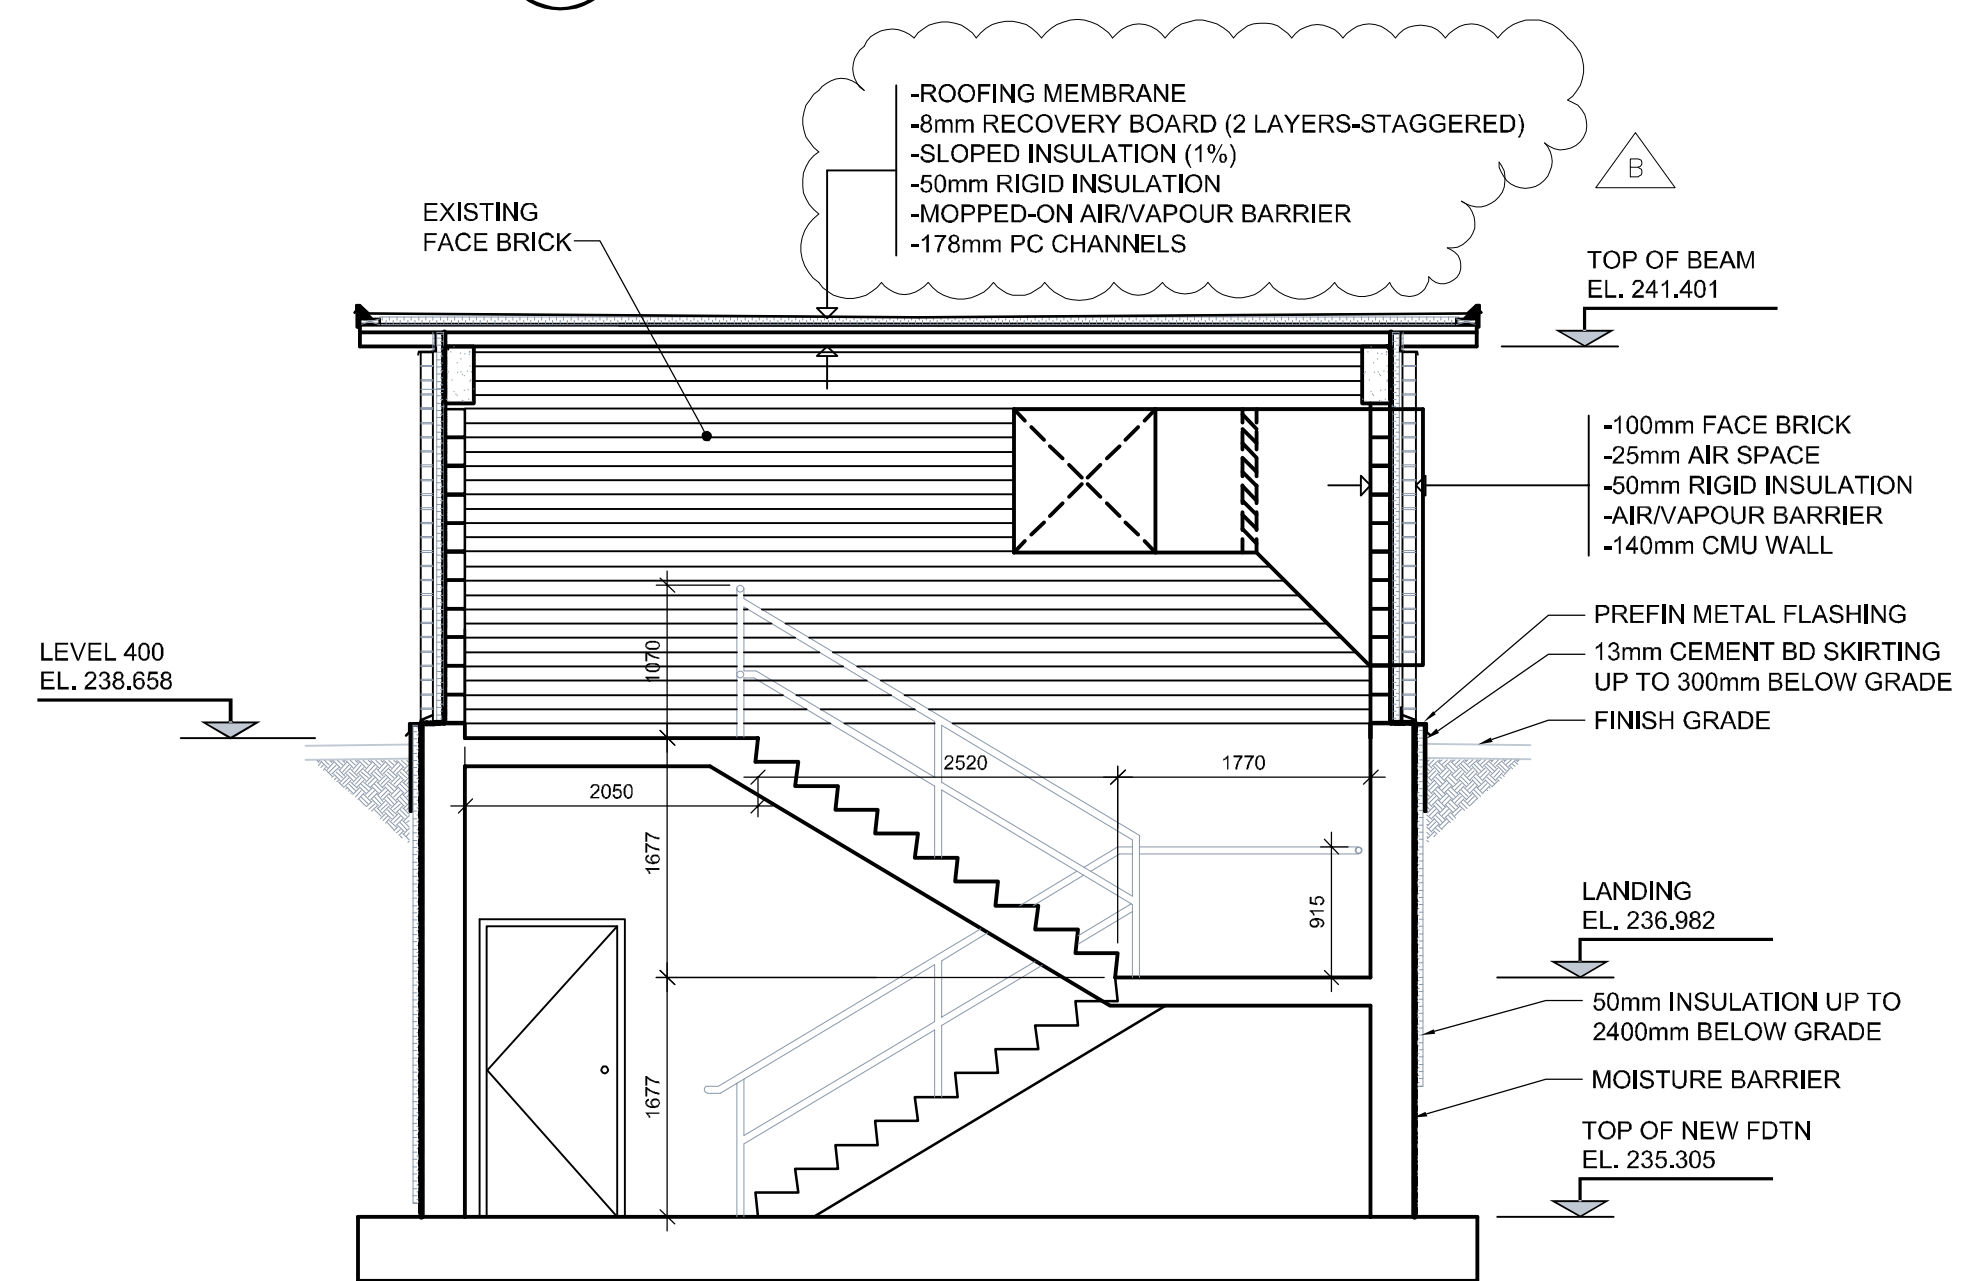


3 STAIR SECTION
SCALE: 1:50

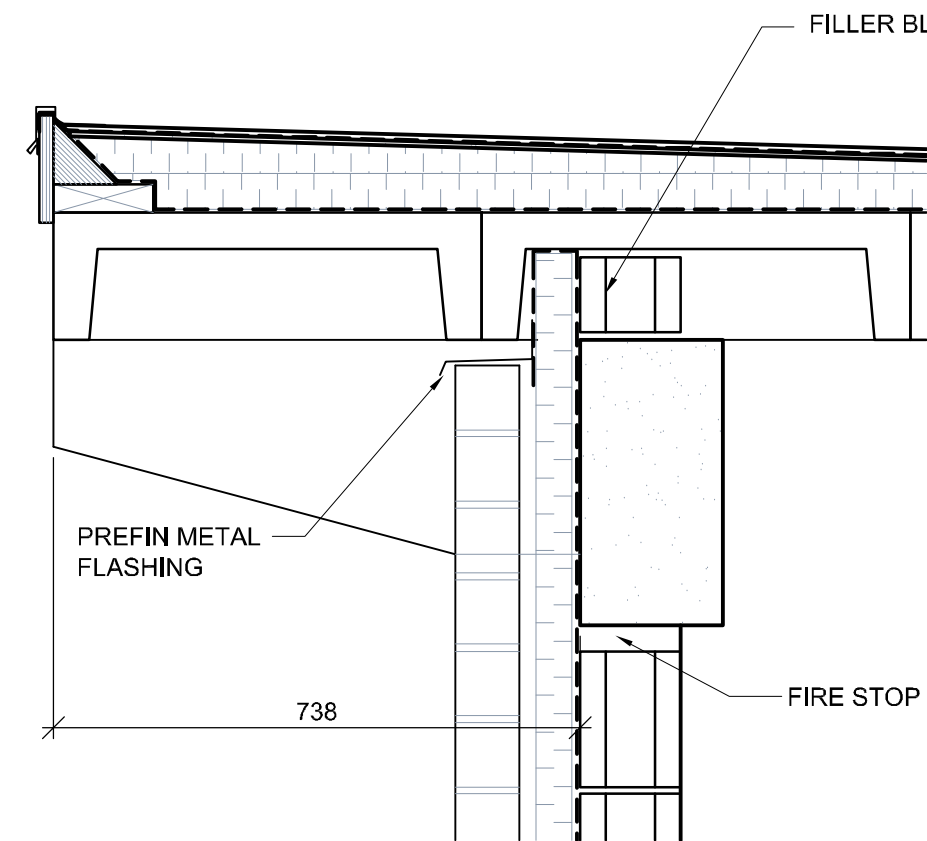


6 DETAIL
SCALE: 1:10

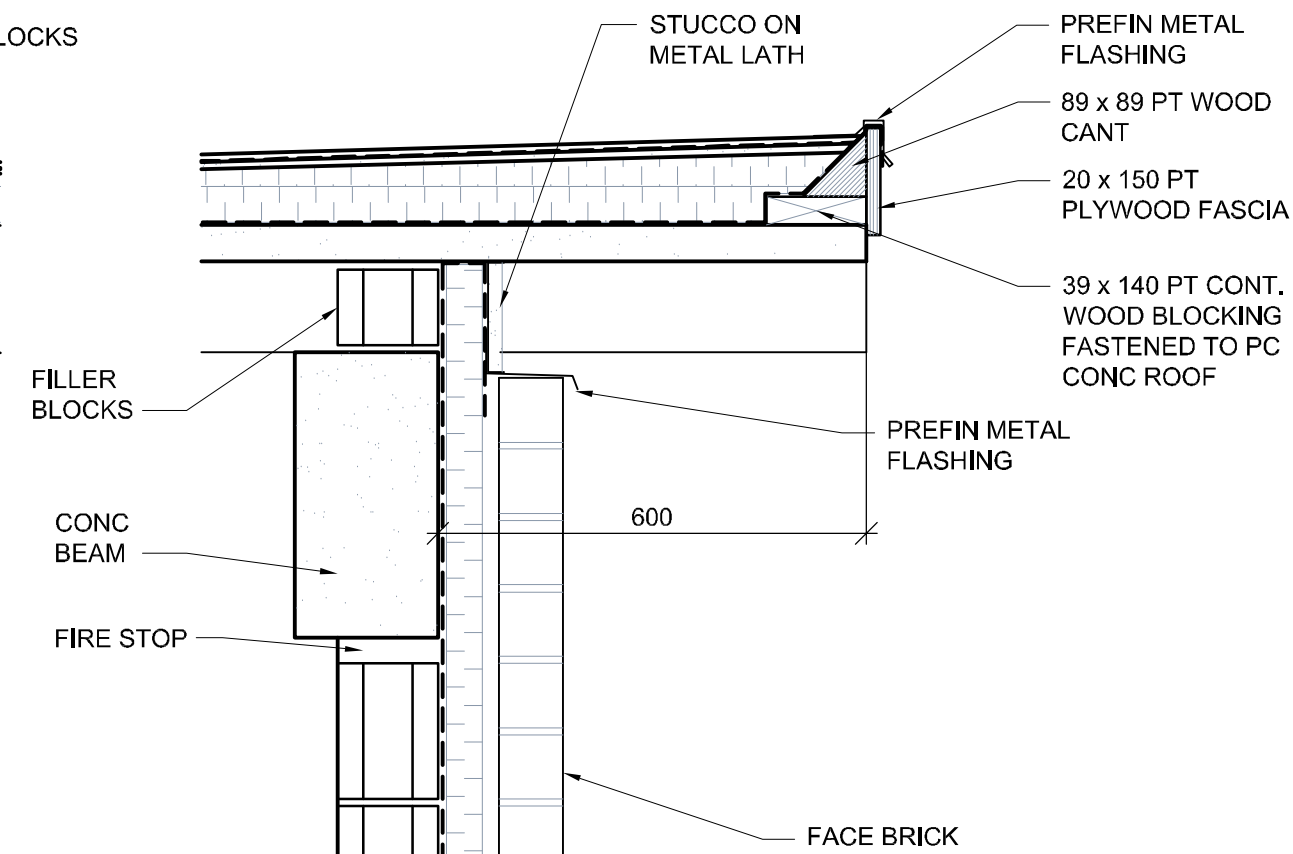


7 DETAIL
SCALE: 1:10

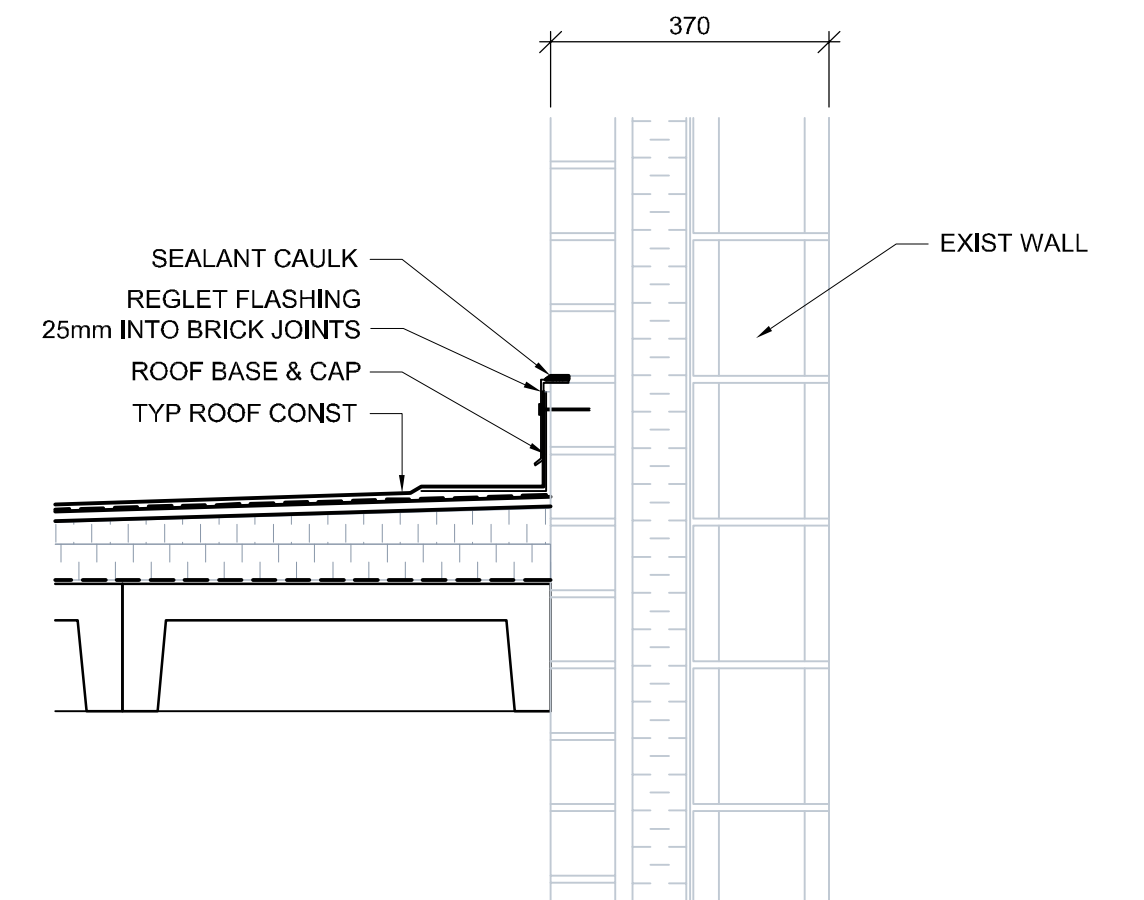


8 DETAIL
SCALE: 1:10

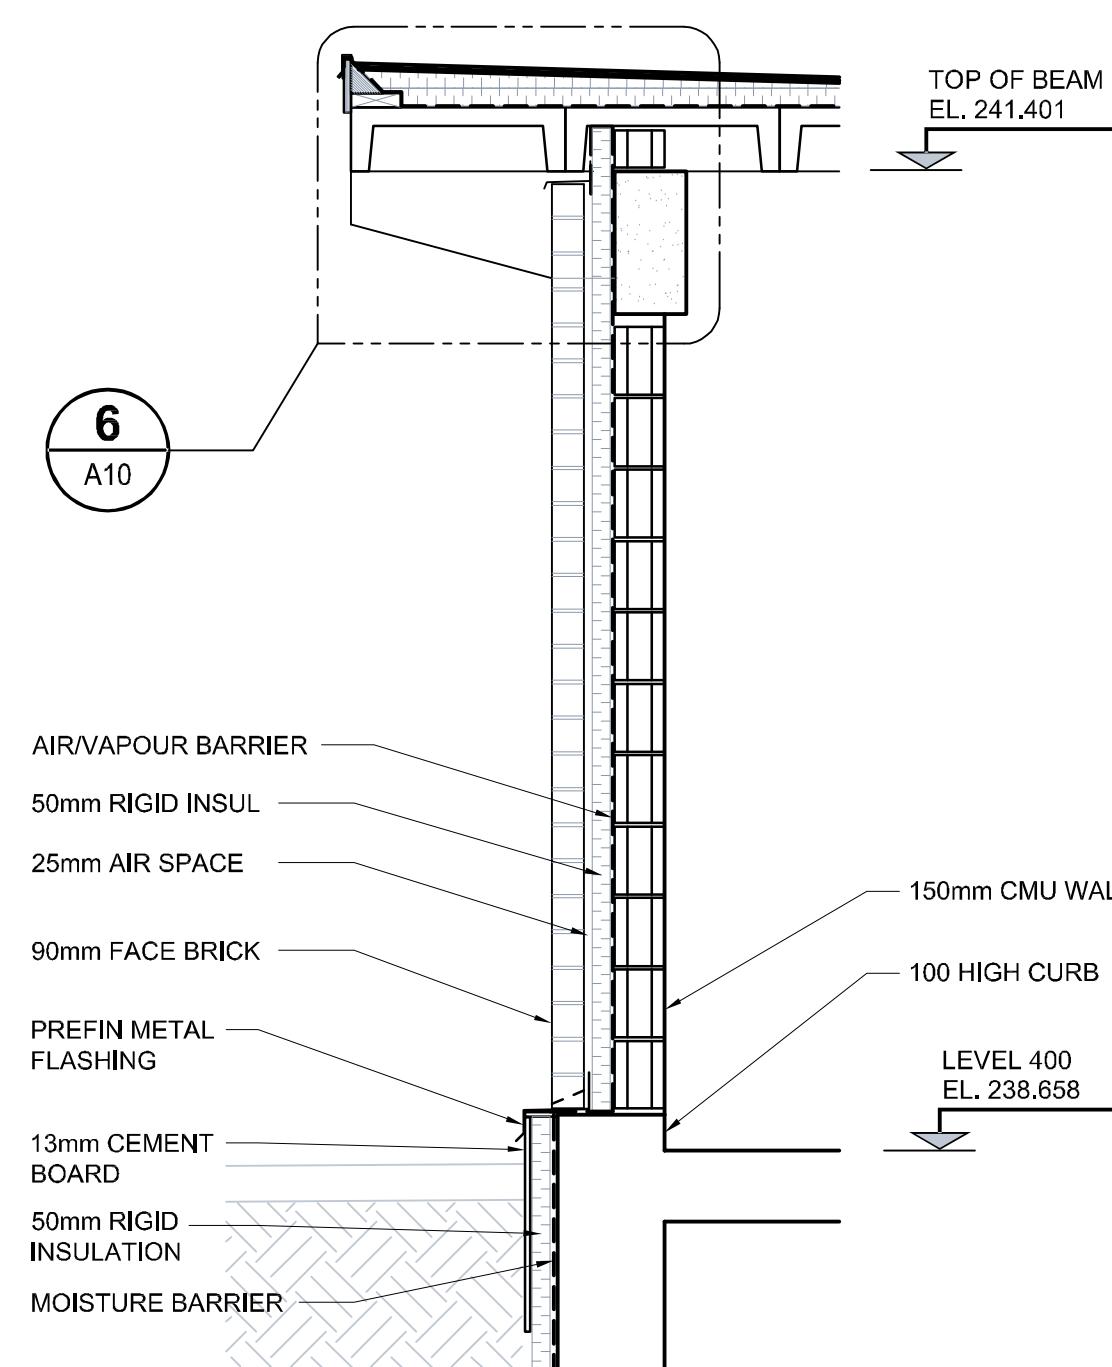

4 WALL SECTION
SCALE: 1:20

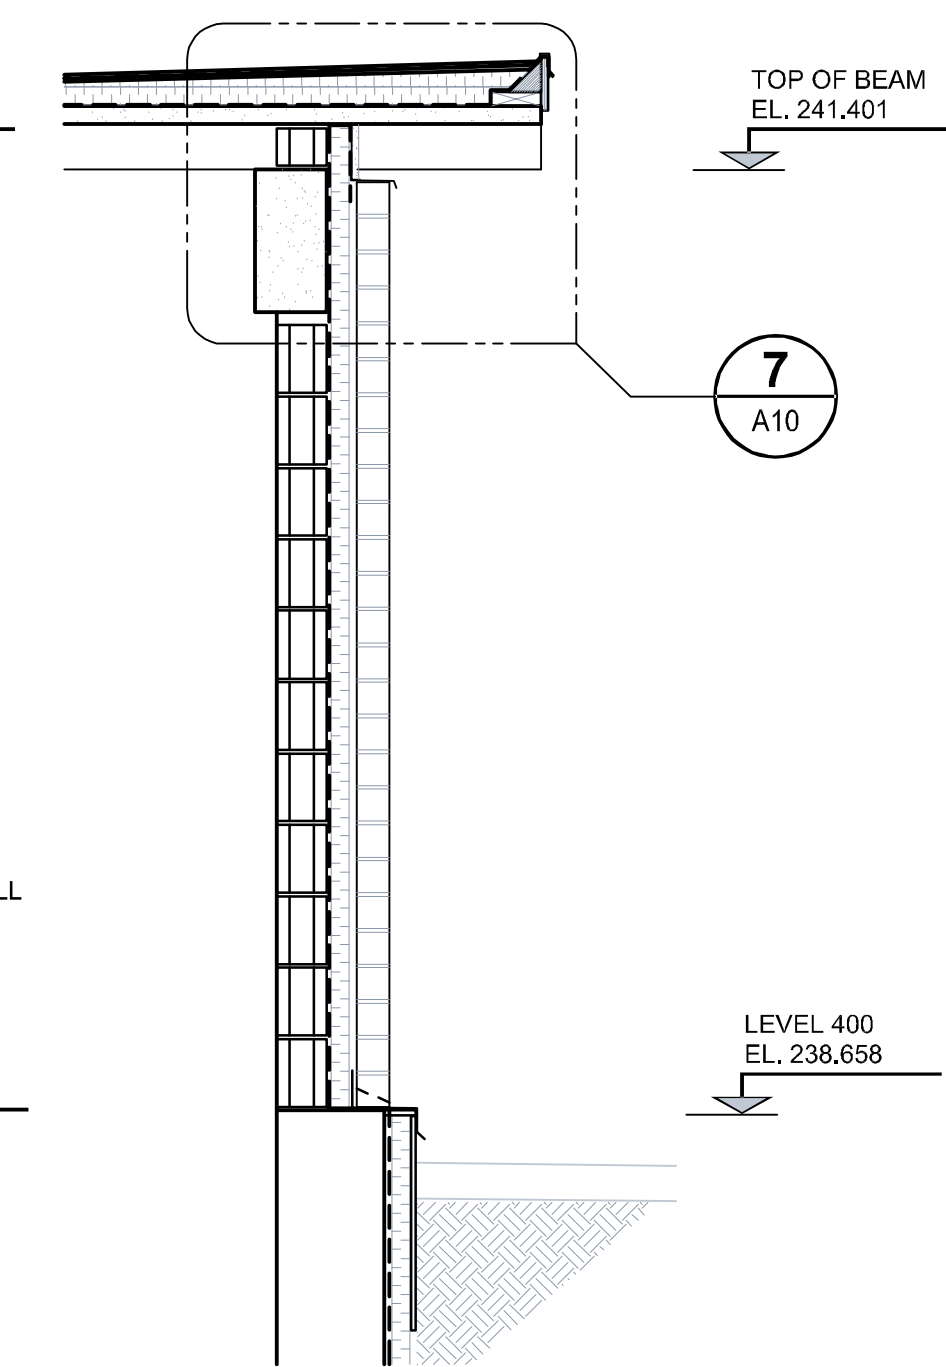


5 WALL SECTION
SCALE: 1:20

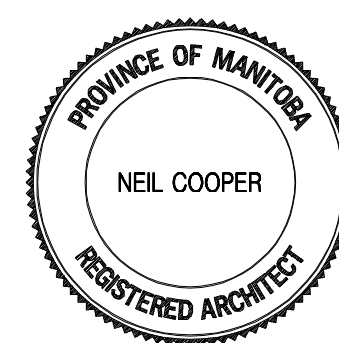

B.M. ELEV.	FIELD BOOK #:	Neil Cooper Architect Inc. 10-395 Berry Street, Winnipeg, Manitoba R3M 1N6 Phone: (204) 885-3855 Fax: (204) 831-7148	
POSTED TO LBIS		DESIGNED BY NC	CHECKED BY -
		DRAWN BY CCG/AL	APPROVED BY -
		HOR. SCALE AS NOTED	RELEASED FOR CONSTRUCTION
		VERTICAL AS NOTED	DATE
B ISSUED FOR ADDENDUM 4	08/02/01	AL	DATE 07/06/14
A ISSUED FOR BID	07/12/14	AL	DATE
NO. REVISIONS	DATE	BY	FILENAME: A0010-AR STR SEC2.dwg

ENGINEER'S SEAL
REVISION - A ISSUED FOR BID WAS SEALED BY NEIL COOPER AND DATED DEC 14, 2007

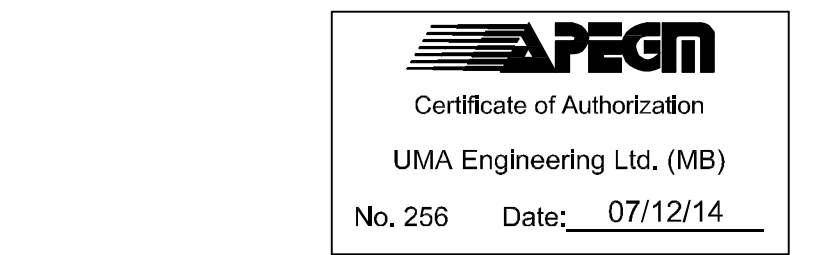

THE CITY OF WINNIPEG
WATER AND WASTE DEPARTMENT
PERIMETER ROAD PUMPING STATION UPGRADES
Contract B - Building Upgrades
Architectural - New Construction
STAIR PLANS & SECTION DETAILS
CITY DRAWING NUMBER 1-0111L-A0010
SHEET 001
REV. B
SIZE D