

FILE NAME: 06024-A7.13.dwg/A7.13

DATE: 2007 Feb 15

DESCRIPTION: MILLWORK NOTES

PROJECT No: 06024

ADDRESS: 999 Sargent Ave, Winnipeg, MB

MILLWORK NOTES

- STANDARDS
AWMAC PREMIUM GRADE MILL STANDARD LATEST EDITION CONSTRUCTION
- DRAWER SIDES, BACKS, AND BOTTOMS TO BE 1/2" ROTARY CUT BIRCH
 - ALL EXTERIOR SURFACES (INCLUDING TOPS, GABLES, BOTH SIDES OF DRAWER AND DOOR FRONTS AND SELF EDGING, ETC.) TO BE FINISHED AS NOTED FOR SPECIFIC MILLWORK.
 - ALL SUPPORT BLOCKING WITHIN MILLWORK TO BE CONCEALED FROM VIEW.
 - ALL UNITS TO BE FIRMLY SCRIBED WITHIN PARTITIONS.
 - ALL CONSTRUCTION TO BE 3/4" PLYWOOD OR PARTIAL BOARD AS SPECIFIED.
- SHOP DRAWINGS
SHOP DRAWINGS TO BE DONE AND SENT TO CONTRACT ADMINISTRATOR FOR APPROVAL PRIOR TO CONSTRUCTION.

CONTINUES UNDER COUNTER FLUORESCENT LIGHTS
MFG.: HAFELE
MINI FLUORESCENT UNDER CABINET LIGHTS
SURFACE MOUNTED
13 WATT, 21"L, 3" H, 1"
MODEL: 826.11.612
COLOR: SATIN NICKEL
CONTRACTOR TO HARDWIRE FOR SWITCH
SEE E-DWG FOR DETAILS

MIRROR FRAMES FOR ALL WASHROOMS
HAFELE: 1927 PROFILE
STAINLESS STEEL FINISH
MODEL#: 000209

MOUNTING HARDWARE FOR MIRRORS FRAMES
FOR ALL WASHROOMS
HAFELE: KEKU AD DOUBLE PARTITION FASTENERS
MODEL: 262.51.310

CLOSET ROD
RICHELIEU: 122.108.140 METAL ROD
COLOR: CHROME 1 1/8" DIA
OPEN FLANGE
MODEL #: 8334-140
CHROME, 1 1/8" DIA

ROD FOR FOOT REST IN LIBRARY
RICHELIEU: LENGTH TO MATCH MILLWORK
COLOR: CHROME 1" DIA STEEL ROD
DELUXE OUTSIDE BRACKET
MODEL #: 3625-140
CHROME, 1" DIA
CURVED DESK AREA TO HAVE CURVED ROD TO
MATCH CURVE IN DESK

PARTICLE BOARD CORE MIN 45 LBS.
DENSITY CONFORMING TO ANSI A208.1
- 1999 1-M-3
AND IS TECO TESTED PER ASTM D-1037
VENEER TO BE HAND SELECTED FLAT SLICED
BOOK MATCHED

02 VENEER TO BE MAPLE
A FACE 10M PAPER BACK VENEER
APPLIED TO TOP AT MILLWORKSHOP

100 MM BASE BOARD
20 GA T 304 #4 STAINLESS STEEL
GLUED TO SUPPORT
XL BUFF - SIMILAR TO A MIRROR FINISH
#4 - ST ST WITH A STRAIGHT GRAIN

- MILLWORK HARDWARE
 - DRAWER GLIDES KNAPP & VOGT 1483 (UP TO 150 LB. LOAD RATING. HEAVY DUTY FULL EXTENSION) DRAWERS OVER 6" HIGH & PRINTER SHELF DRAWERS 1248 (UP TO 50 LB. LOAD RATING. DRAWERS UNDER 6" HIGH)
 - GROMMET HAFELE 429.94.212 (56MM) CHROME POL. ZINC DIE CAST
 - PENCIL TRAY PENCIL TRAY TO BE PROVIDED FOR ONE BOX DRAWER IN EACH PEDESTAL.
 - FILE BARS SUSPENSION FRAME HARDWARE FOR LETTER SIZE FILES FOR EACH FILE DRAWER
 - HINGES HETTICK CONCEALED HINGES, NO 790 NICKEL FINISH 170 DEGREES.

GLASS SHELF SUPPORT
MFR: HAFEL
MODEL: 282.13.711
COLOR: STEEL NICKEL PLATED

PIANO HINGE MFR: RICHELIEU, MODEL: 281740-180 NICKEL

DOUBLE MAGNETIC CATCH, MFR: RICHELIEU, MODEL: 5010G WITH PLATE, BLACK

SLAT WALL FOR DISPLAY AREA
MFR: RICHELIEU
ALMOND LAMINATED PANELS
MODEL: N10-40-65-444
4" PANEL, 3/4" THICK

MAGAZINE DISPLAY HOLDERS
CLEAR ARCYLIC
SIZE: 18"W, 11"H, 3"D
MODEL: 90140-11

CABLE MANAGEMENT
MFR: HAFEL
MODEL: 6829.15.302
SIZE: 2.5M
COLOR: BLACK

CONCEALED HINGES FOR GLASS DOORS
MFR: HAFEL
MODEL: 329.21.532
MOUNTING PLATE
MODEL: 329.62.520
COLOR: STEEL NICKEL PLATED
4 PER DOOR

GLASS DOOR LOCKS FOR DOUBLE DOORS
MFR: HAFEL
MODEL: 233.33.701
COLOR: STEEL NICKEL PLATED
MOUNT AT BOTTOM OF DOOR

- TOUCH LATCH IVES
- STAINLESS STEEL HANDLE HAFELE MODEL: 117.05.630
ALL LOCATIONS EXCEPT AS NOTED
- METAL SHELF SUPPORT AND STANDARDS K & V ZINC
RECESSED INTO GABLES ENDS
- GLIDES FOR GABLE ENDS
- GLIDES FOR GABLE ENDS
MFG: HAFELE
MODEL: 650.194.324
COLOR: BLACK

KEYING TO BE REVIEWED WITH CLIENT


CYLINDER MODULE SYSTEM - CENTRAL LOCKING SINGLE
PEDESTAL FRONT MOUNT
MFG: HAFELE
ITEM: CYLINDER ROSETTE, 210.04.070
COLOR: MATT NICKEL
ITEM: LOCK BODY WITH LIFTING PIN
MODEL: 234.85.001
ITEM: LOCKBAR CLIP
MODEL: 234.87.998
ITEM: PROTECTIVE CAP
MODEL: 210.02.095
ITEM: LOCKBAR
MODEL: 234.87.818 (457MM)
ITEM: ARRESTING PINS
MODEL: 237.22.723
ITEM: BAR RETAINING BRACKET
MODEL: 234.87.989
ITEM: DRAWER LOCKING WEDGE
MODEL: 234.91.090

NOTES :

- THESE DRAWINGS SHALL NOT BE SCALED.
- THE CONTRACTOR SHALL VISIT THE SITE AND SATISFY ONESELF ALL DIMENSIONS, DATUM, AND DETAILED INFORMATION SHOWN ARE CORRECT.
- THE CONTRACTOR IS TO REVIEW AND COORDINATE ALL ARCHITECTURAL, MECHANICAL, ELECTRICAL AND STRUCTURAL DRAWINGS FOR ADDITIONAL OPENINGS THROUGH FLOORS, WALLS, AND CEILINGS FOR DUCT, PIPE & ELECTRICAL RISERS AND ALL OPENINGS NOT SHOWN ON DRAWINGS.
- ALL OPENINGS THROUGH FIRE ASSEMBLIES ARE TO BE FIRE STOPPED AND SEALED WITH ULC APPROVED FIRE STOPPING TO MAINTAIN THE INTEGRITY OF THE FIRE SEPARATION, AND PROVIDE A SMOKE-TIGHT BARRIER.
- ALL PRODUCTS AND MATERIALS TO BE USED AND INSTALLED SHALL CONFORM WITH MANUFACTURER'S SPECIFICATIONS & APPLICABLE CODES.
- THE CONTRACTOR SHALL BE RESPONSIBLE TO PATCH AND MAKE GOOD ALL EXISTING CONSTRUCTION AFFECTED BY THE REMOVAL OF ALL ITEMS FORMING THE PART OF THE RENOVATION WORK.
- WHERE NEW FLOORING AND BASE IS TO BE INSTALLED IN EXISTING AREAS (REFER TO FLOOR PLAN AND ROOM SCHEDULE) THE EXISTING FLOORING SURFACE AND BASE MUST BE REMOVED, UNLESS OTHERWISE NOTED. ALL FLOOR SURFACES SHALL BE PREPARED IN ACCORDANCE TO MANUFACTURER'S RECOMMENDATIONS FOR INSTALLATION OF NEW FLOOR.
- WHERE PAINTING OF EXISTING WALLS IS INDICATED ON THE ROOM SCHEDULE, THESE WALLS MUST BE CLEANED OF ANY EXISTING WALL COVERING, PATCHED & PREPARED TO ACCEPT NEW MATERIAL, UNLESS OTHERWISE NOTED.

NO.	REVISION/DESCRIPTION	BY	DATE
02	ADDENDUM NO. 3	DG	AUG 24/07
01	ISSUED FOR PERMIT	DG	AUG 19/07
00	ISSUED FOR TENDER	MG	JUL 24/07

SEALS

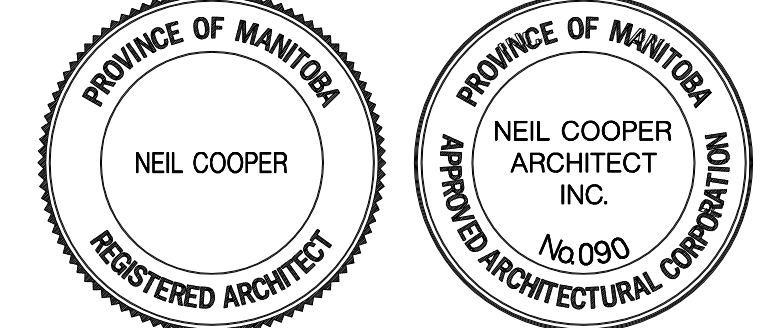

DRAWN BY CAD CHECKED BY USER APPROVAL
DATE 2007 Feb 15

CITY OF WINNIPEG
PLANNING, PROPERTY &
DEVELOPMENT DEPARTMENT
CIVIC ACCOMMODATIONS DIVISION
300 - 65 GARRY ST. R3C 4K4

PROJECT
CONSTRUCTION OF
CINDY KLASSEN RECREATION COMPLEX
FACILITY ENHANCEMENT PROJECT
999 Sargent Ave, Winnipeg, MB

SHEET TITLE
MILLWORK NOTES

SCALE AS SHOWN PROJECT NO. 2005 - 059 SHEET NO. A7.13

DRAWING SHEET SIZE: A1 (841mm x 594mm) PLOT 1:1

Neil Cooper Architect Inc.
10-395 Berry Street, Winnipeg, Manitoba R3J 1N6