


- INFORMATION: FIRE SUPPRESSION REVISIONS ARE NOT LIMITED TO THE ORIGINAL SUBCONTRACTOR, REPUTABLE FIRE PROTECTION CONTRACTORS ARE ACCEPTABLE.
- INFORMATION: THE CONTROL SYSTEM FOR THIS BUILDING IS A JOHNSON CONTROL PRODUCT, HOWEVER LACK OF COMPLEXITY OF THIS PROJECT WOULD ALLOW THAT A REPUTABLE CONTROL SUBCONTRACTOR WOULD BE ACCEPTABLE.

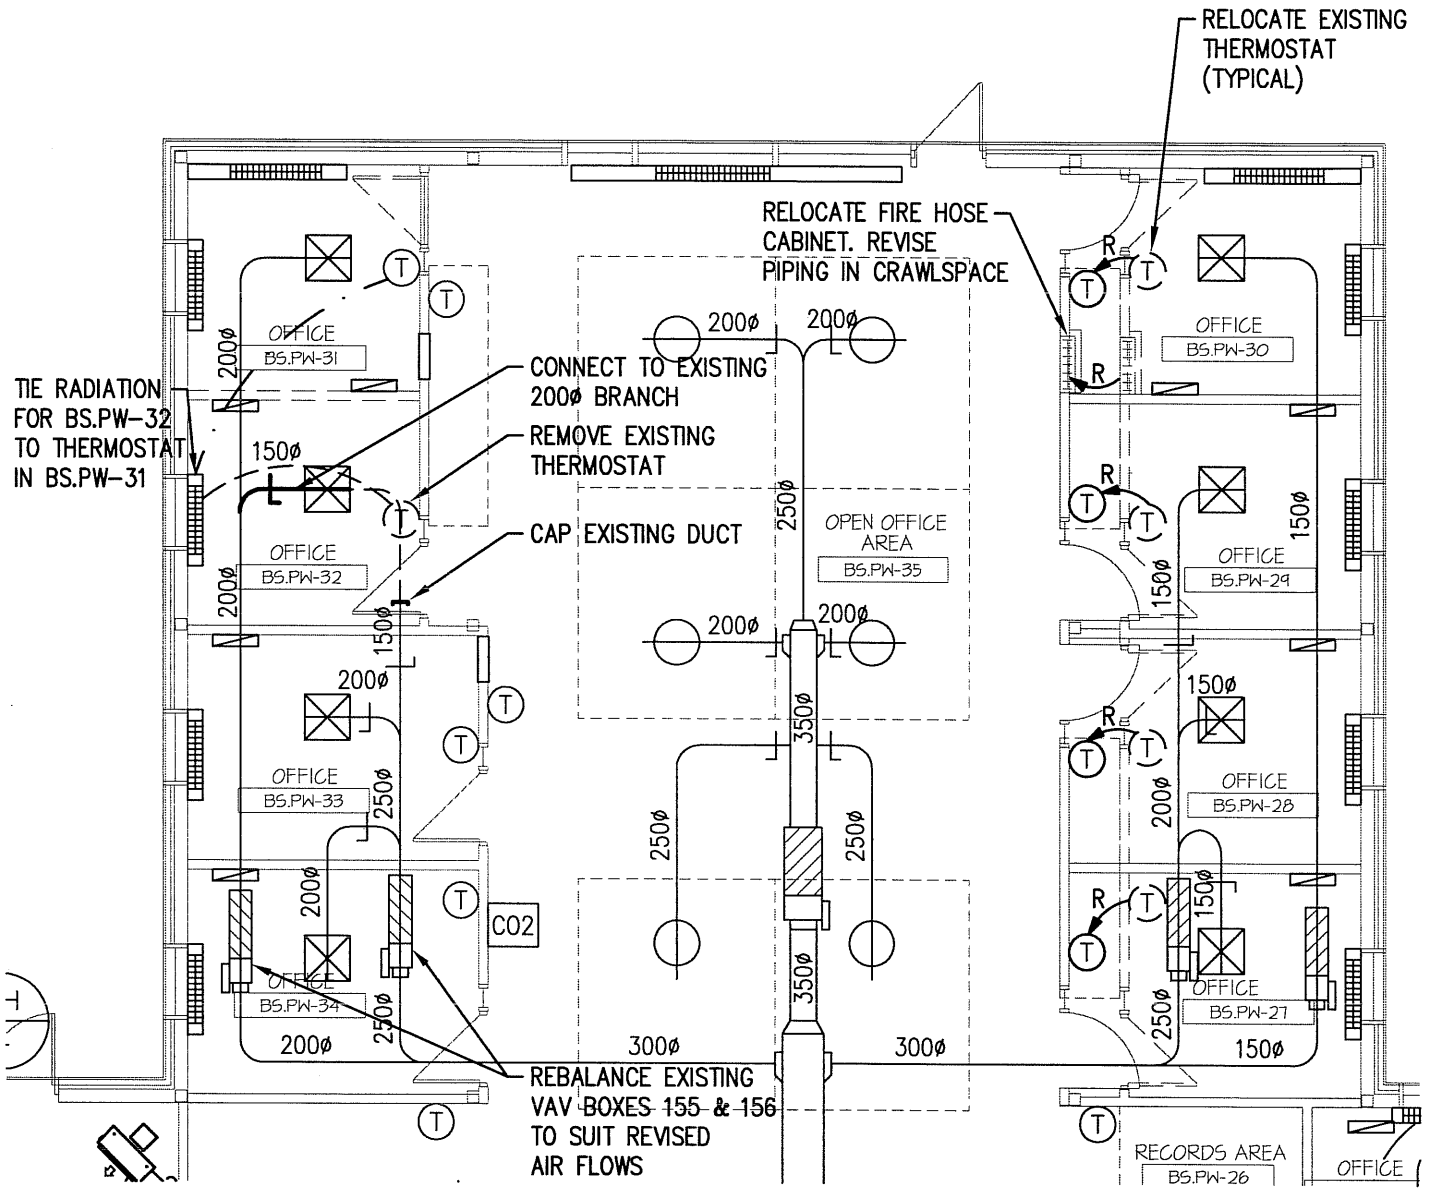

MAIN FLOOR PLAN - PART A

SCALE 1:100

SMS ENGINEERING

SMS Engineering Ltd. Consulting Engineers
 770 Bradford Street Winnipeg MB Canada R3H 0N3
 Telephone 204.775.0291 Fax 204.772.2153
 sms@smsgeng.com

02-018-05



APEGM
 Certificate of Authorization
 SMS Engineering Ltd.
 No. 166 Expiry: April 30, 2007



Friesen Tokar Architects + Landscape + Interior Designers
 200 - 2033 Portage Avenue Winnipeg, Canada R3J 0K8 tel. 204.885.9323 fax. 204.837.7235

DRAWN BY JC	PROJECT TITLE CITY OF WINNIPEG INTERIOR RENOVATIONS WASTEWATER SERVICES AREA 1199 PACIFIC AVE. WPG, MB	DRAWING MD-1 R1
DATE JAN. 2007	BID OPPORTUNITY NO. 56-2007	
PROJECT NO. 06.988		