




1 WALL SECTION  
WB-B0120 1 : 20

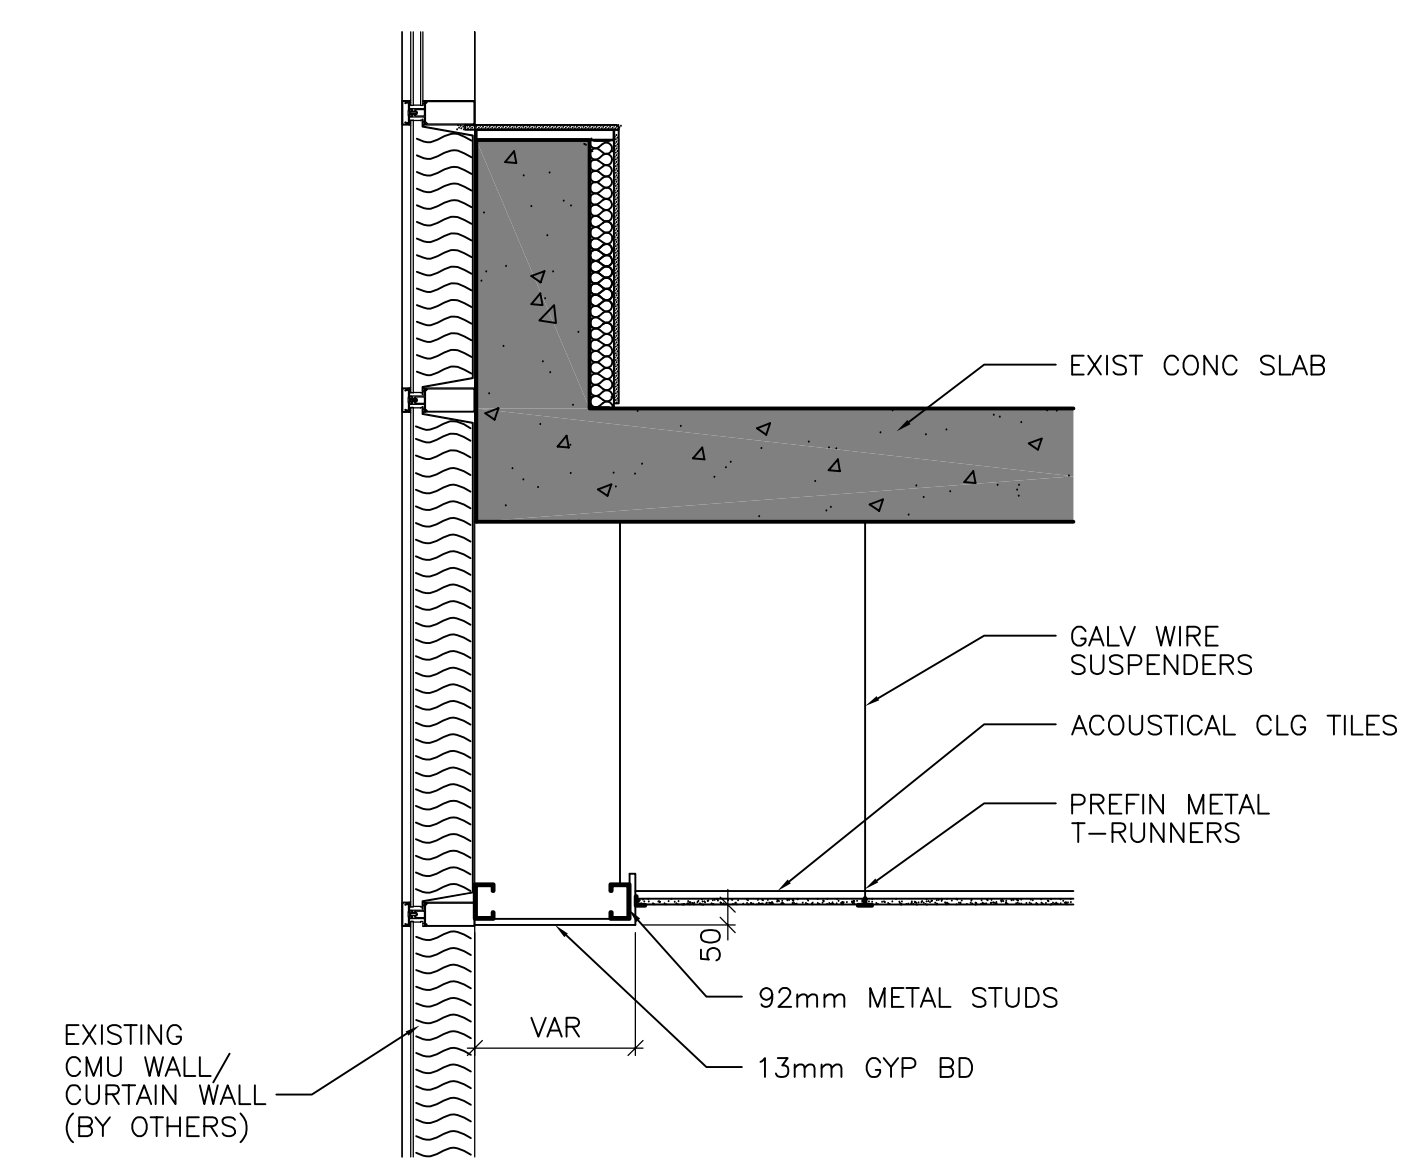


2 TYP CEILING DETAIL @ BULKHEAD  
WB-B0152 1 : 20

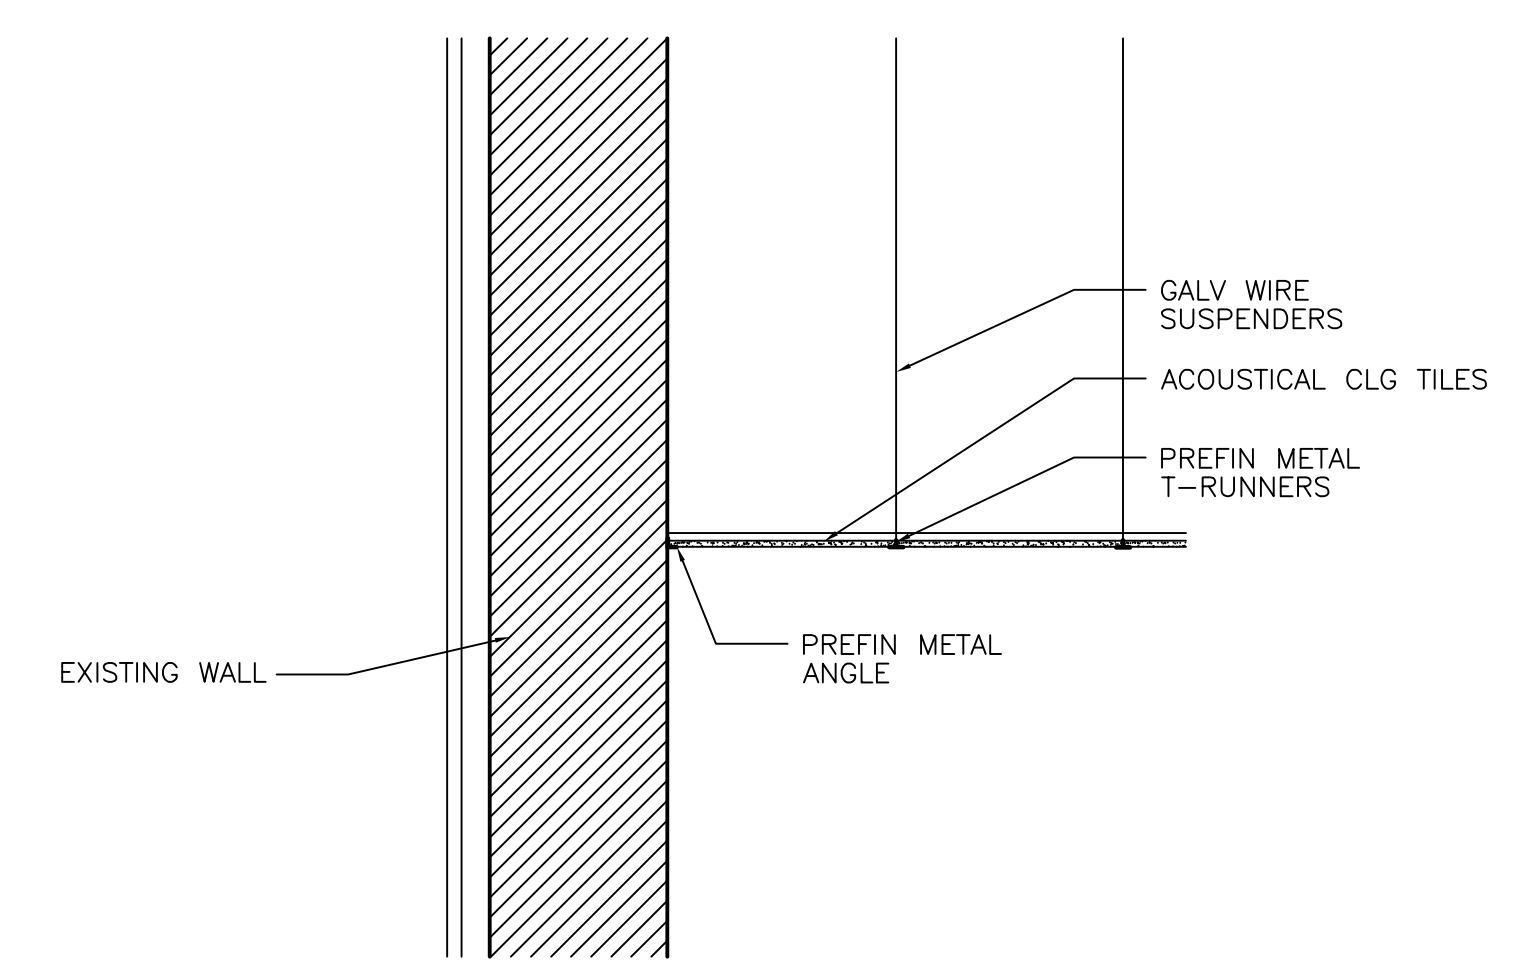

3 TYP CEILING DETAIL @ ACT  
WB-B0153 1 : 20

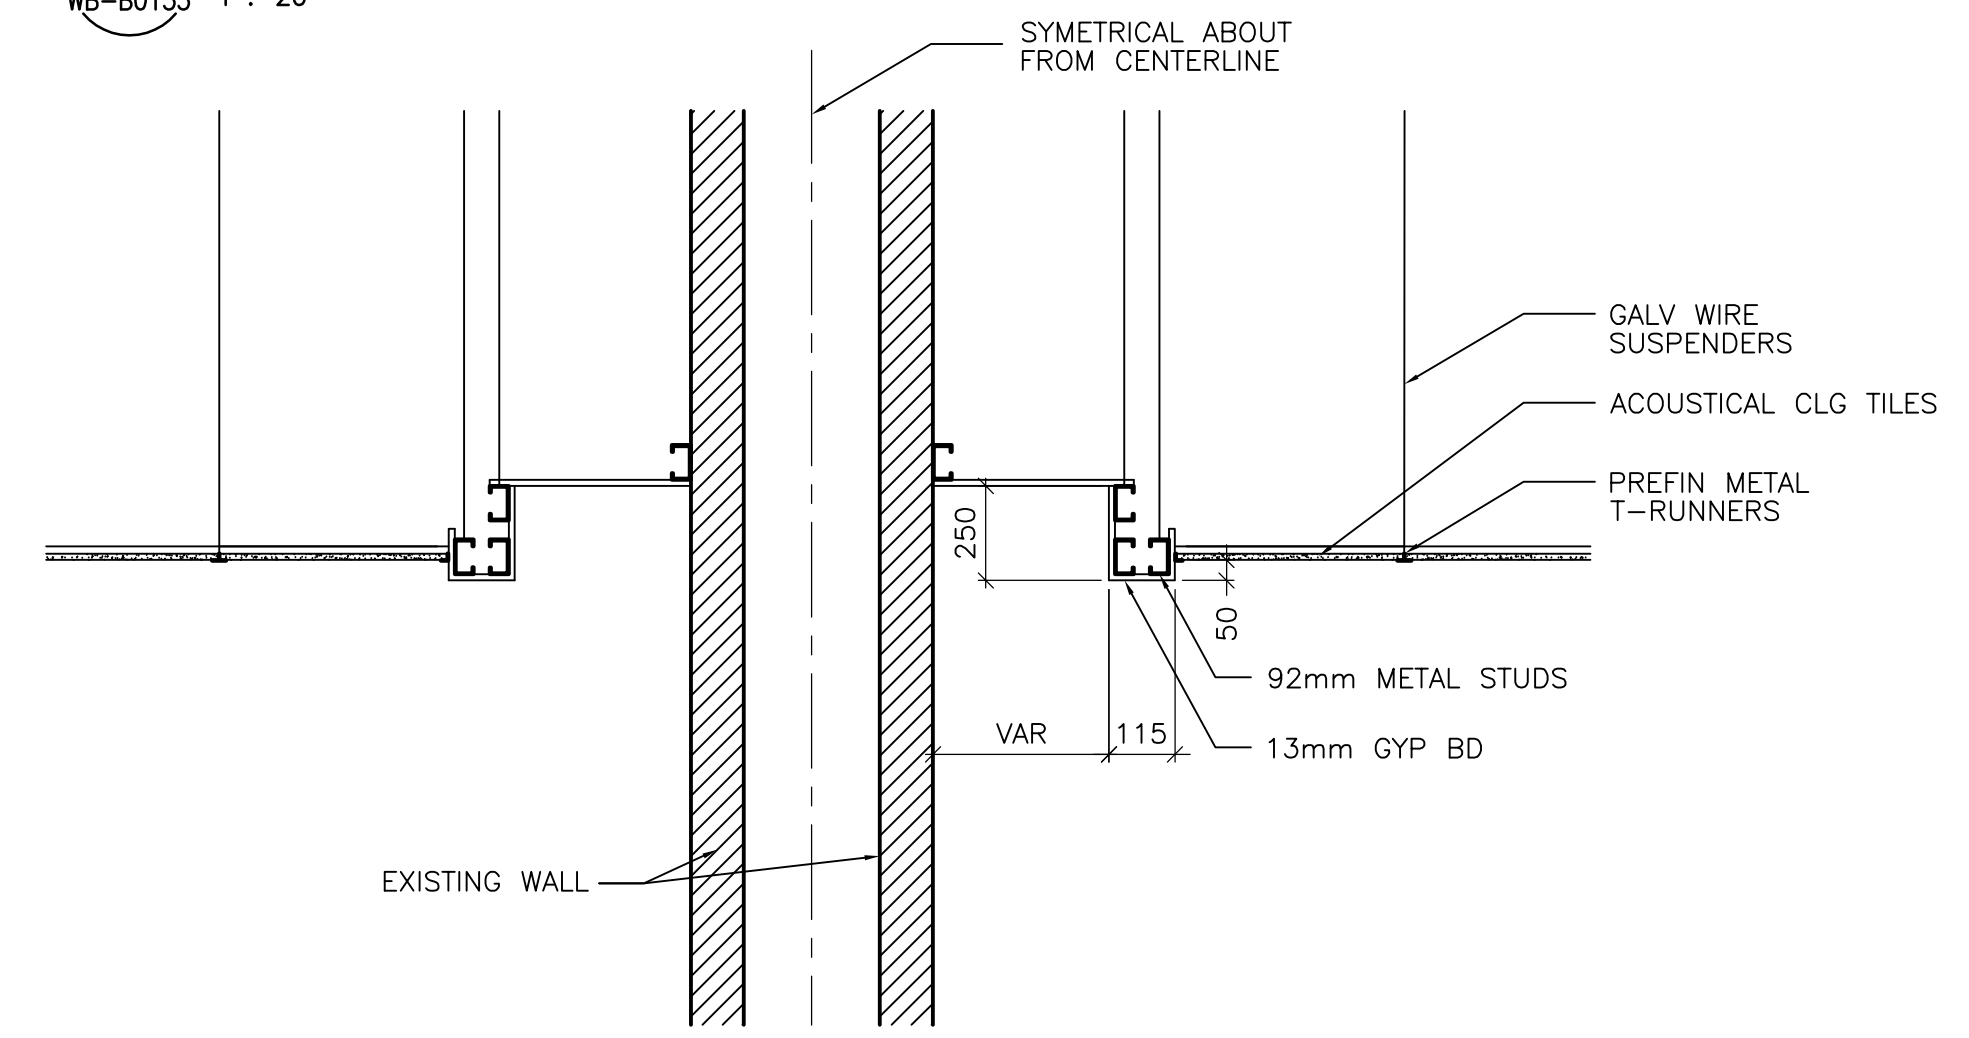

4 TYP CEILING DETAIL @ LIGHTING COVE  
WB-B0154 1 : 20

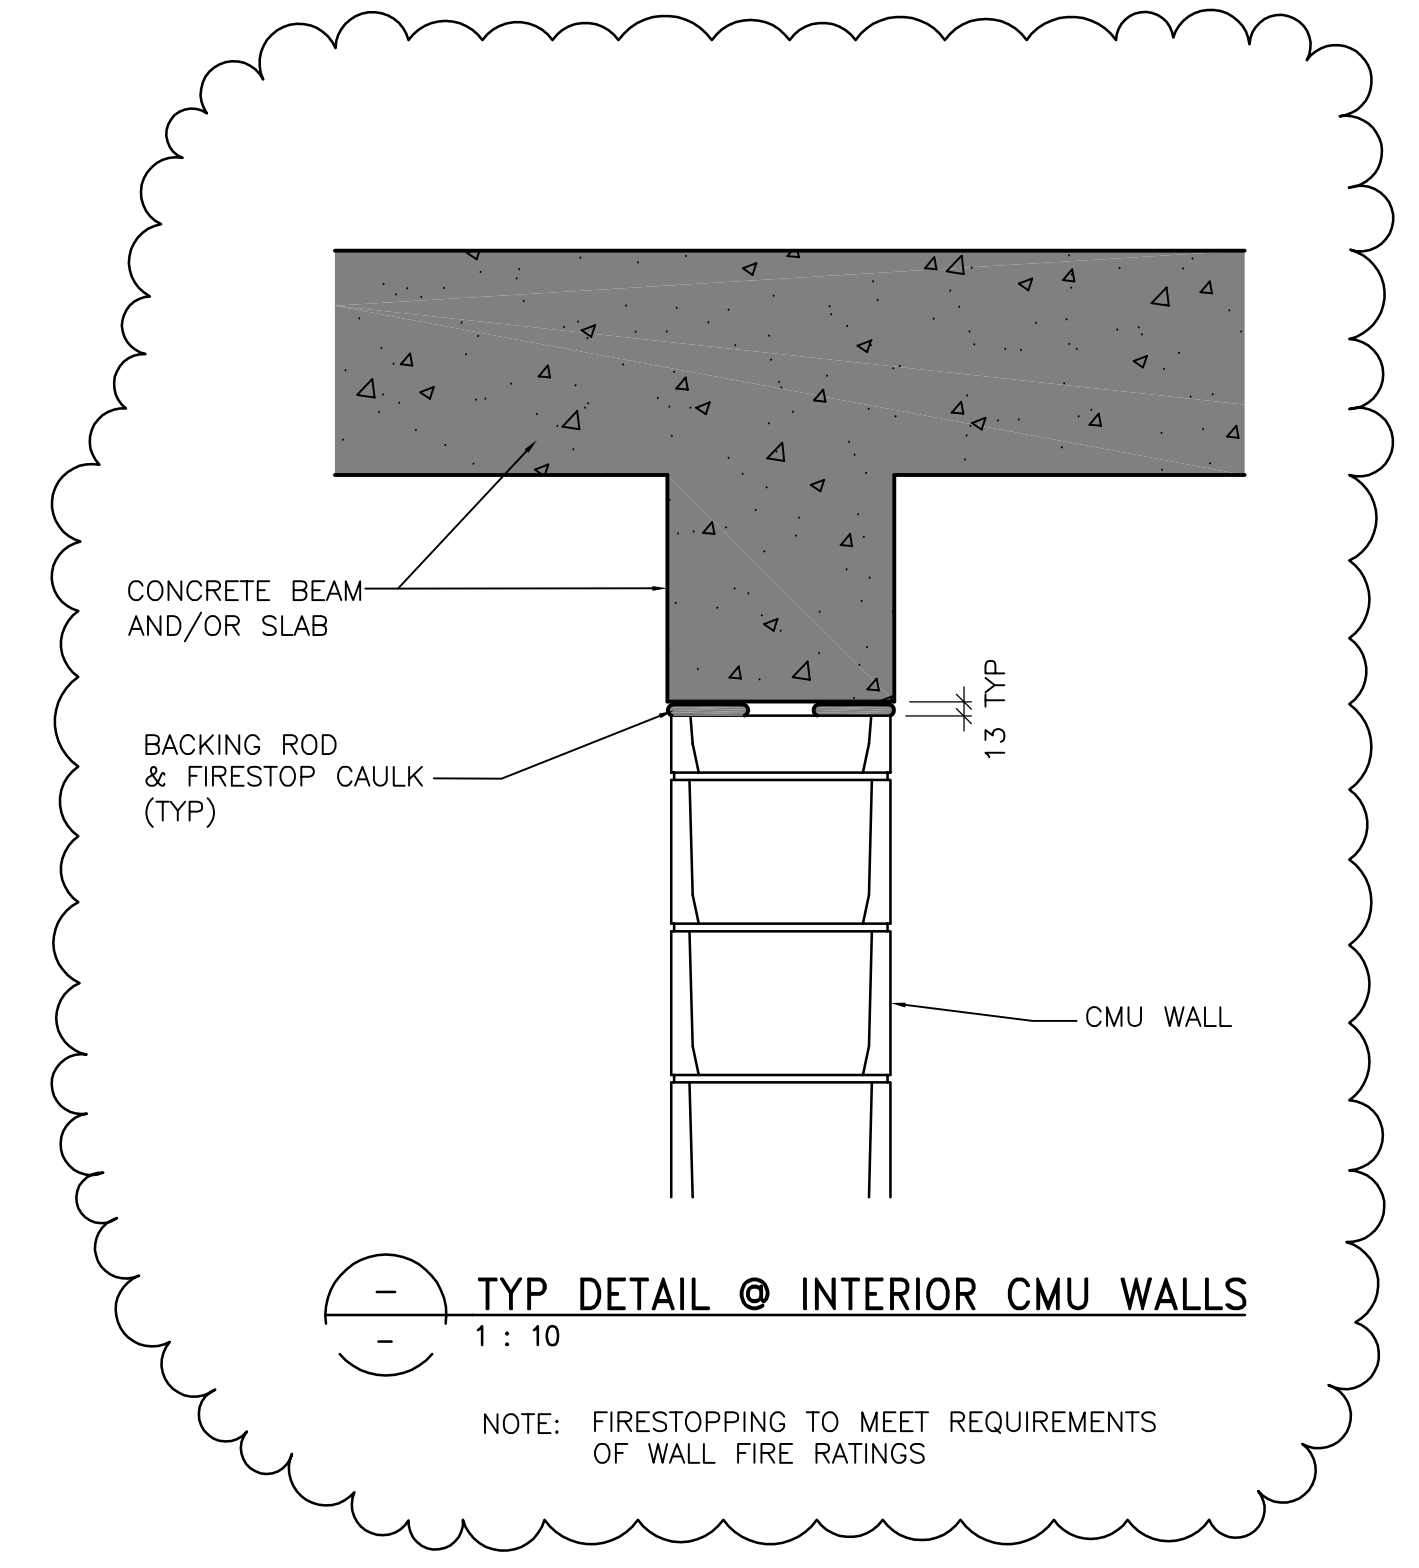

TYP DETAIL @ INTERIOR CMU WALLS  
1 : 10

NOTE: FIRESTOPPING TO MEET REQUIREMENTS OF WALL FIRE RATINGS



NO.	REVISIONS	DATE	BY
01	95-2007 ADDENDUM 01	07/06/12	LK
00	ISSUED FOR TENDER	07/06/05	LK

DESIGNED BY	MG	CHECKED BY	BJS
DRAWN BY	AL	APPROVED BY	AHL
SCALE:	AS NOTED	RELEASED FOR CONSTRUCTION BY:	R. SOROKOWSKI
DATE	2005/08/05	DATE	2007/06/05

ENGINEER'S SEAL
ORIGINAL SIGNED BY NEIL COOPER 2007/06/05
CONSULTANT DRAWING NO. WB-B0154

THE CITY OF WINNIPEG WATER AND WASTE DEPARTMENT ENGINEERING DIVISION	
WATER TREATMENT PLANT MAIN BUILDING OFFICE AND PLANT INTERIOR FINISHES	CITY FILE NUMBER SHEET OF
ARCHITECTURAL WALL SECTION AND CEILING DETAILS	CITY DRAWING NUMBER 1-0608-A-B0154-00-01D