


**LEGEND**

- ACOUSTIC LINING
- BALANCE DAMPER
- FIRE DAMPER

**NOTE:**

1. DIFFUSER LOCATIONS TO BE COORDINATED WITH FINAL LIGHT LOCATIONS
2. REFRIGERANT LINE SHALL HAVE FLEXIBLE CONNECTION BETWEEN THE EXTERIOR WALL AND CONDENSING UNIT

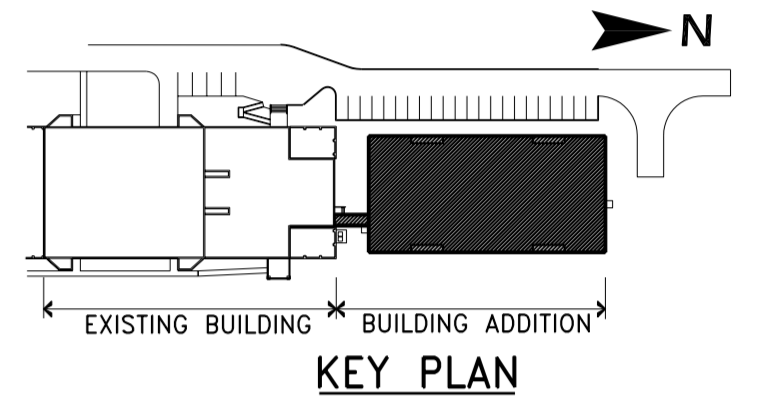

- THIS DRAWING MUST NOT BE SCALED.
- THE GENERAL CONTRACTOR SHALL VERIFY ALL DIMENSIONS, DATINGS, AND LEVELS PRIOR TO COMMENCEMENT OF WORK. ALL ERRORS AND OMISSIONS TO BE REPORTED TO WARDROP ENGINEERING INC. BEFORE PROCEEDING.
- VARIATIONS AND MODIFICATIONS TO WORK SHOWN ON THESE DRAWINGS SHALL NOT BE CARRIED OUT WITHOUT WRITTEN PERMISSION OF WARDROP ENGINEERING INC.
- THIS DRAWING IS THE EXCLUSIVE PROPERTY OF WARDROP ENGINEERING INC AND THE COPYRIGHT IN THE SAME BEING RESERVED TO THEM. IT MAY BE REPRODUCED ONLY WITH THE PERMISSION OF WARDROP ENGINEERING INC, IN WHICH CASE THE REPRODUCTION MUST BEAR THEIR NAME.

▲	ISSUED FOR TENDER	7 MAY 2003
▲	REVISED/ ISSUED/ PLOTTED	DATE


**number** Number **TEN** Architectural Group  
 310-115 Barmatyne Ave. Phone (204) 942-0981  
 Winnipeg, Manitoba Fax (204) 947-9626  
 Canada R3B 0R3 E-mail 10@number10.com

**ST. JAMES-ASSINIBOIA CENTENNIAL POOL FITNESS FACILITY ADDITION**  
 644 PARKDALE ST. WINNIPEG, MB

**MECHANICAL MAIN FLOOR HVAC**

**WARDROP** Engineering Inc.  
 CONSULTING ENGINEER

ARCHITECTURAL SEAL	SEAL
DRAWN BY: H.P.C.C./E.V.	SCALE: AS NOTED
CHECKED BY: M.B./J.B.	DATE: MAY 2003
TENDER NO: 10/2003	PROJECT NO: 02049
PROJECT NO:	SHEET NO: <b>M2.1</b>

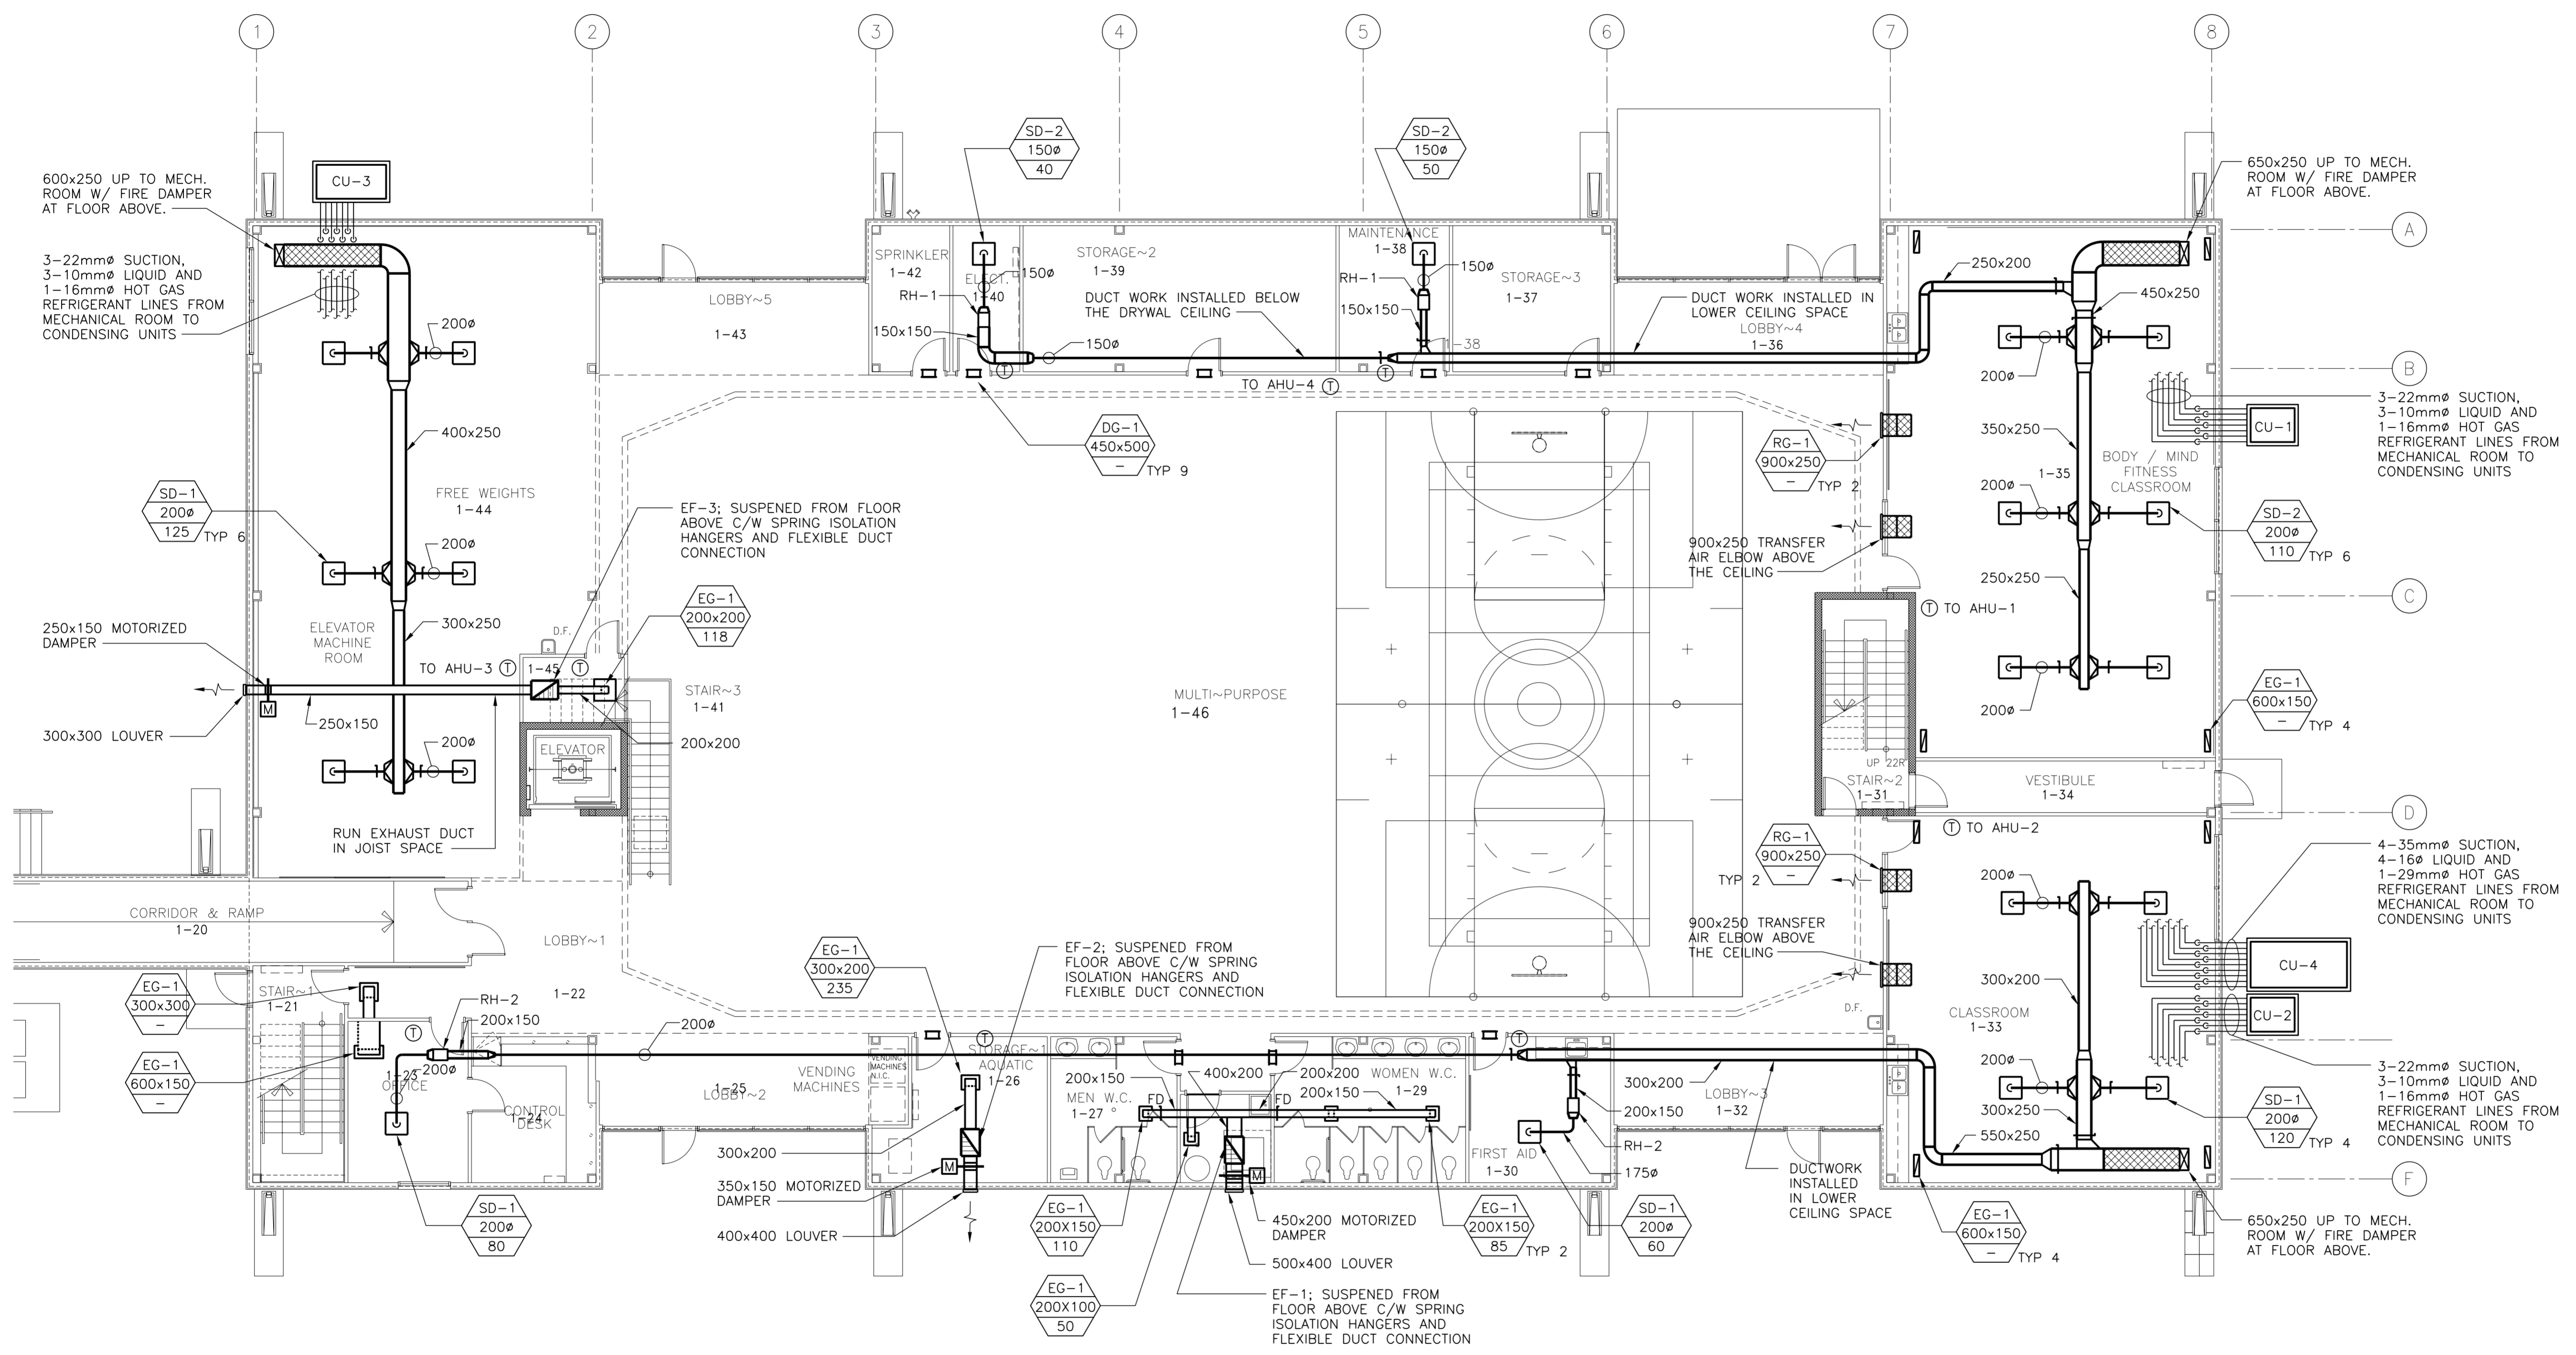

**1 MAIN FLOOR PLAN**  
 1 : 100

